

- NOTES**
1. THIS DRAWING IS THE PROPERTY OF **Builders and Designers (A Unit of MAESTER (R))**, AND SHALL NOT BE COPIED OR USED WITHOUT PRIOR PERMISSION.
 2. THE DRAWING IS NOT TO THE SCALE. ONLY WRITTEN DIMENSION SHALL BE FOLLOWED.
 3. ALL DIMENSIONS ARE IN MM.

TITLE

Architectural Floor Plan
Duplex Residential
Building


SCALE: NTS

CLIENT:-
Tulsiyan Family

DATE OF ISSUE:

REVISIONS SHEET A3

SN	REVISION NO	DATE
01	R0	
02		
03		

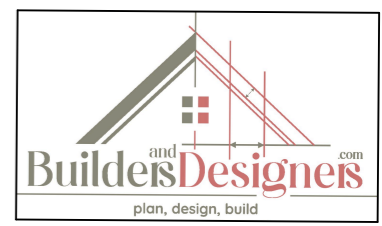


DESIGN BY TABREZ

DRAWN BY TAHER

CHECKED BY TABREZ

DRAWING NO RWSH-1

ALL DIMENSIONS ARE IN FT

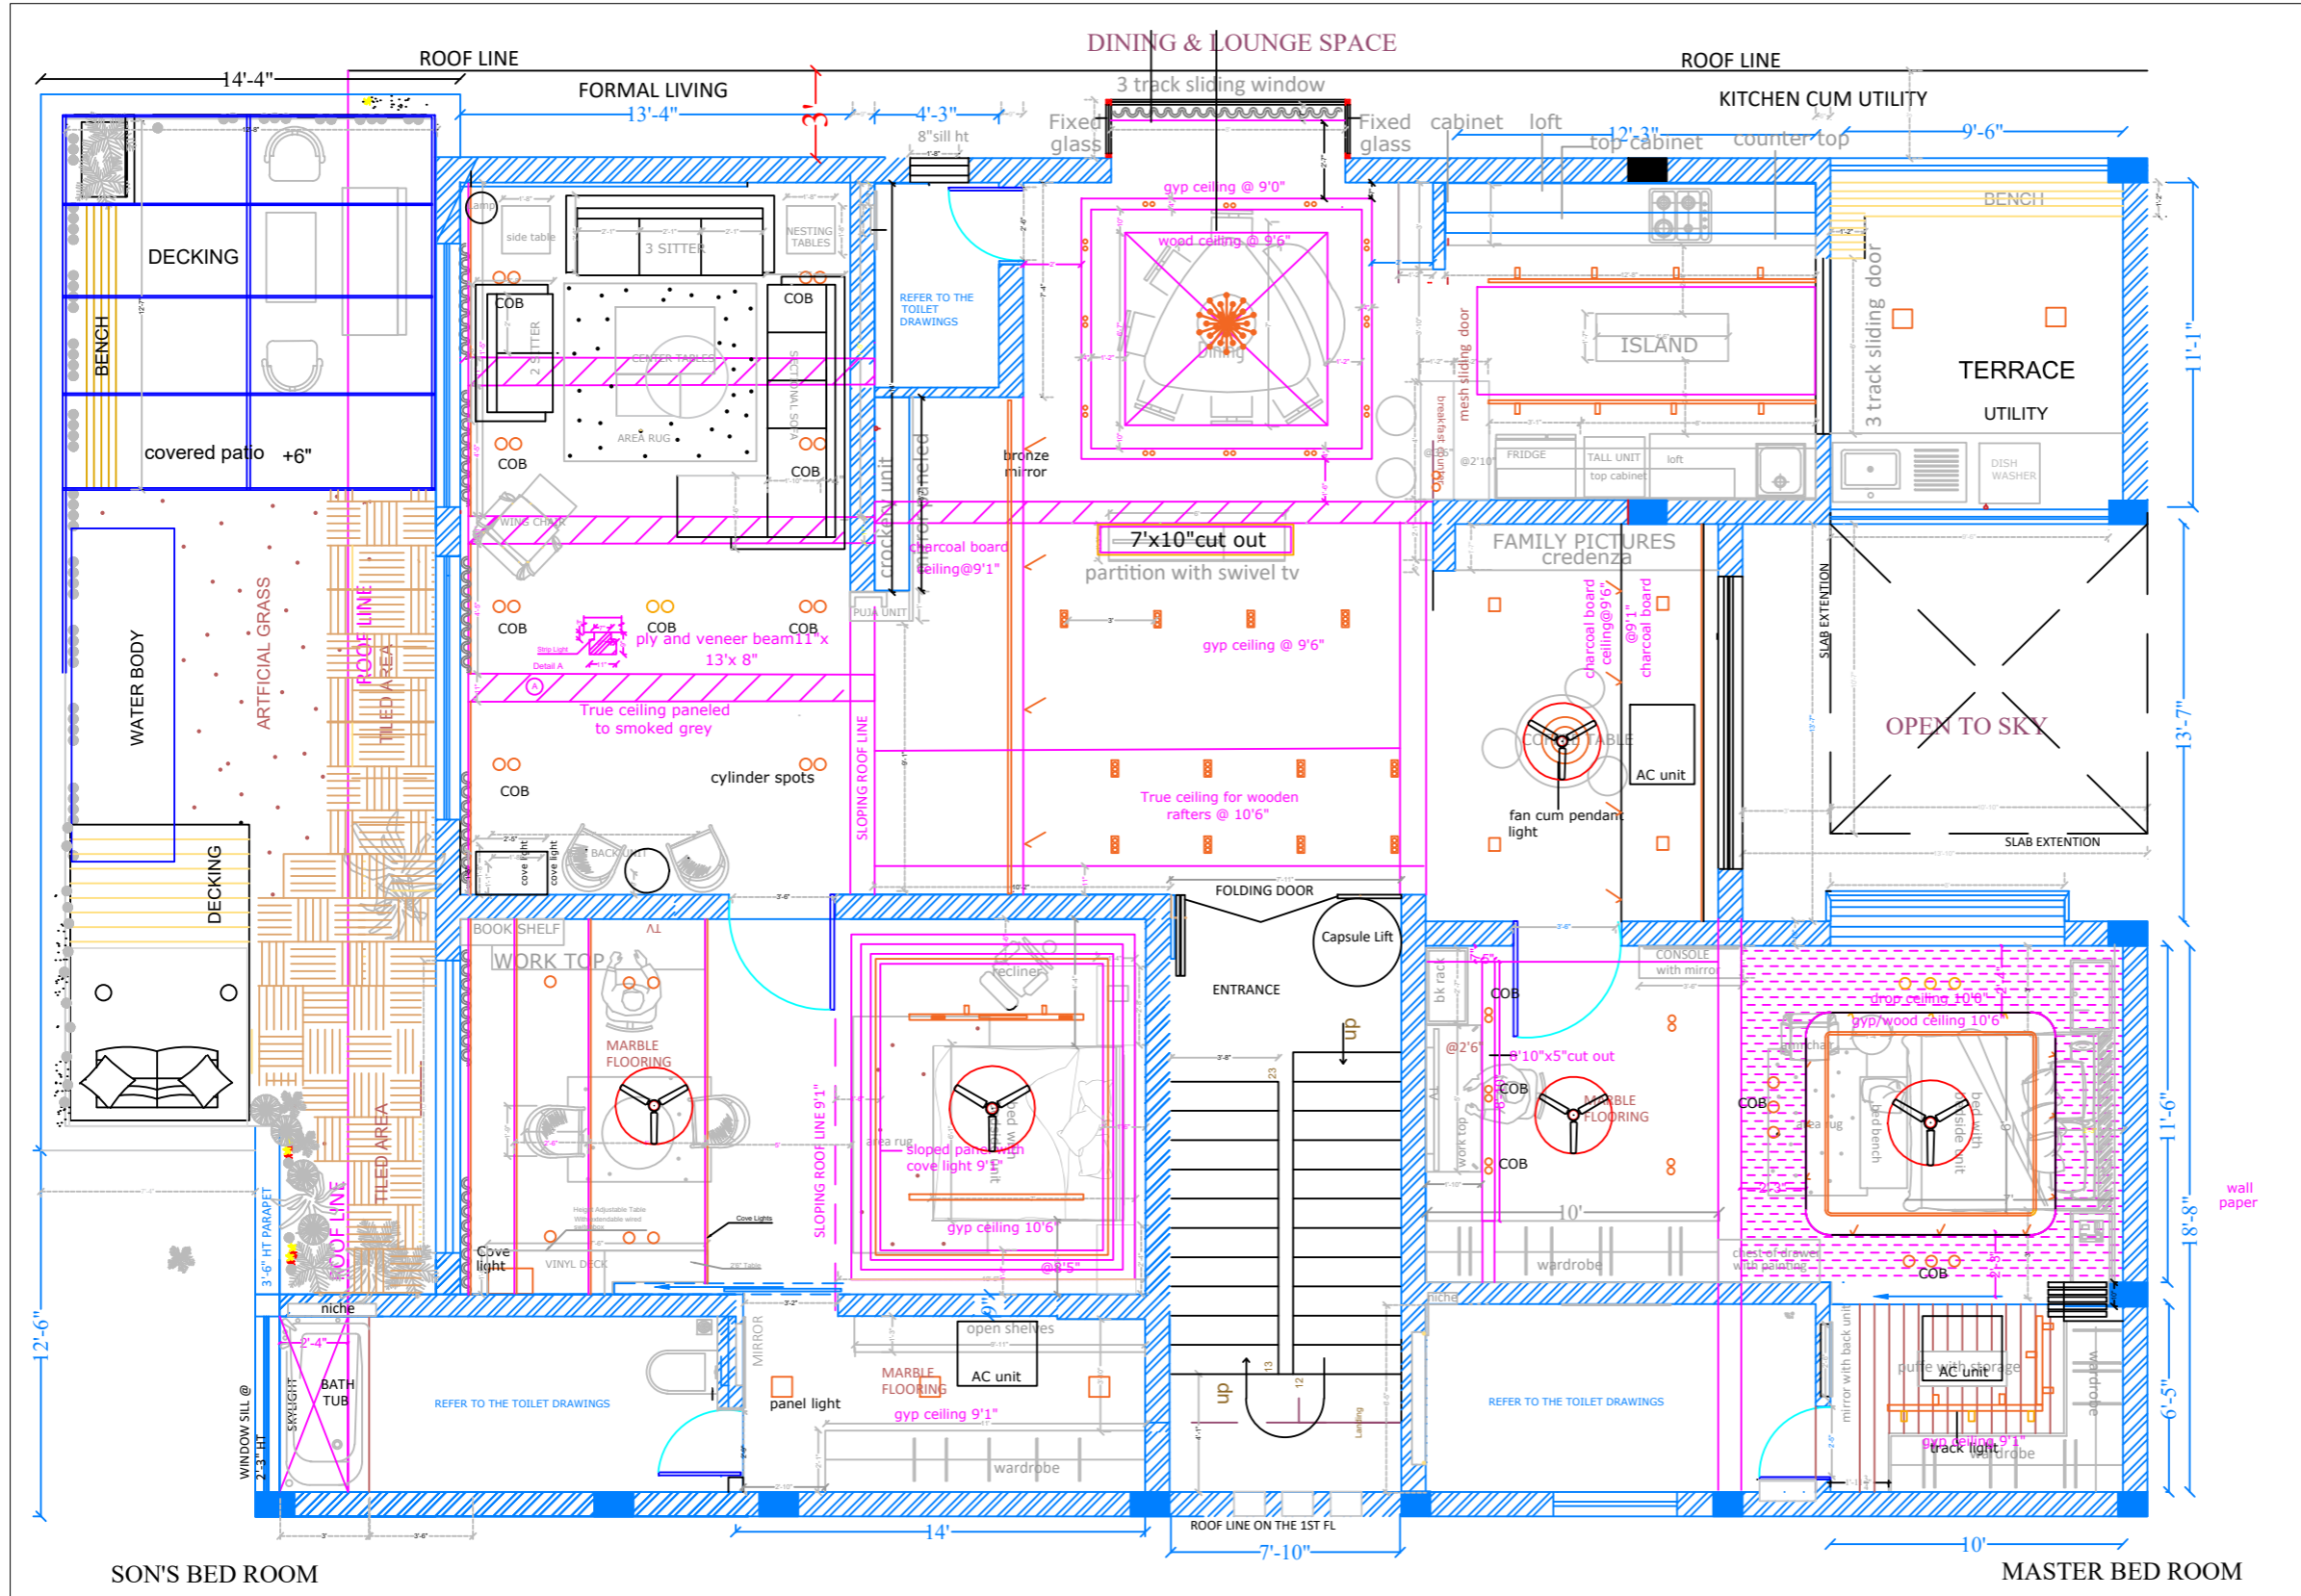

- NOTES**
1. THIS DRAWING IS THE PROPERTY OF Builders and Designers (A Unit of MAESTER (R)), AND SHELL NOT BE COPIED OR USED WITHOUT PRIOR PERMISSION.
 2. THE DRAWING IS NOT TO THE SCALE. ONLY WRITTEN DIMENSION SHALL BE FOLLOWED.
 3. ALL DIMENSIONS ARE IN MM.

TITLE

Architectural Beam Layout with Floor Plan

SCALE: NTS


CLIENT:- Tulsian Family

DATE OF ISSUE: 21.04.2026

REVISIONS

SN	REVISION NO	DATE
01	R0	21-04-2026
02		
03		

SHEET A3

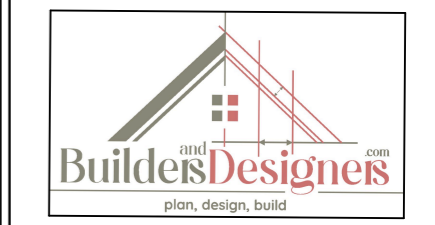


DESIGN BY TABREZ

DRAWN BY TAHER

CHECKED BY TABREZ

DRAWING NO RWSH-12

ALL DIMENSIONS ARE IN FT

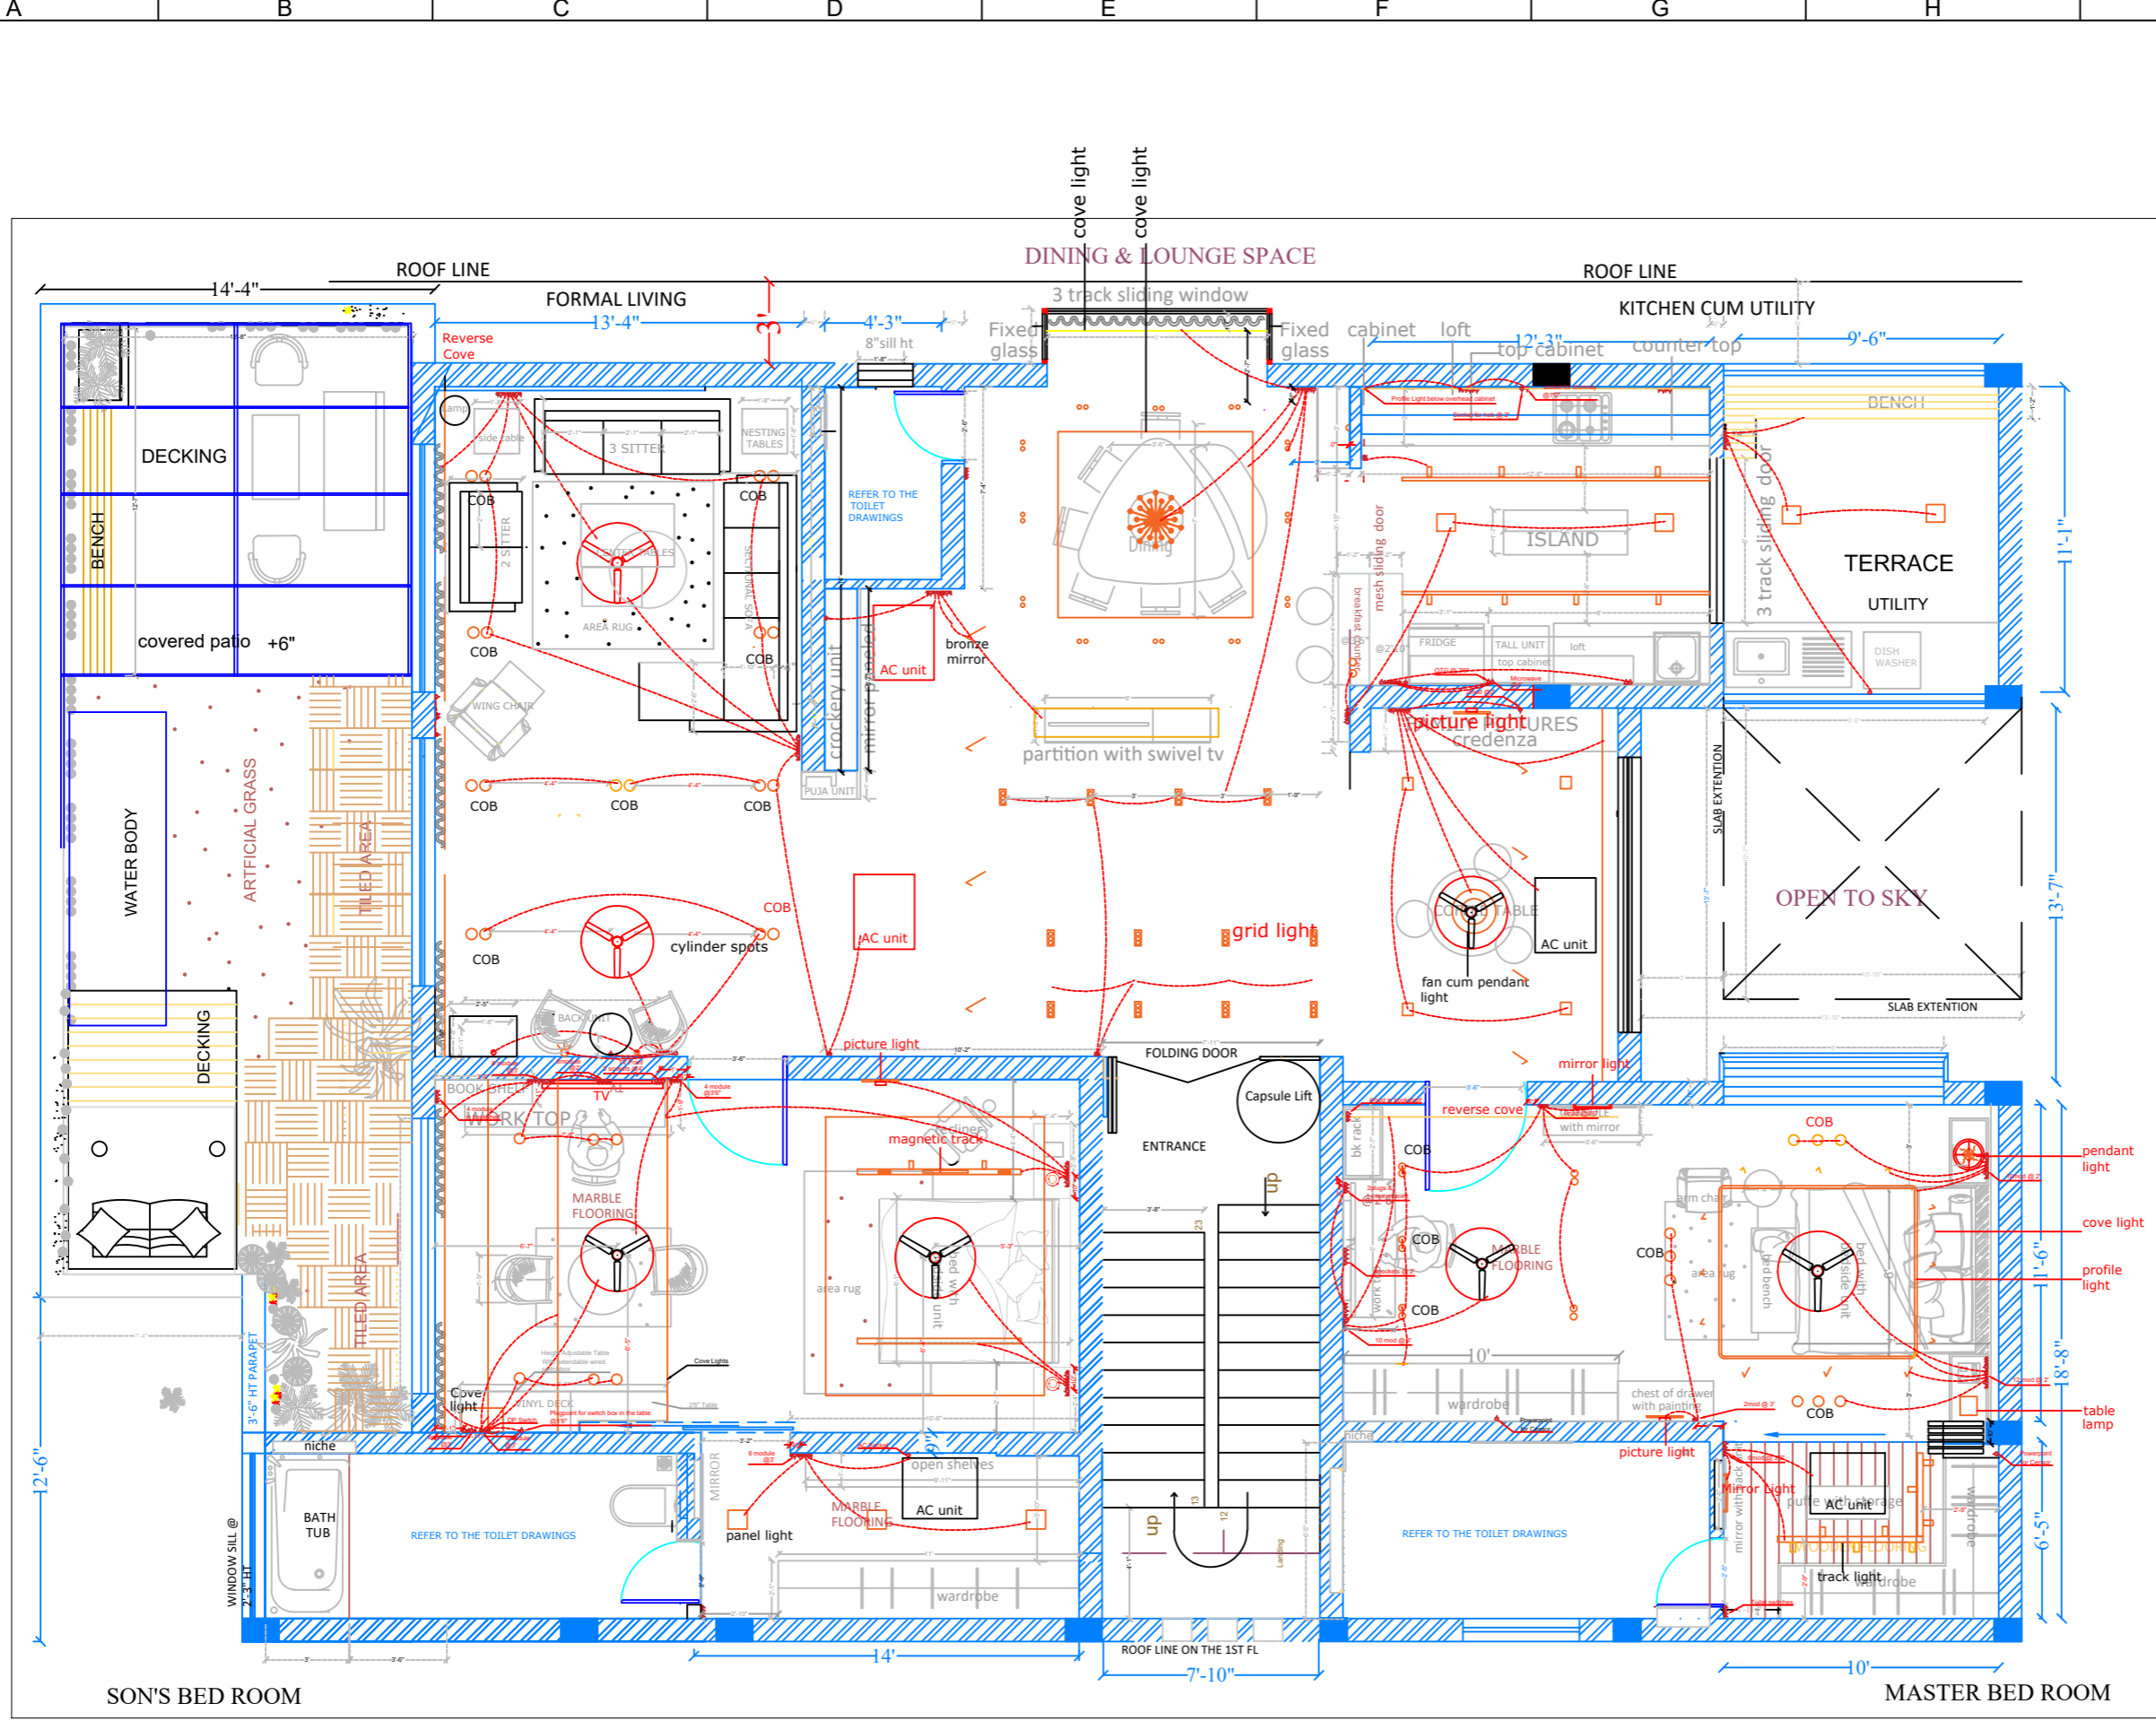

NOTES


1. THIS DRAWING IS THE PROPERTY OF **Builders and Designers (A Unit of MAESTER (R))**, AND SHALL NOT BE COPIED OR USED WITHOUT PRIOR PERMISSION.
2. THE DRAWING IS NOT TO THE SCALE. ONLY WRITTEN DIMENSION SHALL BE FOLLOWED.
3. ALL DIMENSIONS ARE IN MM.

TITLE

Electrical Layout with Floor Plan

SCALE: NTS


CLIENT:- Tulsyan Family

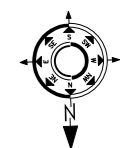

DATE OF ISSUE: 21.04.2026

REVISIONS SHEET A3

SN	REVISION NO	DATE
01	R0	21-04-2026
02		
03		

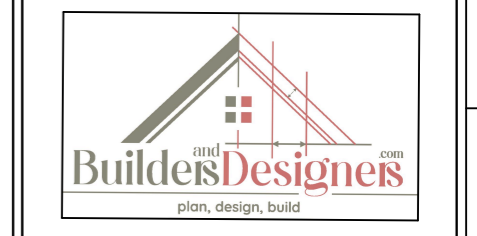


DESIGN BY TABREZ

DRAWN BY TAHER

CHECKED BY TABREZ

DRAWING NO RWSH-12

ALL DIMENSIONS ARE IN FT

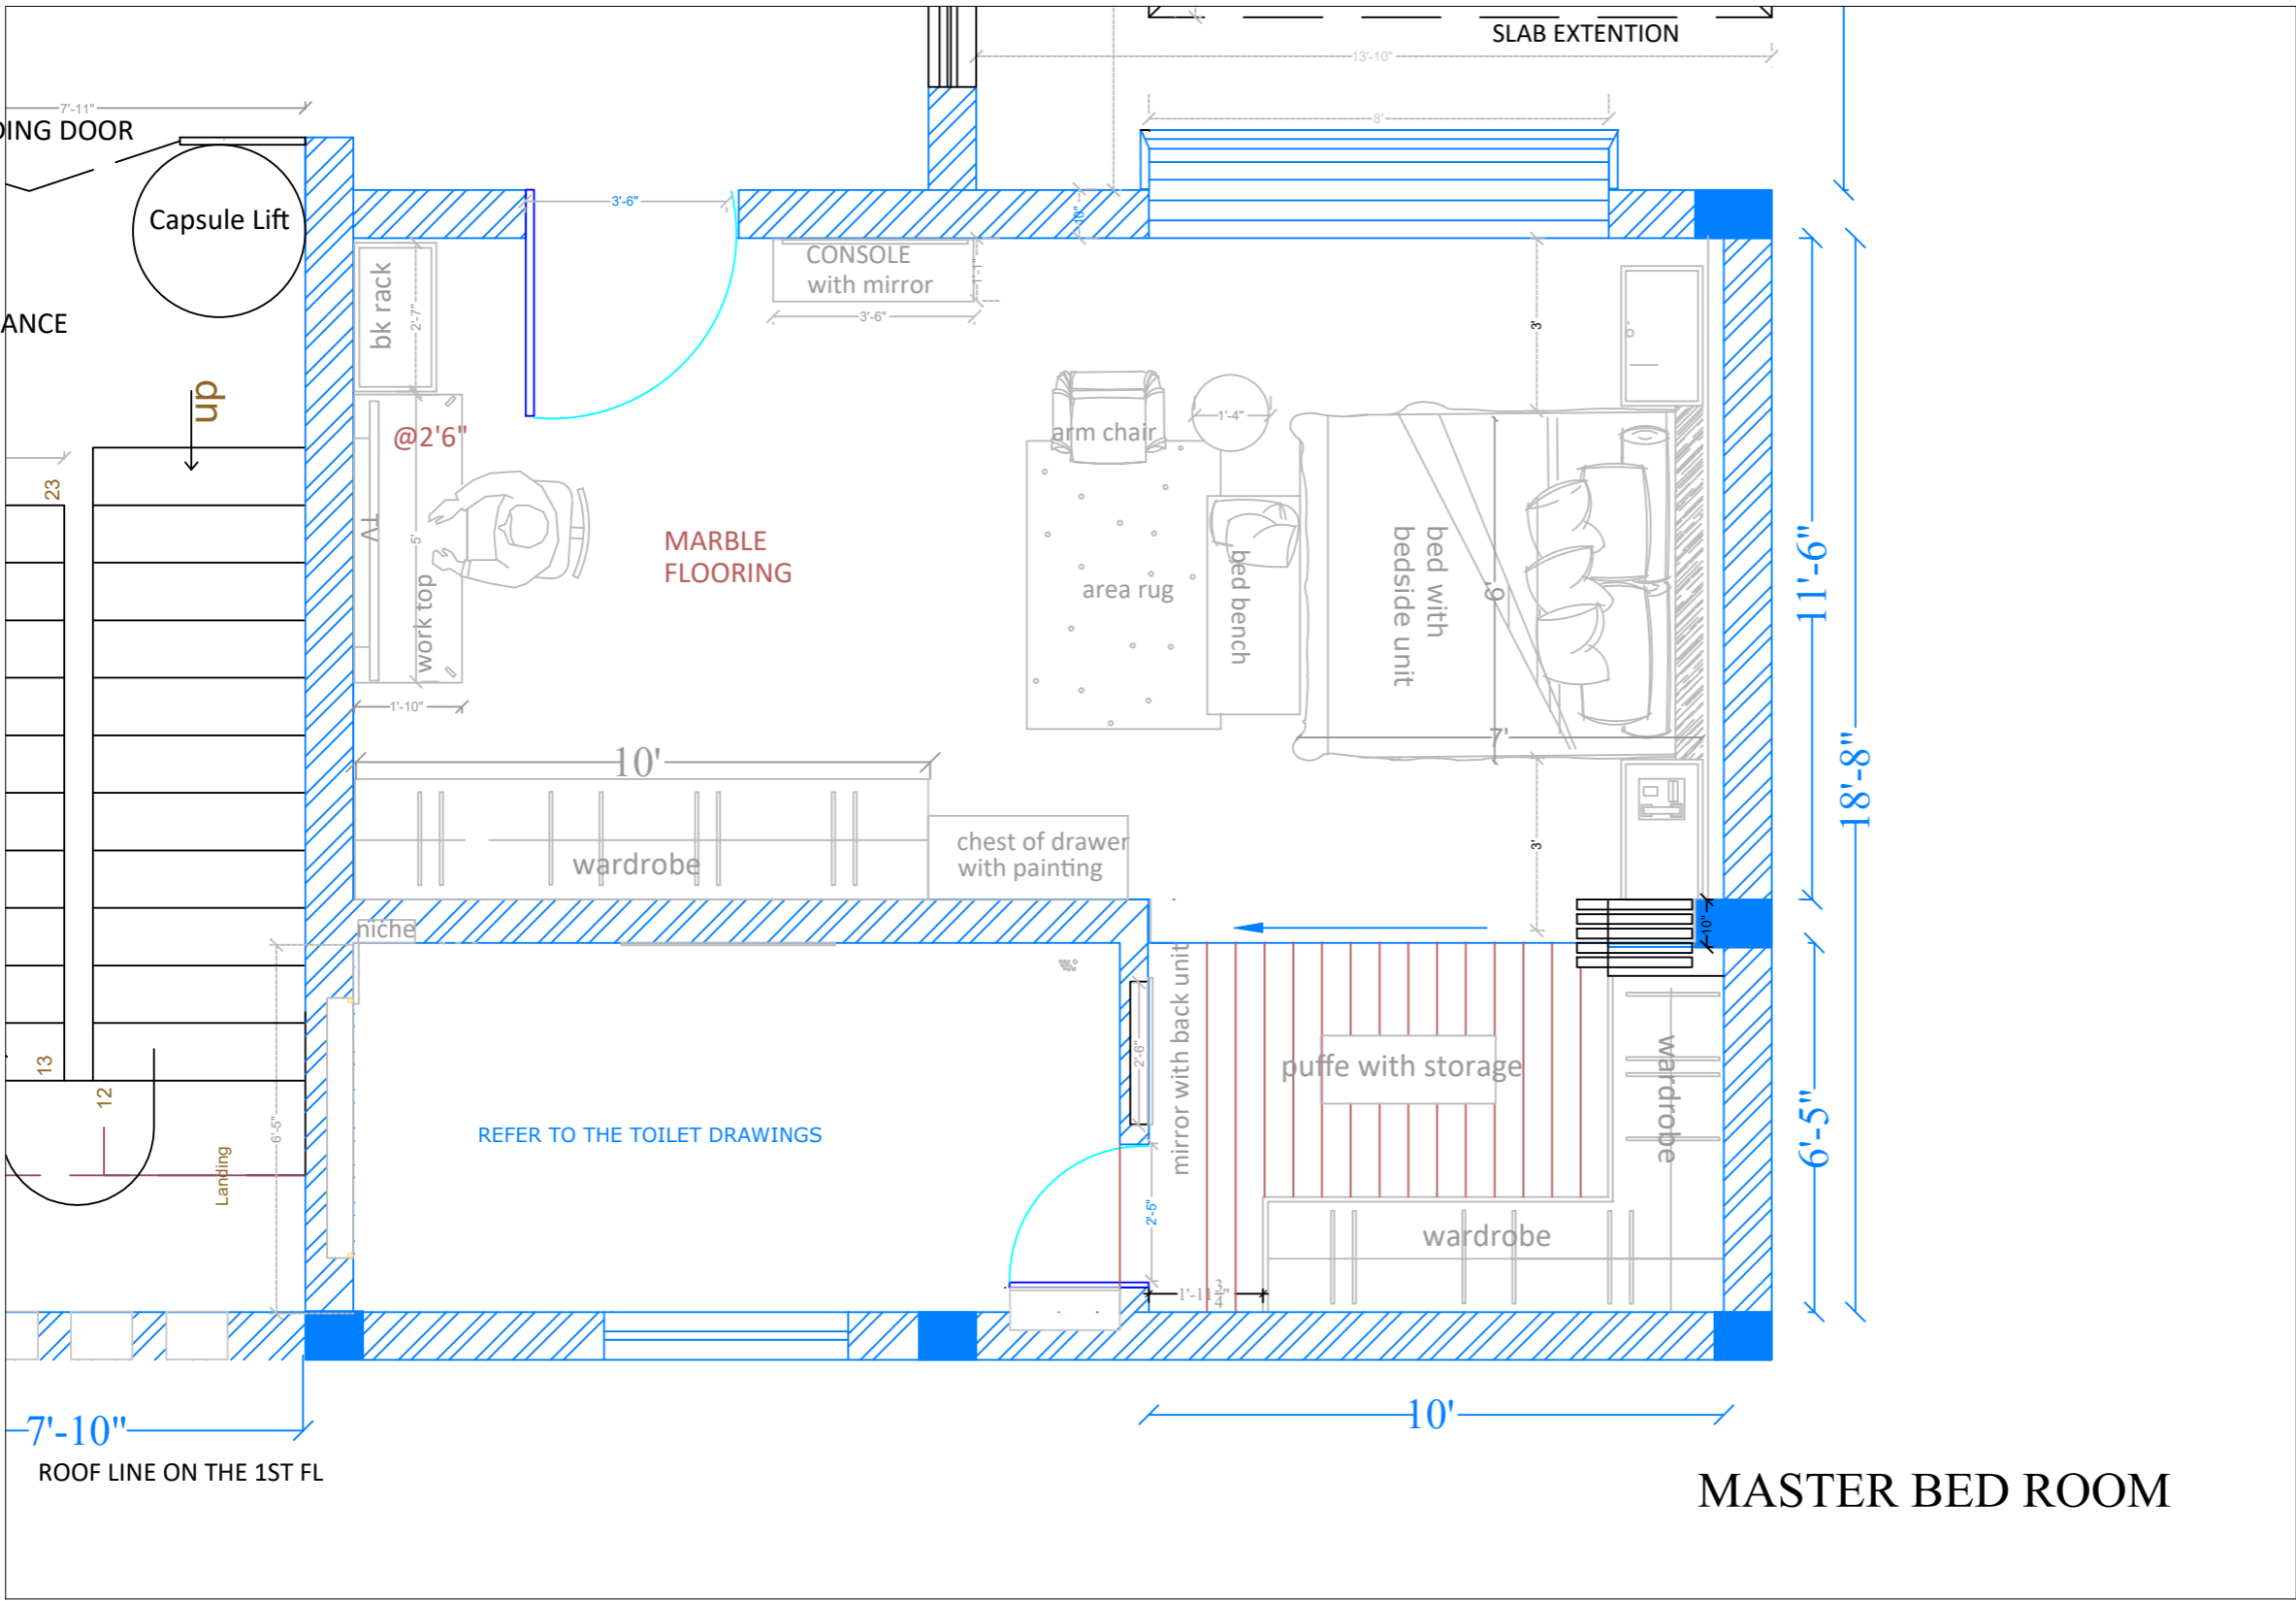

MASTER BED ROOM

NOTES

 
1. THIS DRAWING IS THE PROPERTY OF **Builders and Designers (A Unit of MAESTER (R))**, AND SHELL NOT BE COPIED OR USED WITHOUT PRIOR PERMISSION.
2. THE DRAWING IS NOT TO THE SCALE. ONLY WRITTEN DIMENSION SHALL BE FOLLOWED.
3. ALL DIMENSIONS ARE IN MM.

TITLE

MASTER BED ROOM Plan

SCALE: NTS

CLIENT:-
Tulsiyan Family




DATE OF ISSUE: 21.04.2026

REVISIONS

SN	REVISION NO	DATE
01	R0	21-04-2026
02		
03		

SHEET A3

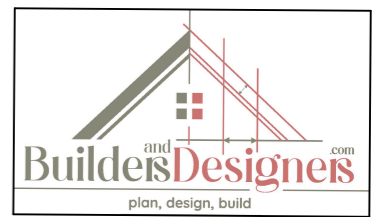


DESIGN BY TABREZ

DRAWN BY TAHER

CHECKED BY TABREZ

DRAWING NO RWSH-12

ALL DIMENSIONS ARE IN FT

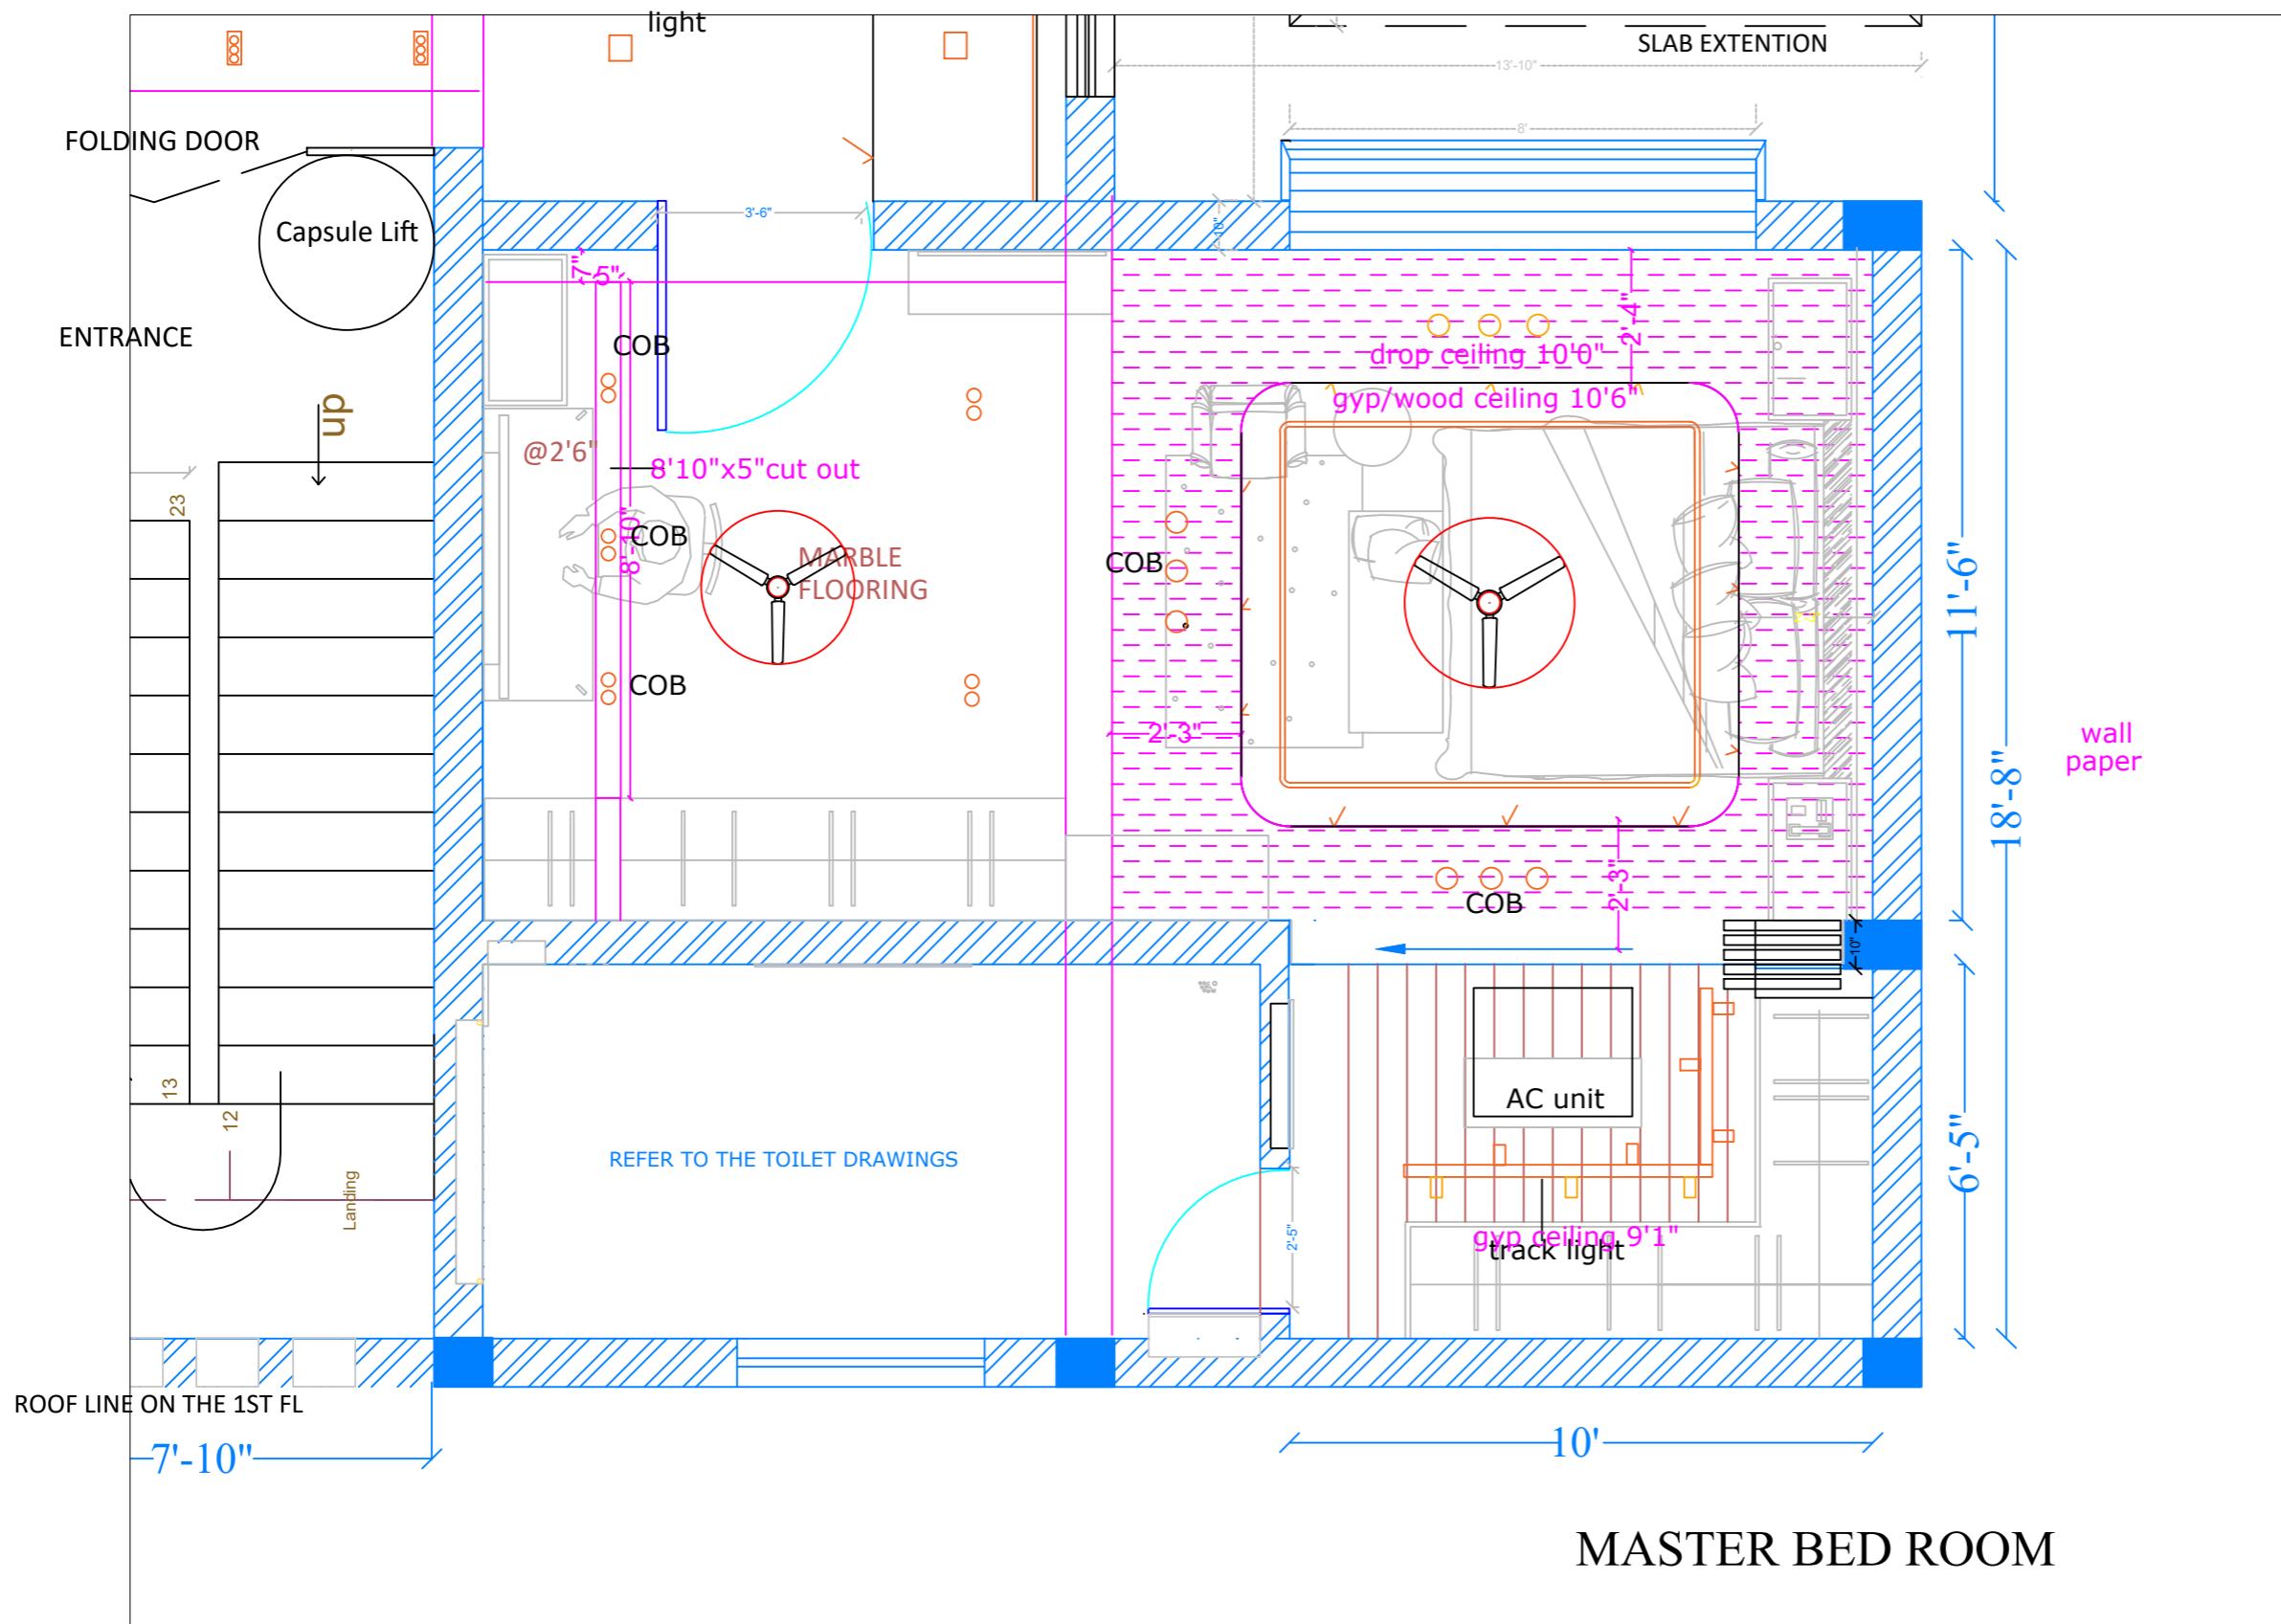

MASTER BED ROOM

wall paper


- NOTES**
1. THIS DRAWING IS THE PROPERTY OF **Builders and Designers (A Unit of MAESTER (R))**, AND SHELL NOT BE COPIED OR USED WITHOUT PRIOR PERMISSION.
 2. THE DRAWING IS NOT TO THE SCALE. ONLY WRITTEN DIMENSION SHALL BE FOLLOWED.
 3. ALL DIMENSIONS ARE IN MM.

TITLE

**Master Bedroom
Beam Layout**

SCALE: NTS


CLIENT:-
Tulsiyan Family

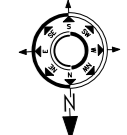

DATE OF ISSUE: 21.04.2026

REVISIONS SHEET A3

SN	REVISION NO	DATE
01	R0	21-04-2026
02		
03		

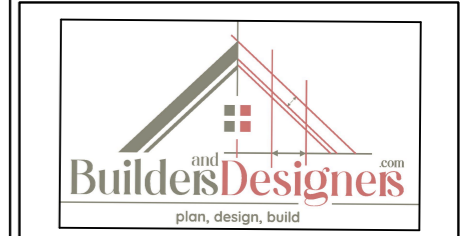

DESIGN BY TABREZ

DRAWN BY TAHER


CHECKED BY TABREZ

DRAWING NO RWSH-12

ALL DIMENSIONS ARE IN FT

A B C D E F G H I J

1
2
3
4
5
6
7

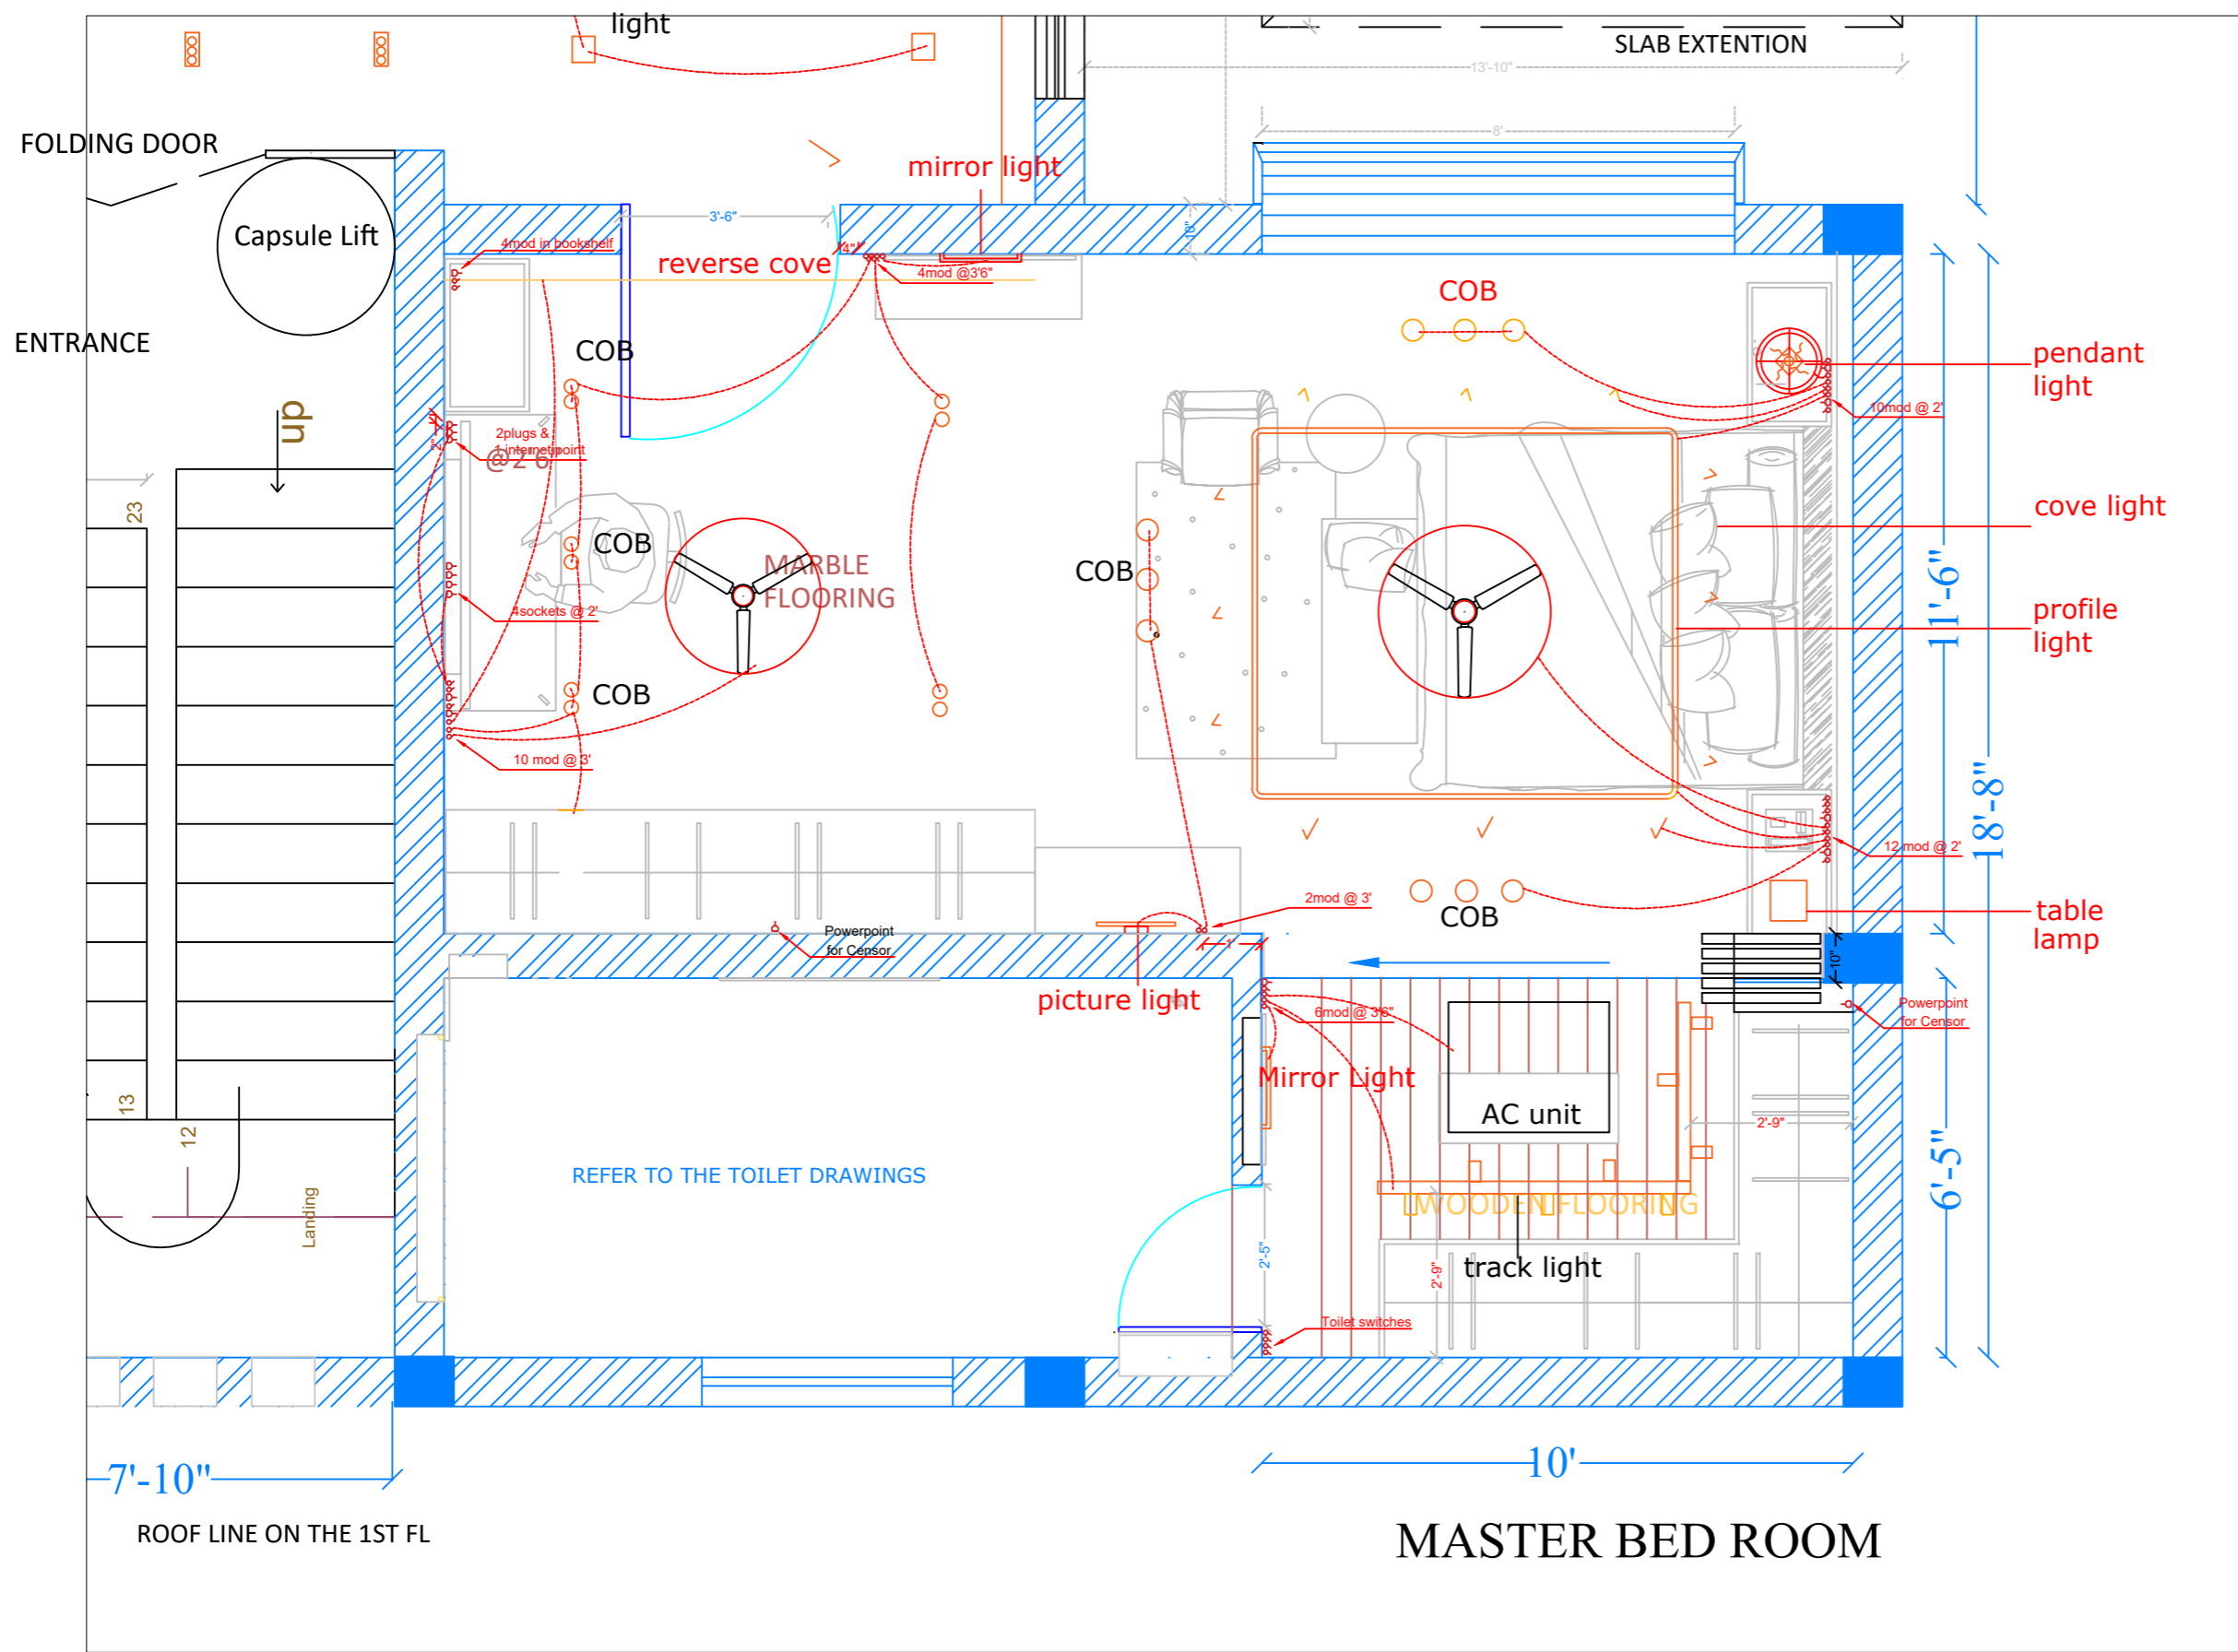


NOTES

1. THIS DRAWING IS THE PROPERTY OF **Builders and Designers (A Unit of MAESTER (R))**, AND SHALL NOT BE COPIED OR USED WITHOUT PRIOR PERMISSION.
2. THE DRAWING IS NOT TO THE SCALE. ONLY WRITTEN DIMENSION SHALL BE FOLLOWED.
3. ALL DIMENSIONS ARE IN MM.

TITLE

**Master Bedroom
Electrical Layout**

SCALE: NTS
CLIENT:-
Tulsiyan Family

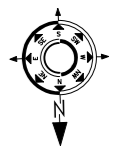

DATE OF ISSUE: 21.04.2026

REVISIONS SHEET A3


SN	REVISION NO	DATE
01	R0	21-04-2026
02		
03		



DESIGN BY TABREZ
DRAWN BY TAHER
CHECKED BY TABREZ
DRAWING NO RWSH-12

ALL DIMENSIONS ARE IN FT

MASTER BED ROOM

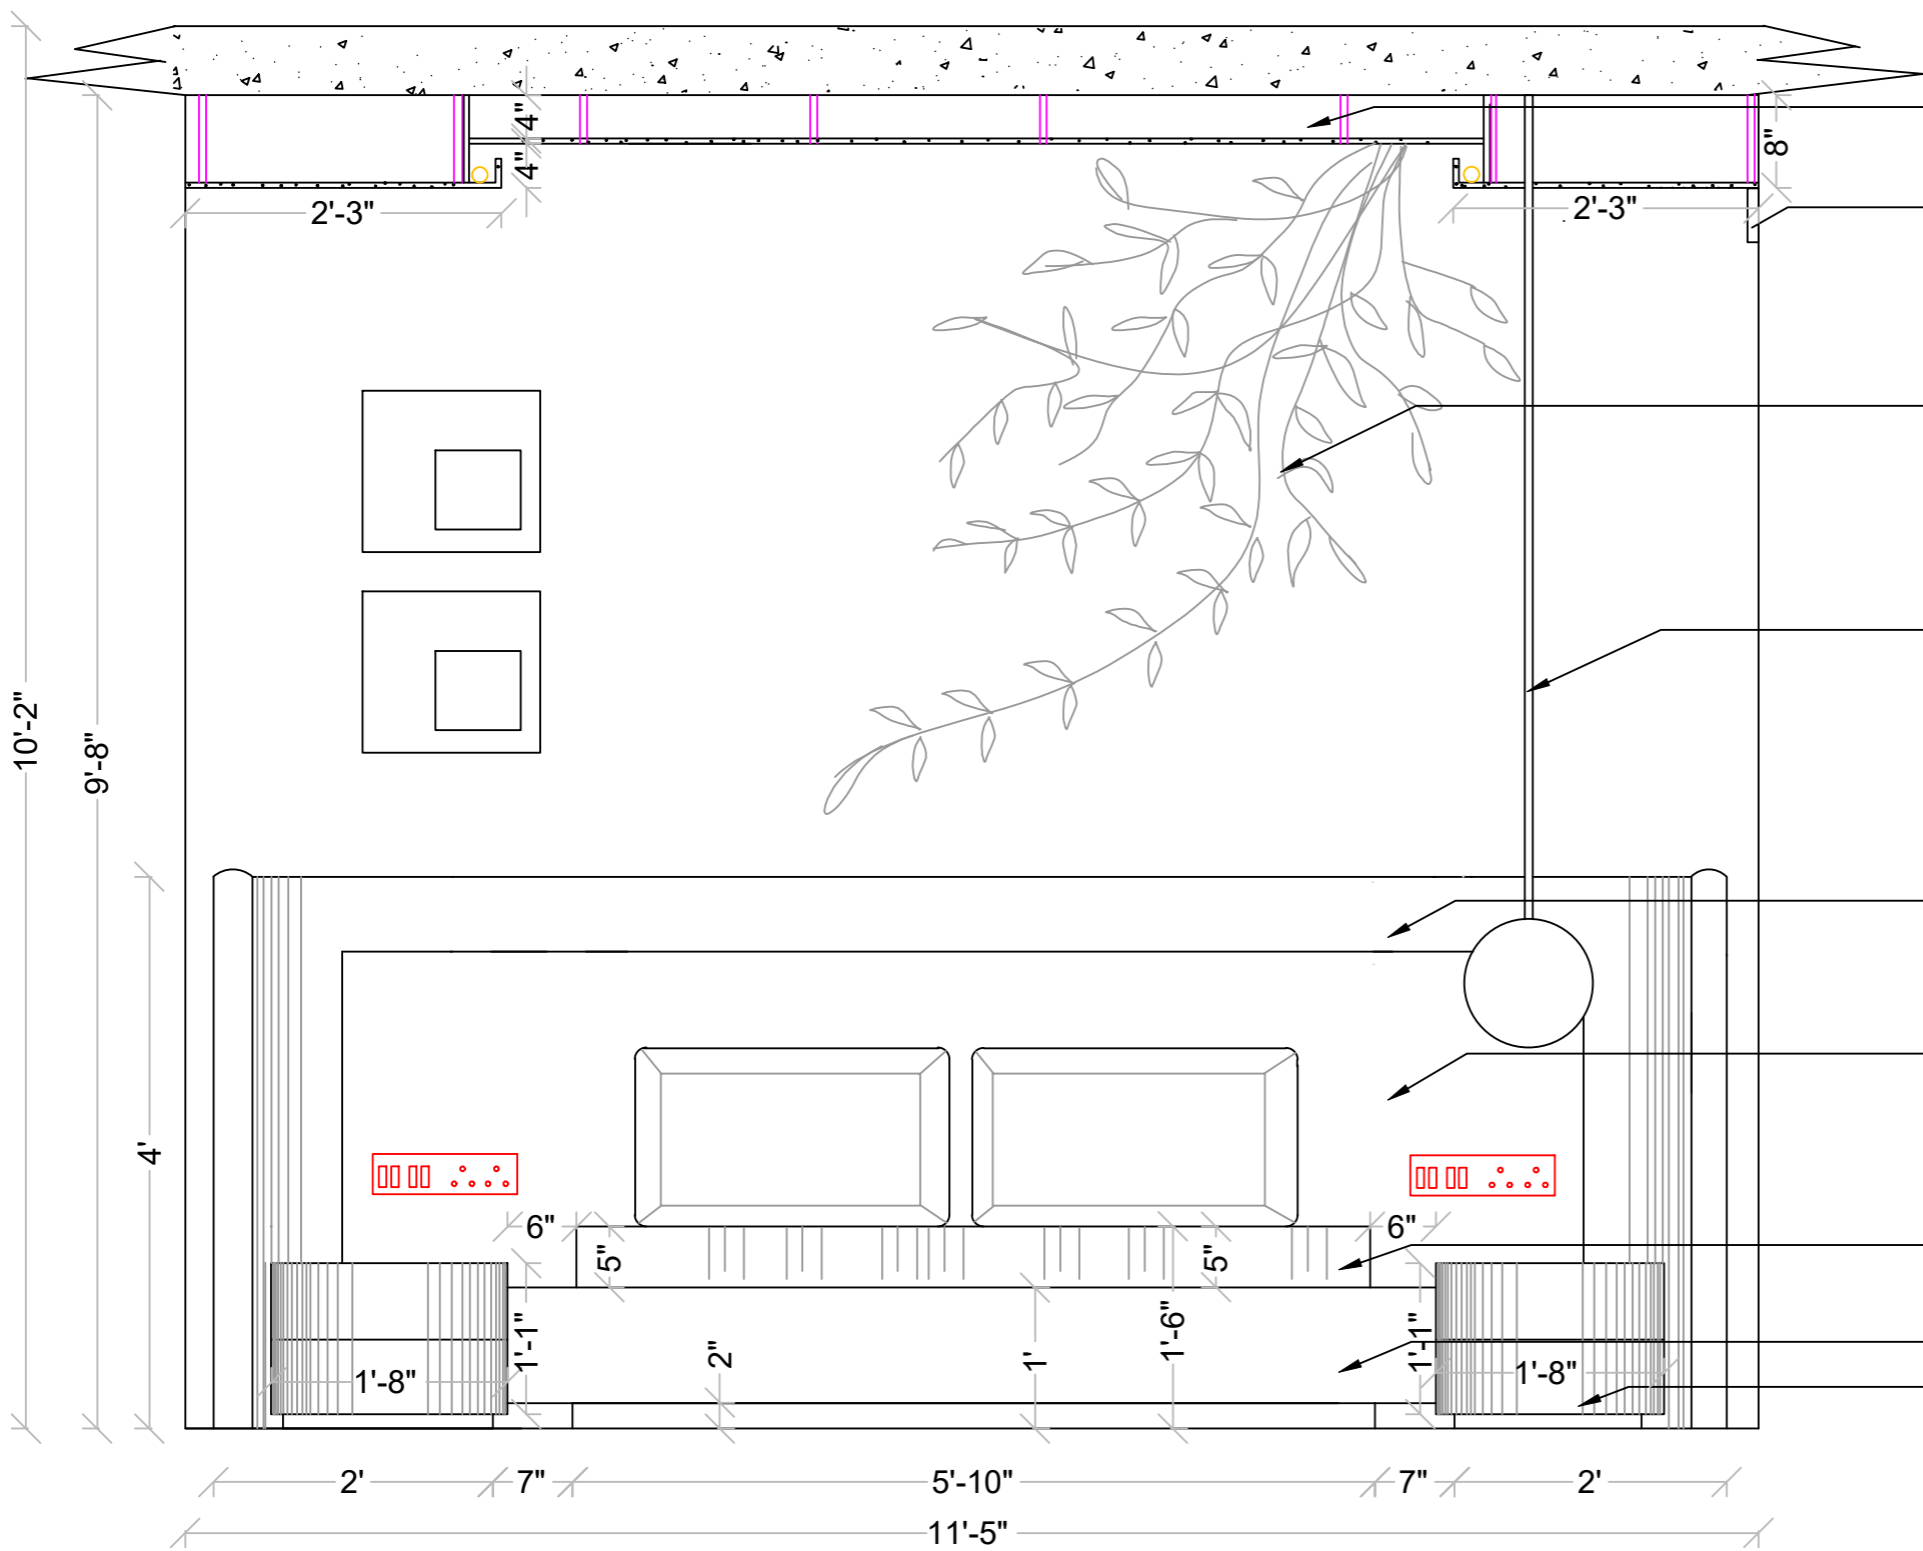

- Gyp ceiling
- AC grill
- True wall painted to off white / wall paper
- Pendant Light
- SW Headboard in natural polish
- Leather finished headboard, light colour
- Mattress
- Bed box in ply and veneer
- Bedside unit in veneer

10'-2"
9'-8"
4'

2' 7" 5'-10" 7" 2'
11'-5"

BEDSTEAD WALL, MBR

NOTES

1. THIS DRAWING IS THE PROPERTY OF **Builders and Designers (A Unit of MAESTER (R))**, AND SHALL NOT BE COPIED OR USED WITHOUT PRIOR PERMISSION.
2. THE DRAWING IS NOT TO THE SCALE. ONLY WRITTEN DIMENSION SHALL BE FOLLOWED.
3. ALL DIMENSIONS ARE IN MM.

TITLE

**Master Bedroom
Bedstead Wall**


SCALE: NTS

CLIENT:-
Tulsiyan Family

DATE OF ISSUE: 21.04.2026

REVISIONS SHEET A3

SN	REVISION NO	DATE
01	R0	21-04-2026
02		
03		

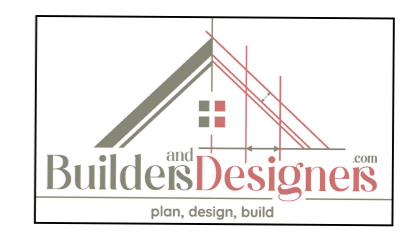


DESIGN BY TABREZ

DRAWN BY TAHER

CHECKED BY TABREZ

DRAWING NO RWSH-12

ALL DIMENSIONS ARE IN FT

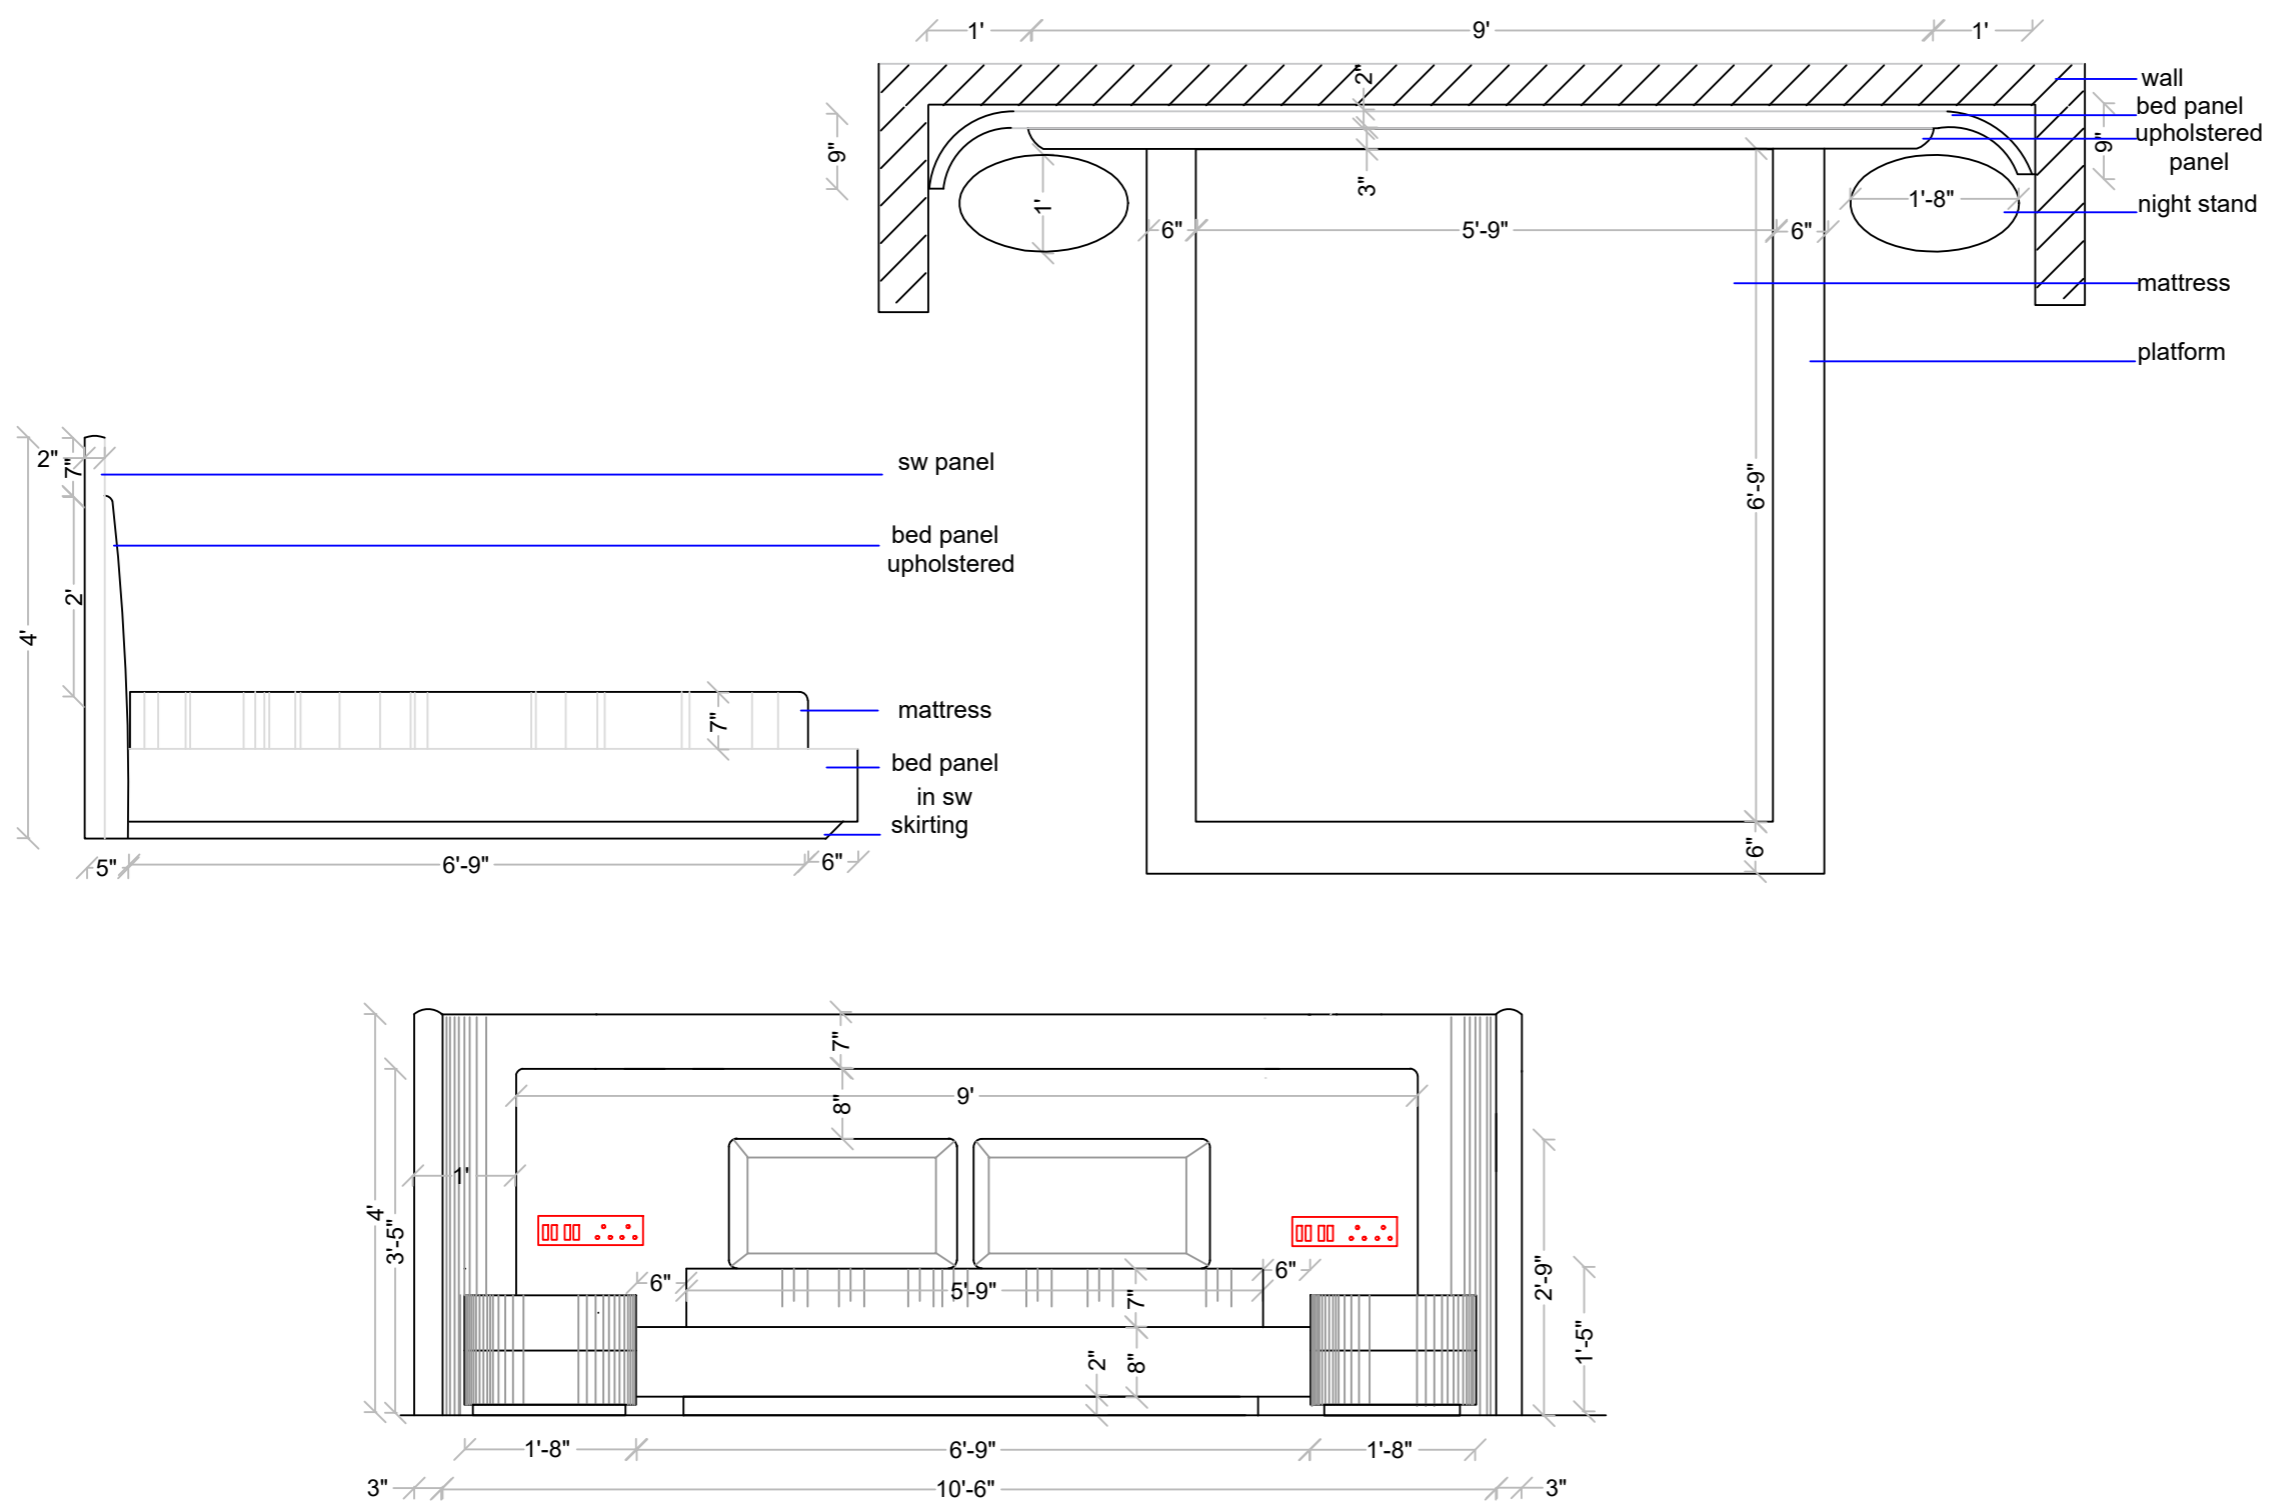

NOTES

1. THIS DRAWING IS THE PROPERTY OF **Builders and Designers (A Unit of MAESTER (R))**, AND SHALL NOT BE COPIED OR USED WITHOUT PRIOR PERMISSION.
2. THE DRAWING IS NOT TO THE SCALE. ONLY WRITTEN DIMENSION SHALL BE FOLLOWED.
3. ALL DIMENSIONS ARE IN MM.

TITLE

Master Bedroom layout plan

SCALE: NTS

CLIENT:-
Tulsiyan Family

DATE OF ISSUE: 21.04.2026

REVISIONS SHEET A3

SN	REVISION NO	DATE
01	R0	21-04-2026
02		
03		



DESIGN BY TABREZ


DRAWN BY TAHER

CHECKED BY TABREZ



DRAWING NO RWSH-12

A B C D E F G H I J

1
2
3
4
5
6
7

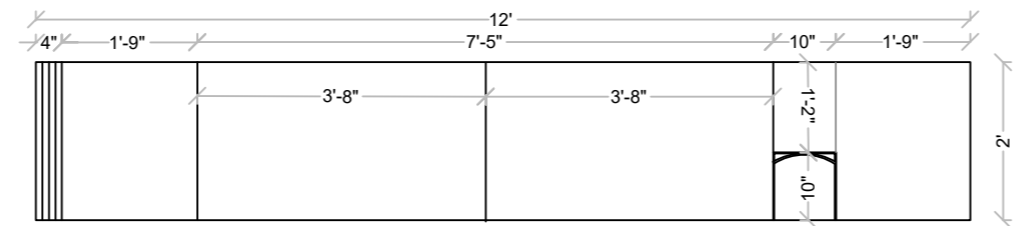

PLAN

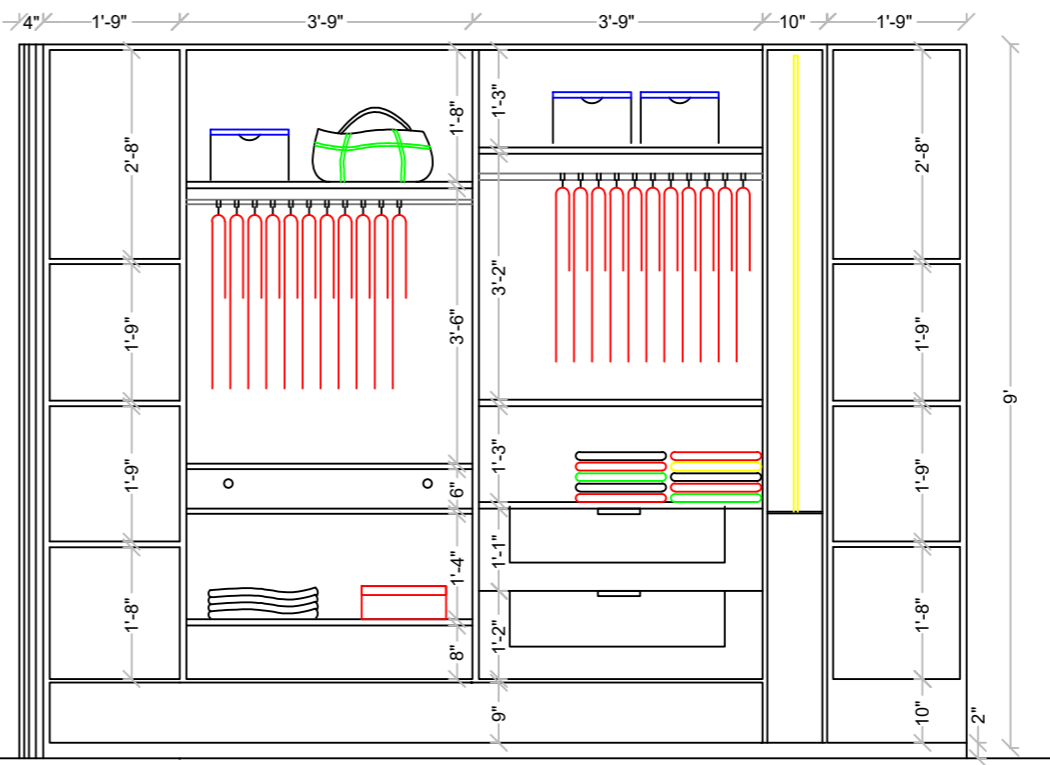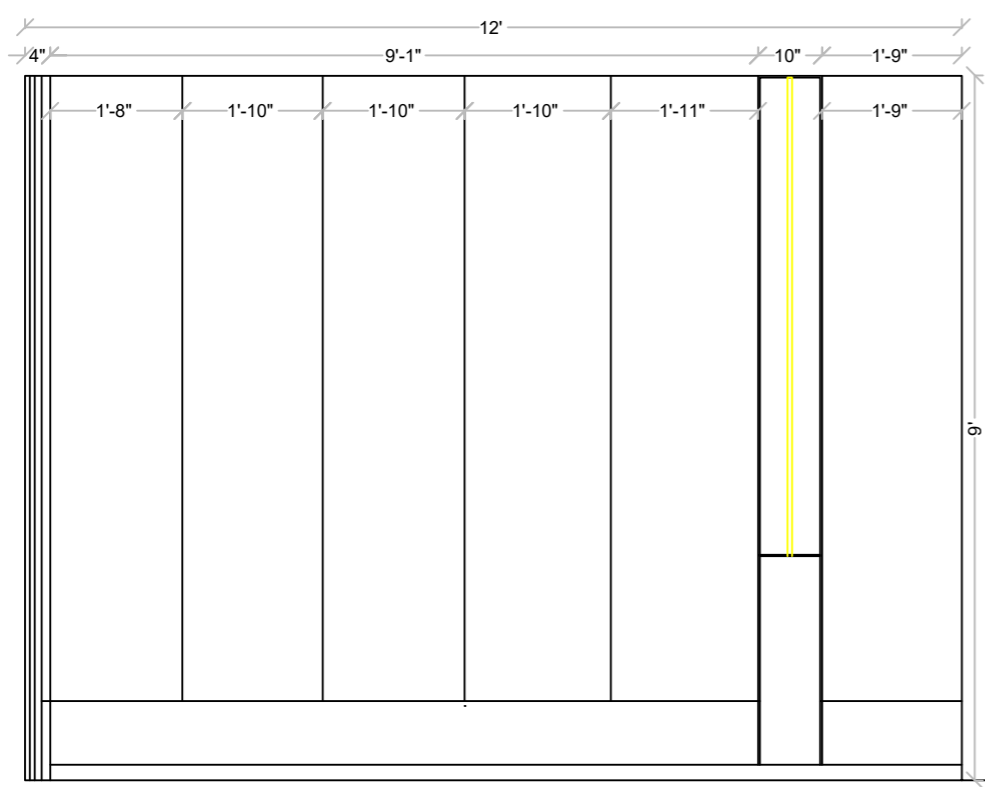

ELEVATIONS

MASTER BEDROOM WARDROBE

NOTES


1. THIS DRAWING IS THE PROPERTY OF **Builders and Designers (A Unit of MAESTER (R))**, AND SHALL NOT BE COPIED OR USED WITHOUT PRIOR PERMISSION.
2. THE DRAWING IS NOT TO THE SCALE. ONLY WRITTEN DIMENSION SHALL BE FOLLOWED.
3. ALL DIMENSIONS ARE IN MM.

TITLE

Master Bed Room Wardrobe

SCALE: NTS


CLIENT:-
Tulsiyan Family

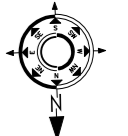

DATE OF ISSUE: 21.04.2026

REVISIONS SHEET A3


SN	REVISION NO	DATE
01	R0	21-04-2026
02		
03		

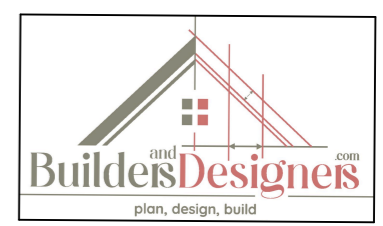


DESIGN BY	TABREZ
DRAWN BY	TAHER
CHECKED BY	TABREZ
DRAWING NO	RWSH-12

ALL DIMENSIONS ARE IN FT

1
2
3
4
5
6
7

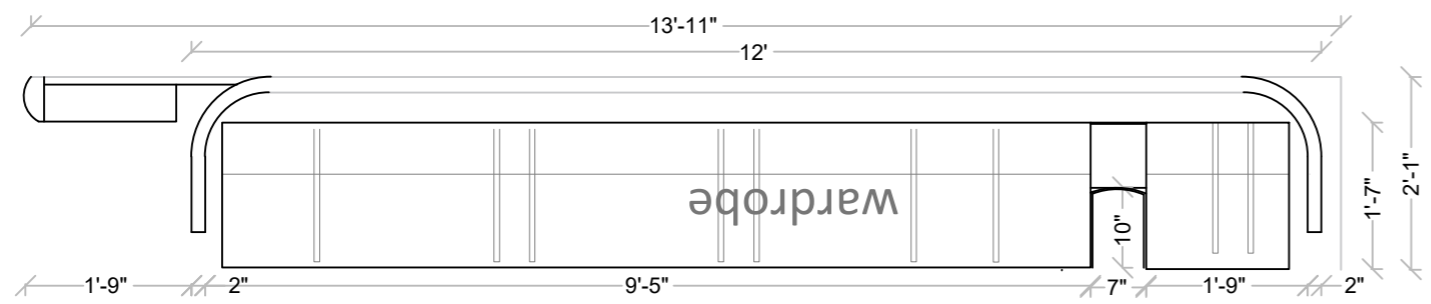

PLAN

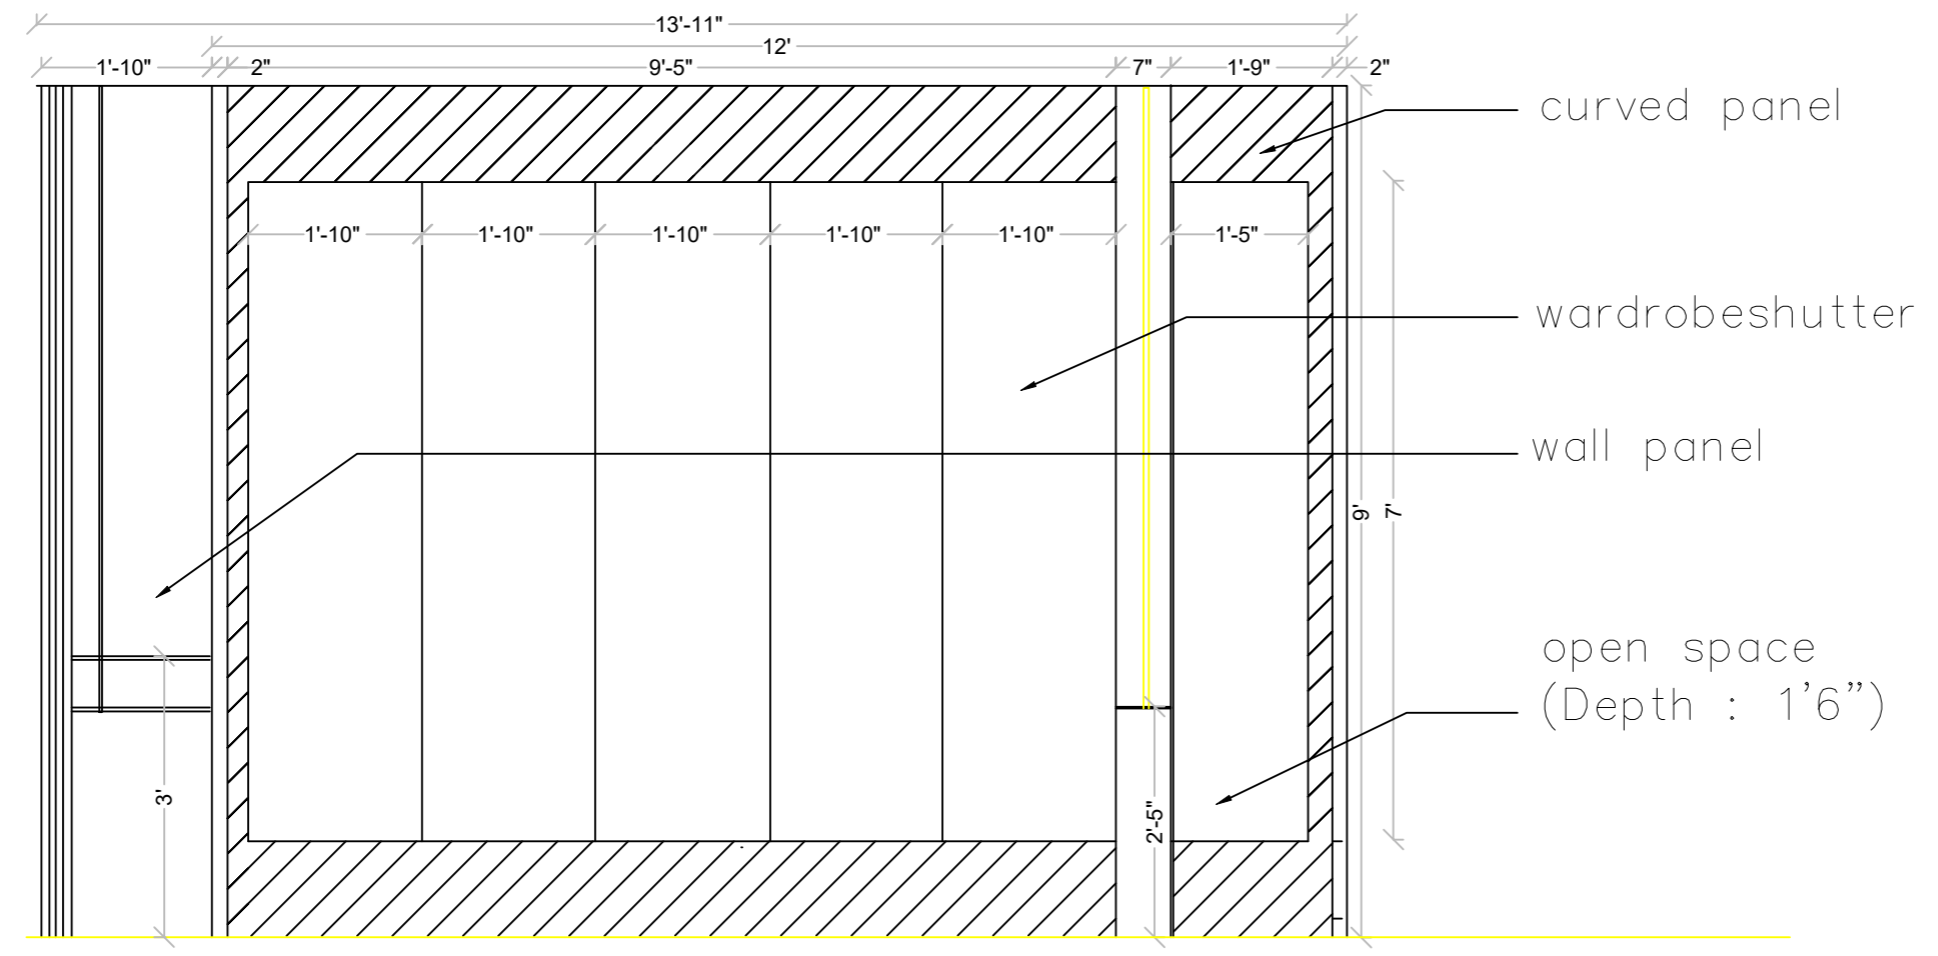

MASTER BEDROOM WARDROBE

NOTES


1. THIS DRAWING IS THE PROPERTY OF **Builders and Designers (A Unit of MAESTER (R))**, AND SHALL NOT BE COPIED OR USED WITHOUT PRIOR PERMISSION.
2. THE DRAWING IS NOT TO THE SCALE. ONLY WRITTEN DIMENSION SHALL BE FOLLOWED.
3. ALL DIMENSIONS ARE IN MM.

TITLE

Master Bed Room Wardrobe

SCALE: NTS


CLIENT:-
Tulsiyan Family

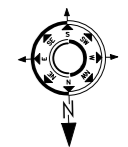

DATE OF ISSUE: 21.04.2026

REVISIONS SHEET A3

SN	REVISION NO	DATE
01	R0	21-04-2026
02		
03		

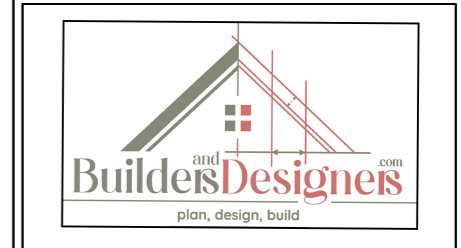


DESIGN BY TABREZ

DRAWN BY TAHER

CHECKED BY TABREZ

DRAWING NO RWSH-12

MBR STUDY

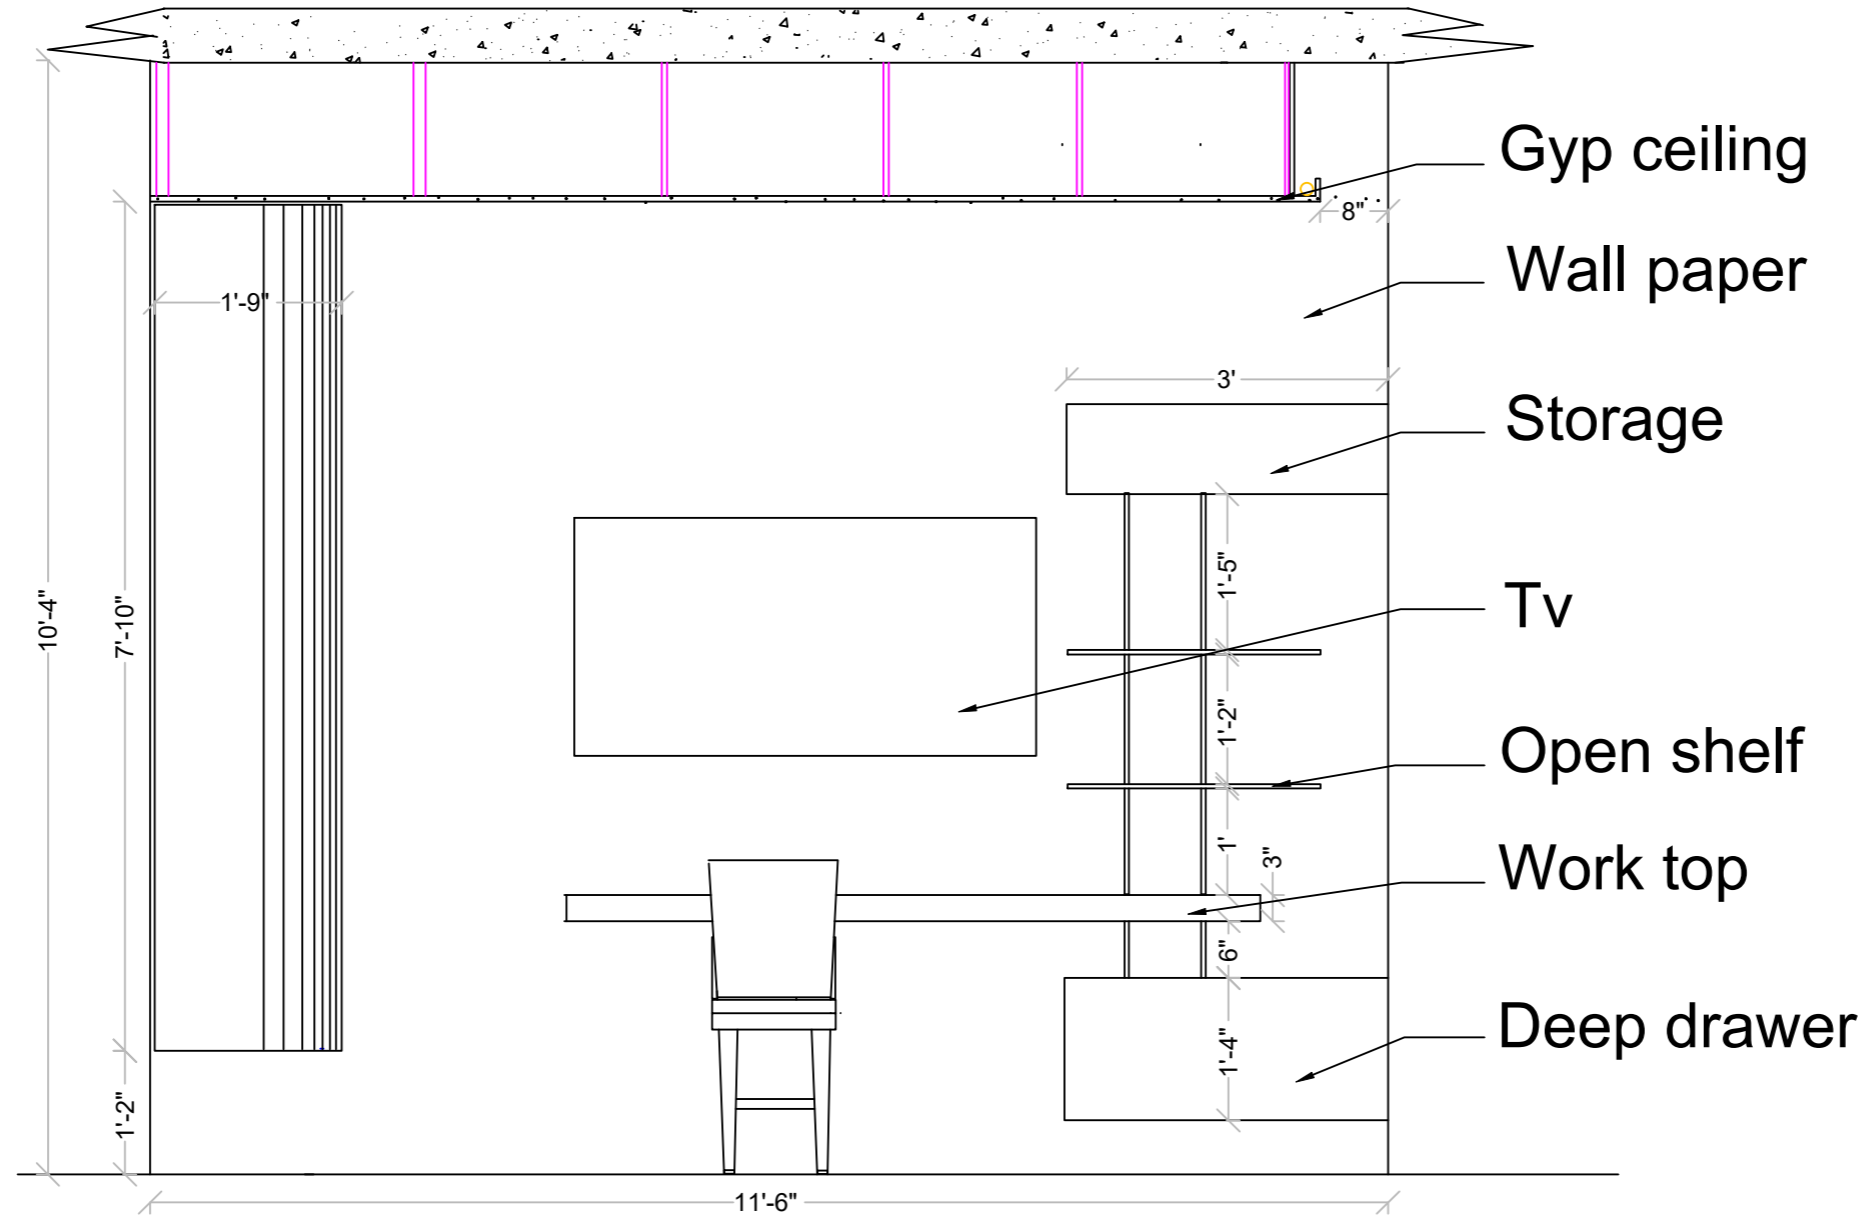

NOTES

 
1. THIS DRAWING IS THE PROPERTY OF **Builders and Designers (A Unit of MAESTER (R))**, AND SHELL NOT BE COPIED OR USED WITHOUT PRIOR PERMISSION.
2. THE DRAWING IS NOT TO THE SCALE. ONLY WRITTEN DIMENSION SHALL BE FOLLOWED.
3. ALL DIMENSIONS ARE IN MM.

TITLE

Master Bedroom
Study Table

SCALE: NTS

CLIENT:-
Tulsiyan Family




DATE OF ISSUE: 21.04.2026

REVISIONS

SHEET
A3

SN	REVISION NO	DATE
01	R0	21-04-2026
02		
03		

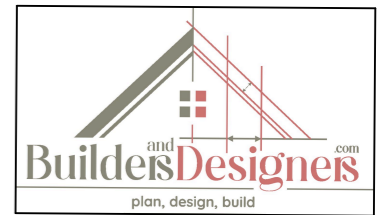


DESIGN BY TABREZ

DRAWN BY TAHER

CHECKED BY TABREZ

DRAWING NO RWSH-12

ALL DIMENSIONS ARE IN FT

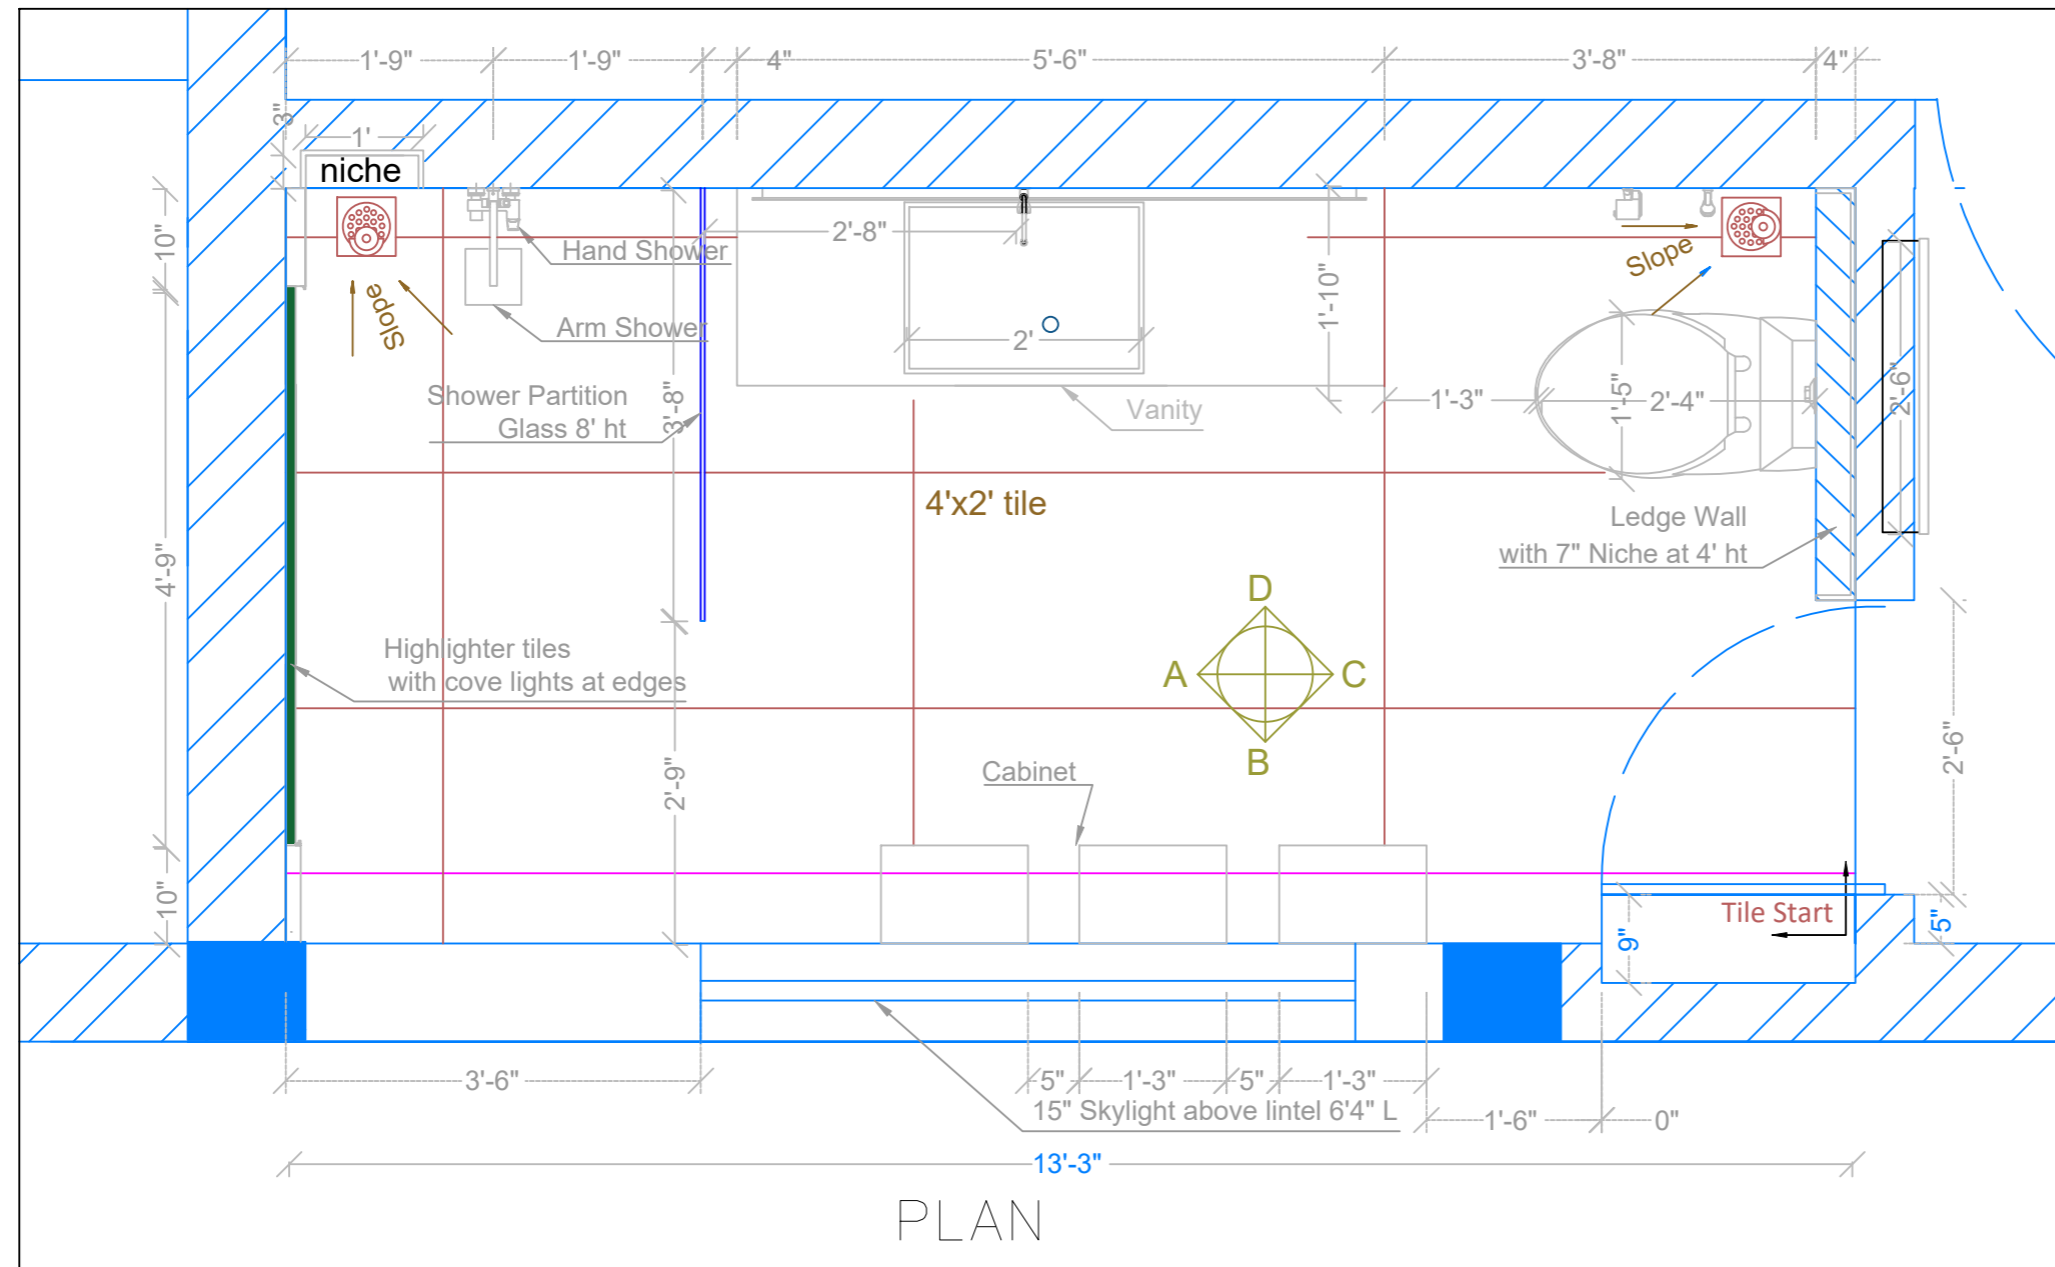

MBR TOILET PLAN

NOTES

1. THIS DRAWING IS THE PROPERTY OF **Builders and Designers (A Unit of MAESTER (R))**, AND SHALL NOT BE COPIED OR USED WITHOUT PRIOR PERMISSION.
2. THE DRAWING IS NOT TO THE SCALE. ONLY WRITTEN DIMENSION SHALL BE FOLLOWED.
3. ALL DIMENSIONS ARE IN MM.

 
TITLE

**Master Bedroom
TOILET Plan**

SCALE: NTS

CLIENT:-

Tulsiyan Family



DATE OF ISSUE: 21.04.2026

REVISIONS

SHEET
A3

SN	REVISION NO	DATE
01	R0	21-04-2026
02		
03		




DESIGN BY TABREZ

DRAWN BY TAHER

CHECKED BY TABREZ

DRAWING NO RWSH-12

ALL DIMENSIONS ARE IN FT

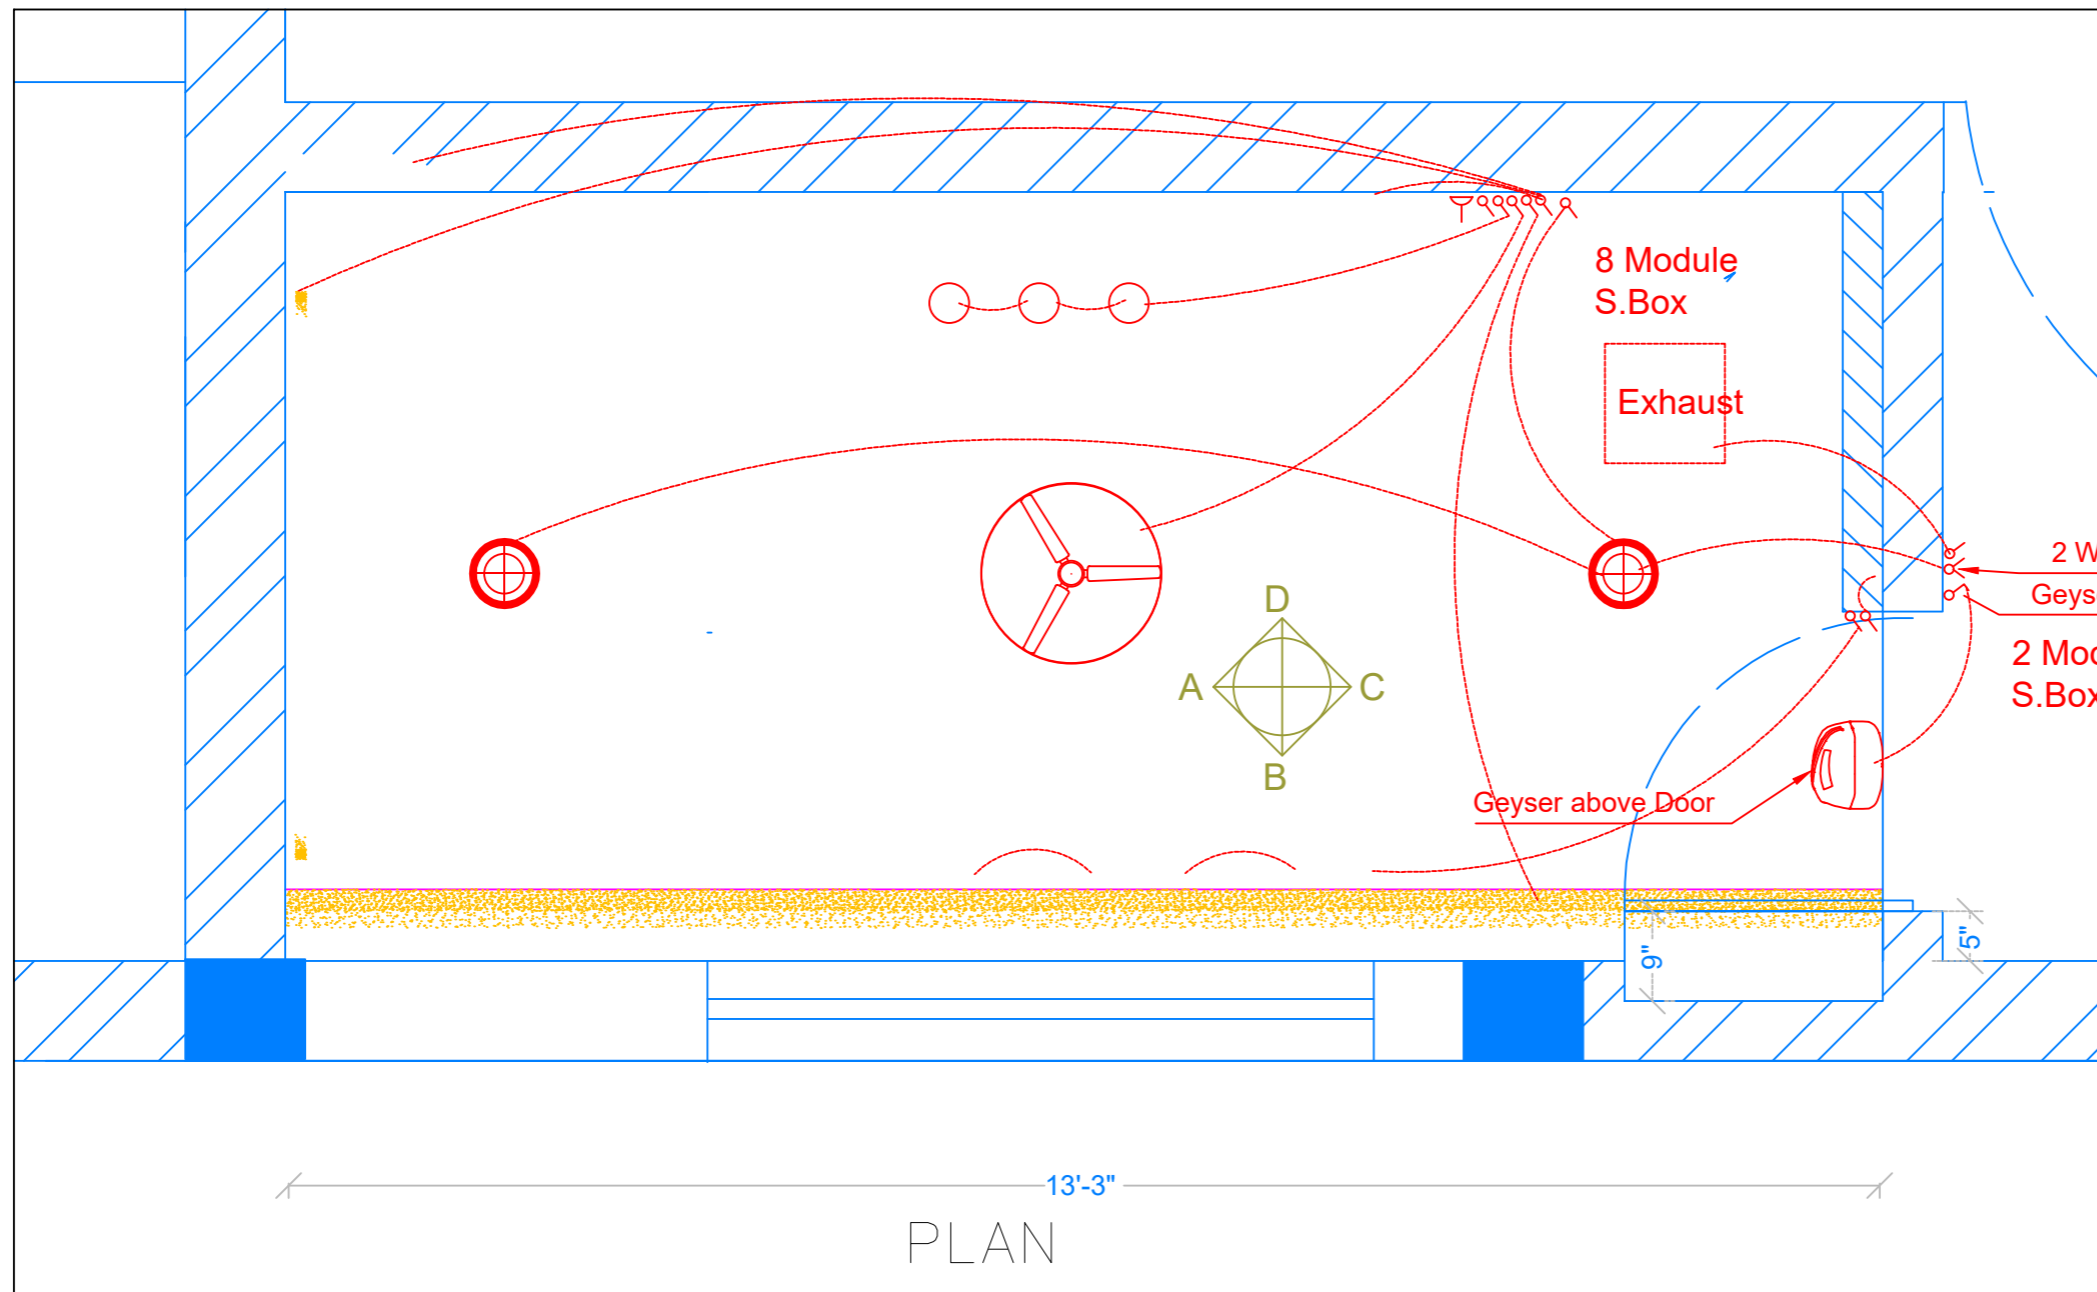

MBR TOILET


13'-3"
PLAN

- NOTES**
1. THIS DRAWING IS THE PROPERTY OF **Builders and Designers (A Unit of MAESTER (R))**, AND SHALL NOT BE COPIED OR USED WITHOUT PRIOR PERMISSION.
 2. THE DRAWING IS NOT TO THE SCALE. ONLY WRITTEN DIMENSION SHALL BE FOLLOWED.
 3. ALL DIMENSIONS ARE IN MM.

TITLE

Master Bedroom Toilet
Electrical Layout


SCALE: NTS
CLIENT:-
Tulsiyan Family

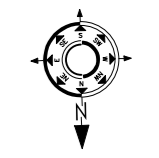

DATE OF ISSUE: 21.04.2026

REVISIONS SHEET A3





SN	REVISION NO	DATE
01	R0	21-04-2026
02		
03		

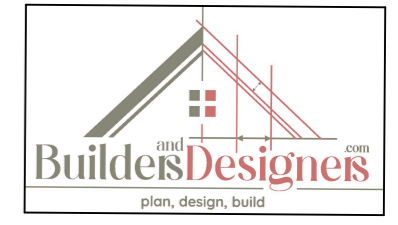

DESIGN BY TABREZ
DRAWN BY TAHER
CHECKED BY TABREZ
DRAWING NO RWSH-12

ALL DIMENSIONS ARE IN FT

MBR Toilet Elevations

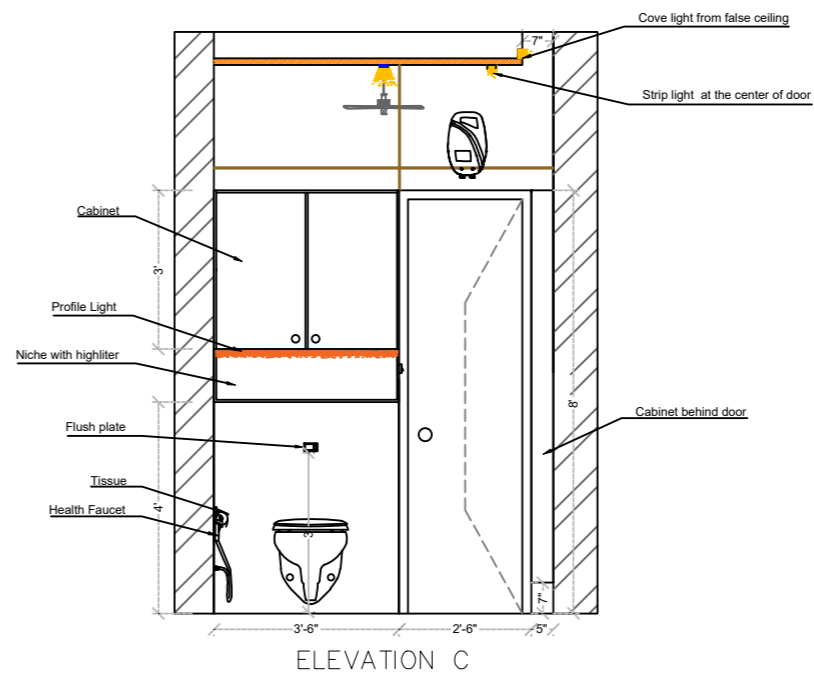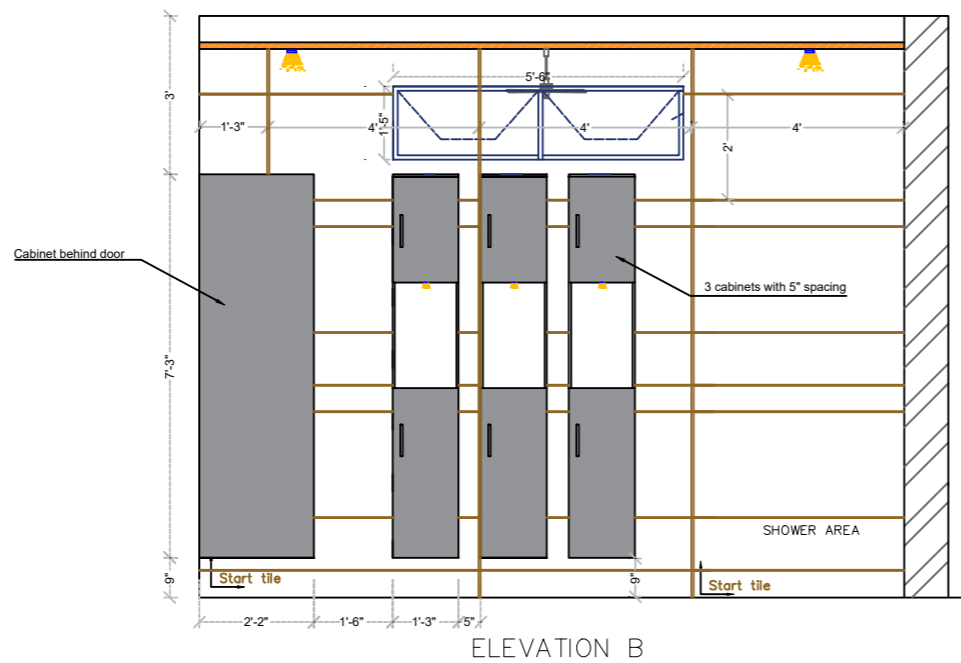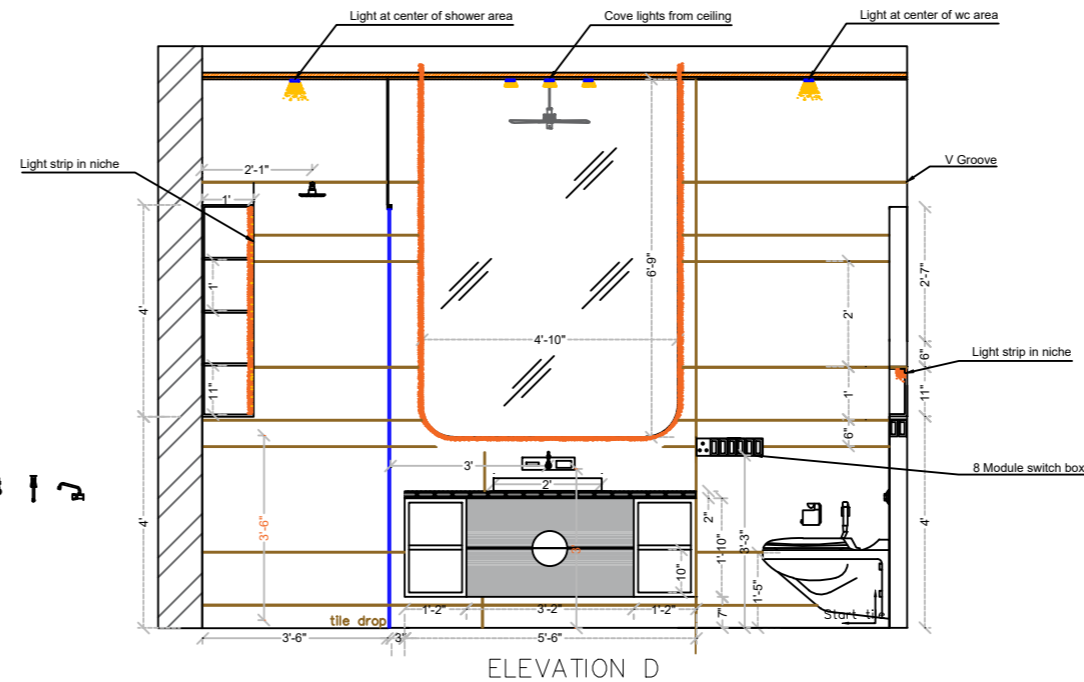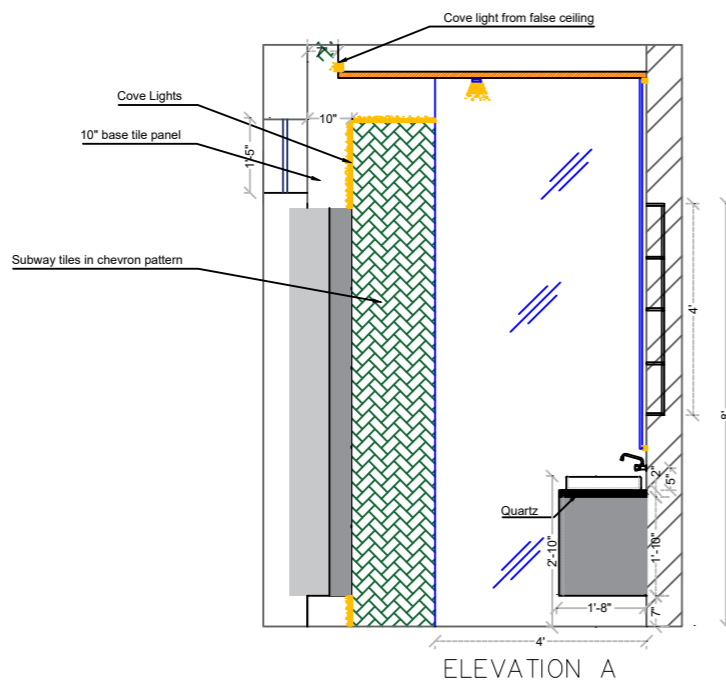

NOTES

 
1. THIS DRAWING IS THE PROPERTY OF **Builders and Designers (A Unit of MAESTER (R))**, AND SHELL NOT BE COPIED OR USED WITHOUT PRIOR PERMISSION.
2. THE DRAWING IS NOT TO THE SCALE. ONLY WRITTEN DIMENSION SHALL BE FOLLOWED.
3. ALL DIMENSIONS ARE IN MM.

TITLE

MBR Toilet Elevations

SCALE: NTS

CLIENT:-
Tulsiyan Family



DATE OF ISSUE: 21.04.2026

REVISIONS

SN	REVISION NO	DATE
01	R0	21-04-2026
02		
03		



DESIGN BY TABREZ



DRAWN BY TAHER

CHECKED BY TABREZ

DRAWING NO RWSH-12

ALL DIMENSIONS ARE IN FT

MBR TOILET CABINET

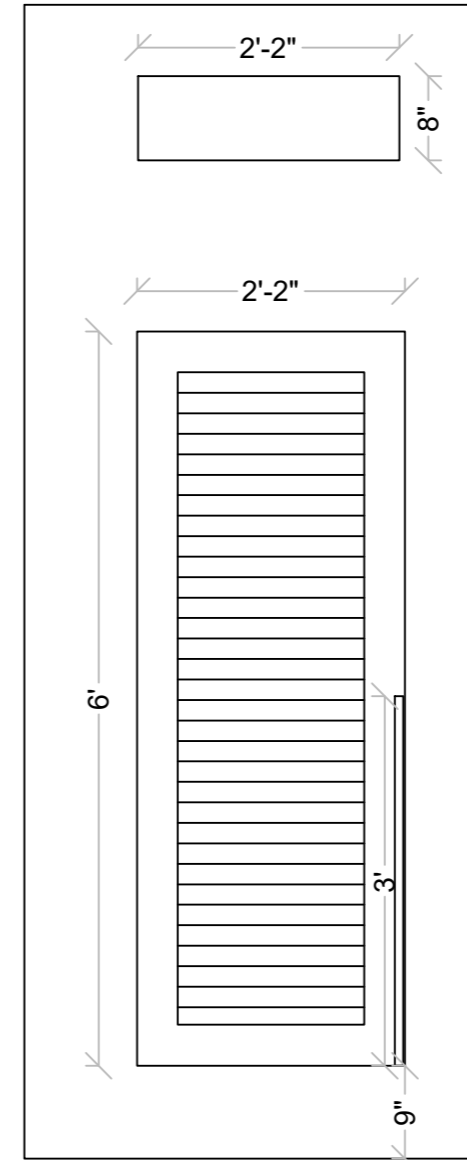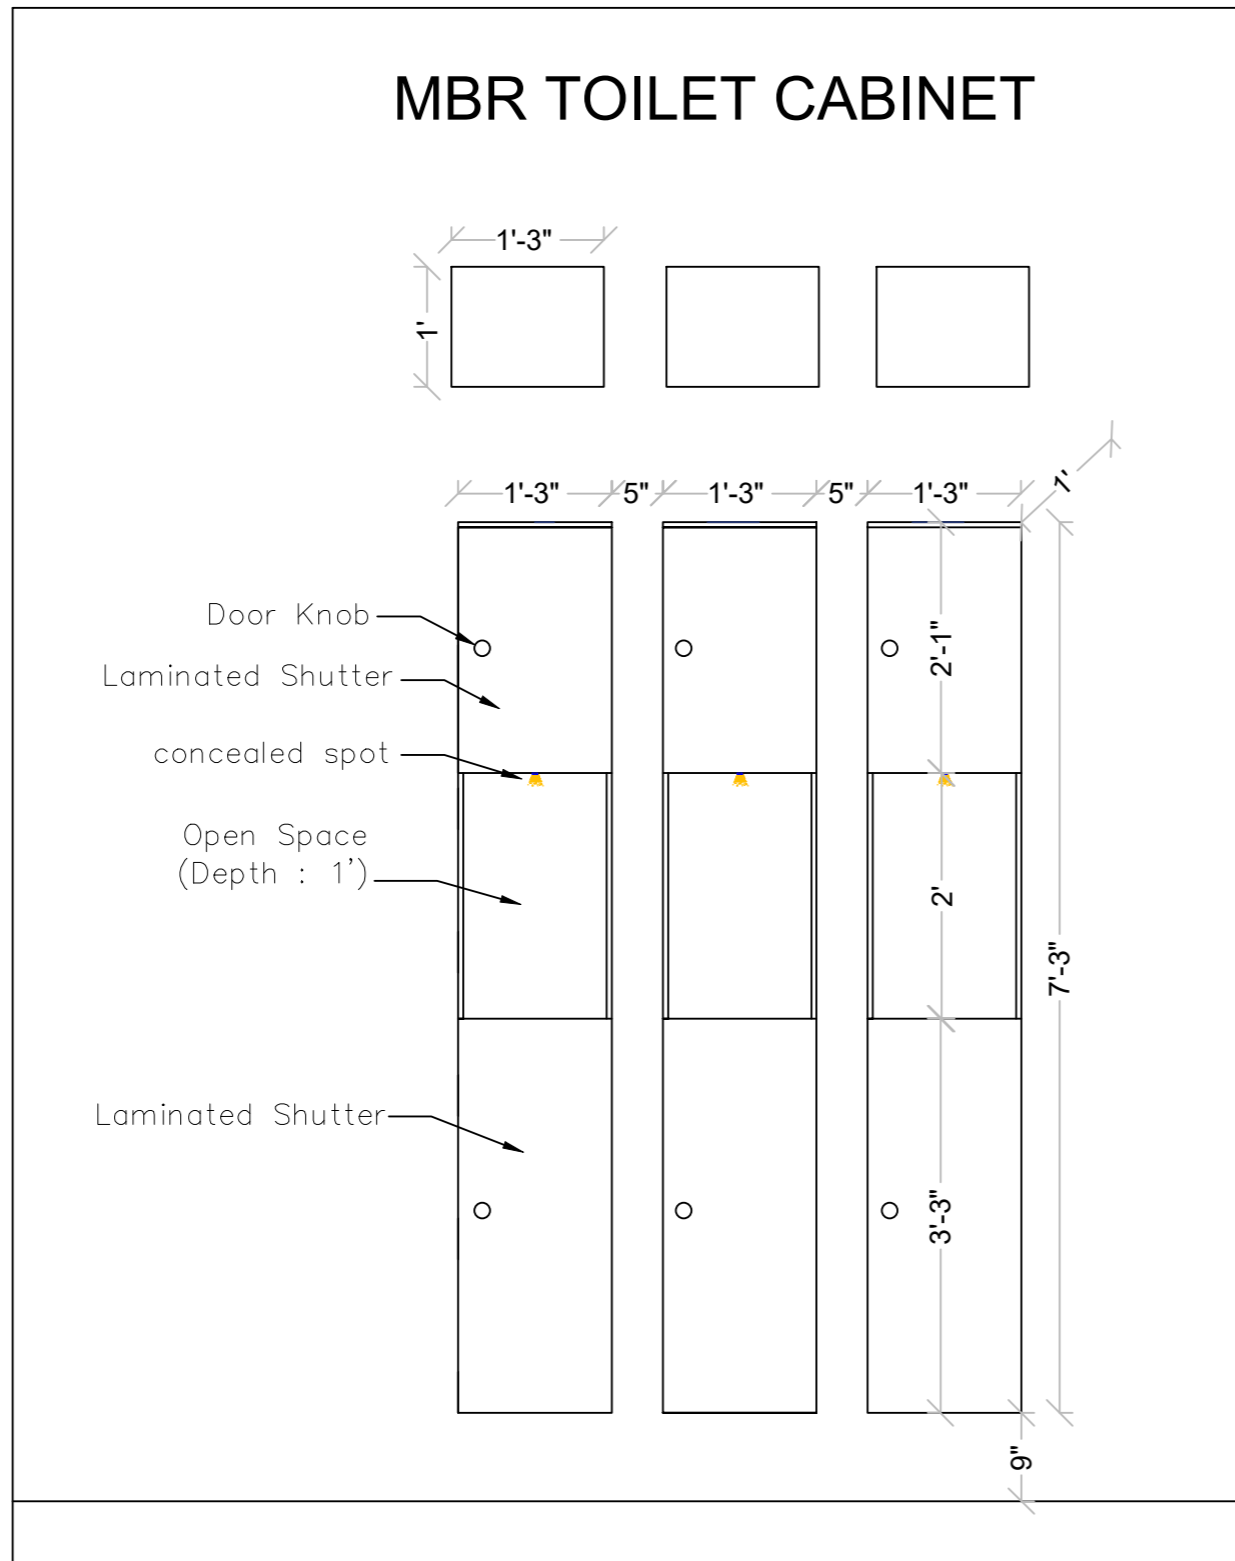

NOTES

 
1. THIS DRAWING IS THE PROPERTY OF **Builders and Designers (A Unit of MAESTER (R))**, AND SHALL NOT BE COPIED OR USED WITHOUT PRIOR PERMISSION.
2. THE DRAWING IS NOT TO THE SCALE. ONLY WRITTEN DIMENSION SHALL BE FOLLOWED.
3. ALL DIMENSIONS ARE IN MM.

TITLE

Master Bedroom Toilet Cabinate

SCALE: NTS

CLIENT:-
Tulsiyan Family



DATE OF ISSUE: 21.04.2026

REVISIONS

SHEET
A3

SN	REVISION NO	DATE
01	R0	21-04-2026
02		
03		




DESIGN BY TABREZ
 DRAWN BY TAHER
 CHECKED BY TABREZ
 DRAWING NO RWSH-12


ALL DIMENSIONS ARE IN FT

MBR TOILET VANITY

drawer plan

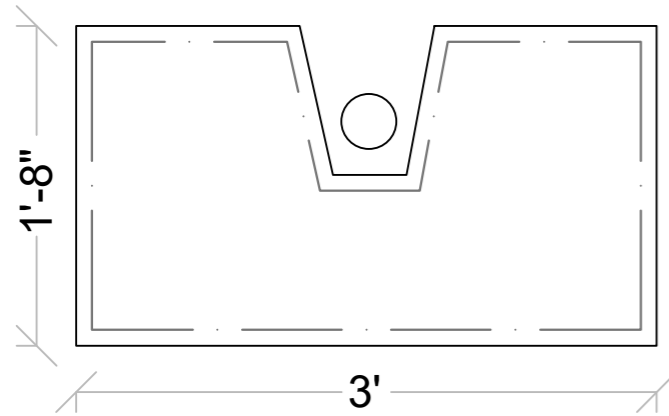

PLAN


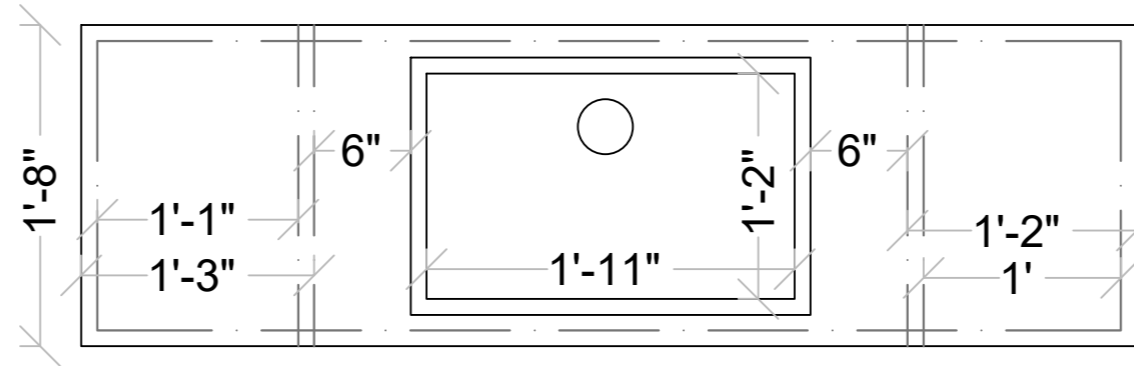


WASH BASIN

CORIAN

OPEN SPACE
in wood finish laminatel

 DRAWERS
in wood finish reeedlaminatel

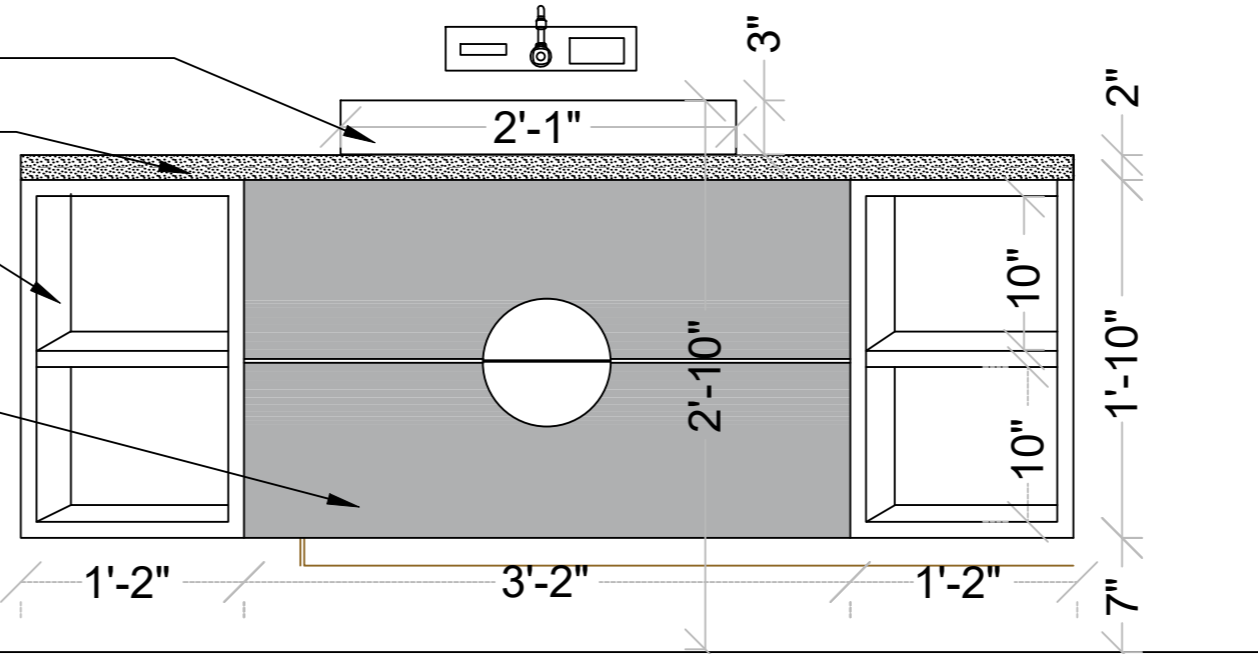

ELEVATION

NOTES

 
1. THIS DRAWING IS THE PROPERTY OF **Builders and Designers (A Unit of MAESTER (R))**, AND SHELL NOT BE COPIED OR USED WITHOUT PRIOR PERMISSION.
2. THE DRAWING IS NOT TO THE SCALE. ONLY WRITTEN DIMENSION SHALL BE FOLLOWED.
3. ALL DIMENSIONS ARE IN MM.

TITLE

Master Bedroom
Toilet Vanity

SCALE: NTS

CLIENT:-
Tulsiyan Family



DATE OF ISSUE: 21.04.2026

REVISIONS

SN	REVISION NO	DATE
01	R0	21-04-2026
02		
03		





DESIGN BY TABREZ

DRAWN BY TAHER

CHECKED BY TABREZ

DRAWING NO RWSH-12

ALL DIMENSIONS ARE IN FT

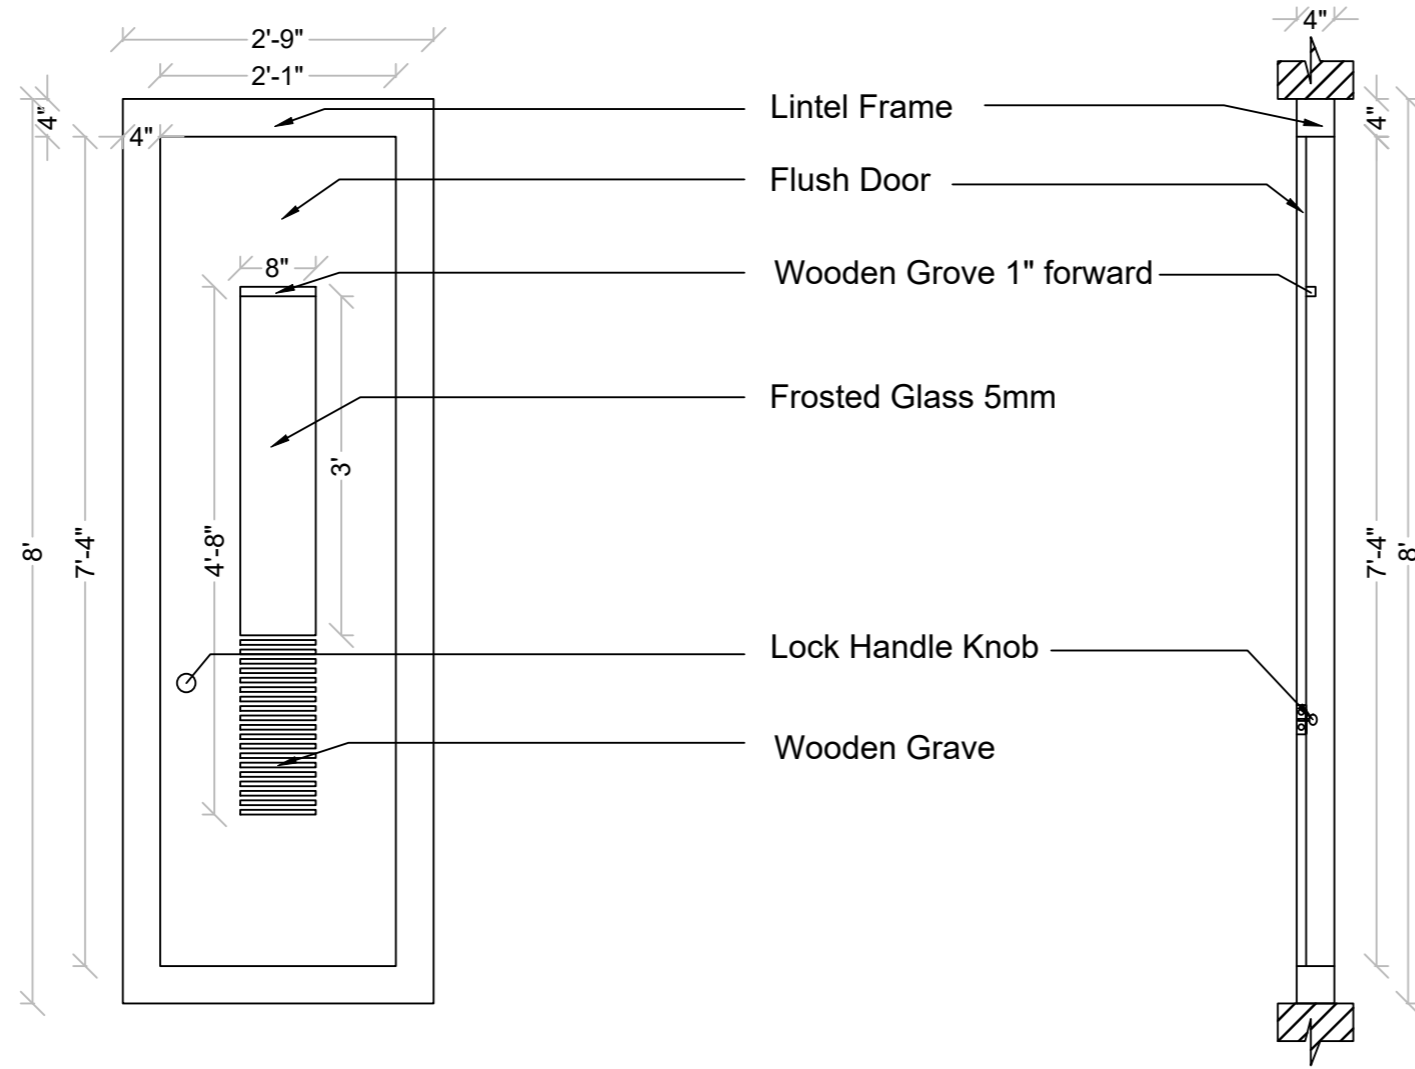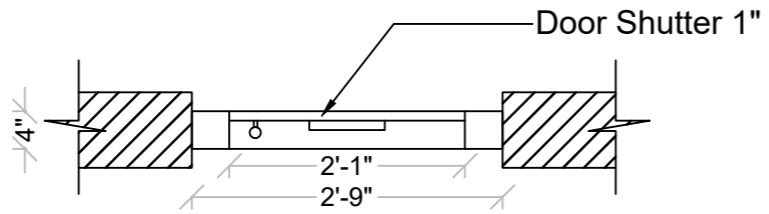

Toilet Door


NOTES

1. THIS DRAWING IS THE PROPERTY OF **Builders and Designers (A Unit of MAESTER (R))**, AND SHELL NOT BE COPIED OR USED WITHOUT PRIOR PERMISSION.
2. THE DRAWING IS NOT TO THE SCALE. ONLY WRITTEN DIMENSION SHALL BE FOLLOWED.
3. ALL DIMENSIONS ARE IN MM.

TITLE

Toilet Door

SCALE: NTS
 CLIENT:-
 Tulsian Family

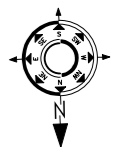

DATE OF ISSUE: 21.04.2026


REVISIONS SHEET A3

SN	REVISION NO	DATE
01	R0	21-04-2026
02		
03		





DESIGN BY TABREZ
 DRAWN BY TAHER
 CHECKED BY TABREZ
 DRAWING NO RWSH-12

ALL DIMENSIONS ARE IN FT

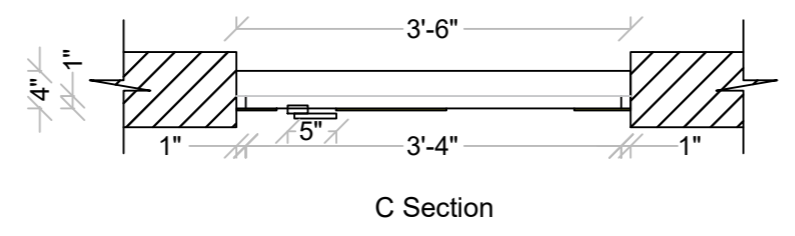

Wooden Patch work on door Shutter

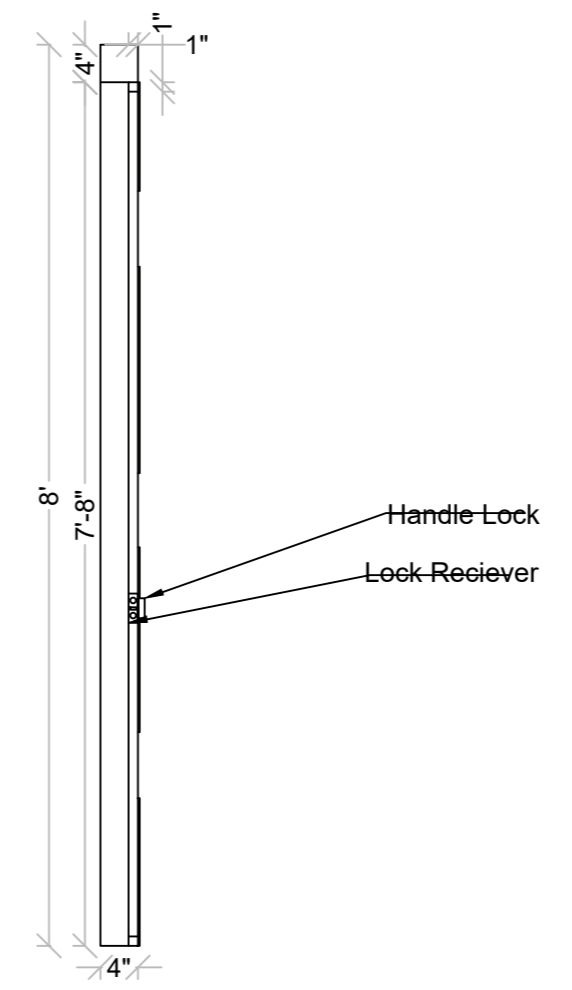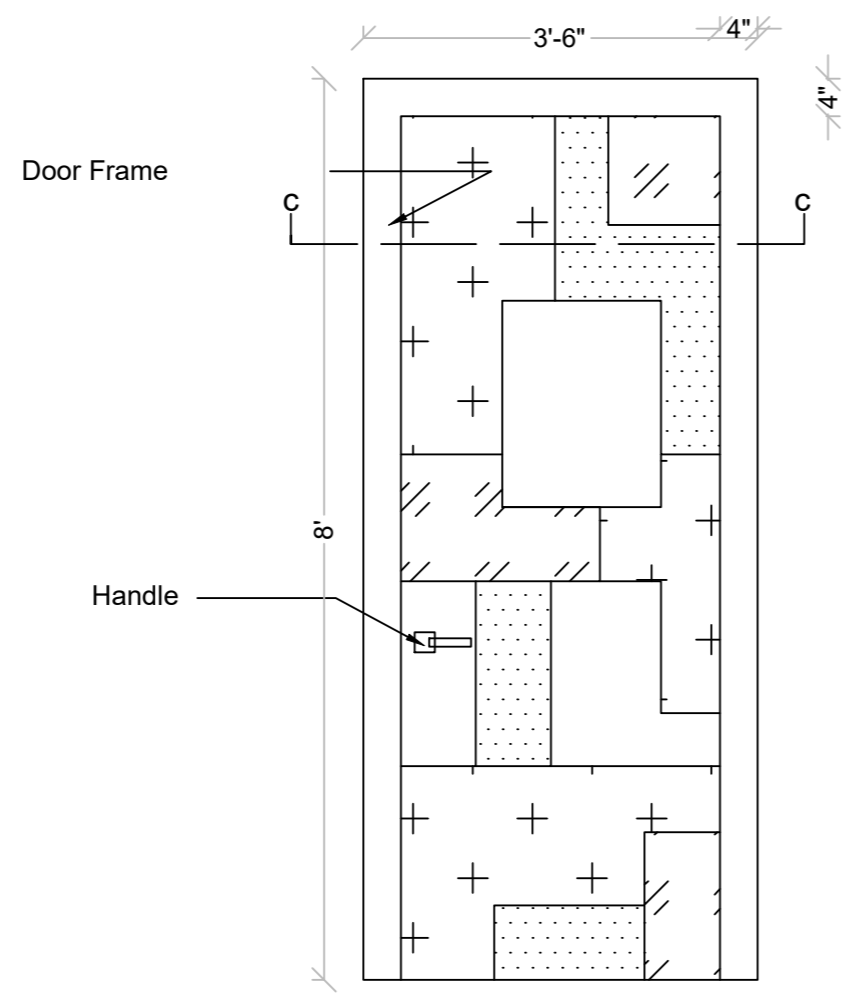

NOTES


1. THIS DRAWING IS THE PROPERTY OF **Builders and Designers (A Unit of MAESTER (R))**, AND SHELL NOT BE COPIED OR USED WITHOUT PRIOR PERMISSION.
2. THE DRAWING IS NOT TO THE SCALE. ONLY WRITTEN DIMENSION SHALL BE FOLLOWED.
3. ALL DIMENSIONS ARE IN MM.

TITLE

Toilet Door Frame

SCALE: NTS

CLIENT:-
Tulsiyan Family

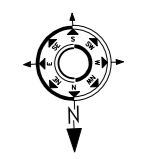

DATE OF ISSUE: 21.04.2026

REVISIONS SHEET A3

SN	REVISION NO	DATE
01	R0	21-04-2026
02		
03		




DESIGN BY TABREZ

DRAWN BY TAHER

CHECKED BY TABREZ

DRAWING NO RWSH-12

ALL DIMENSIONS ARE IN FT

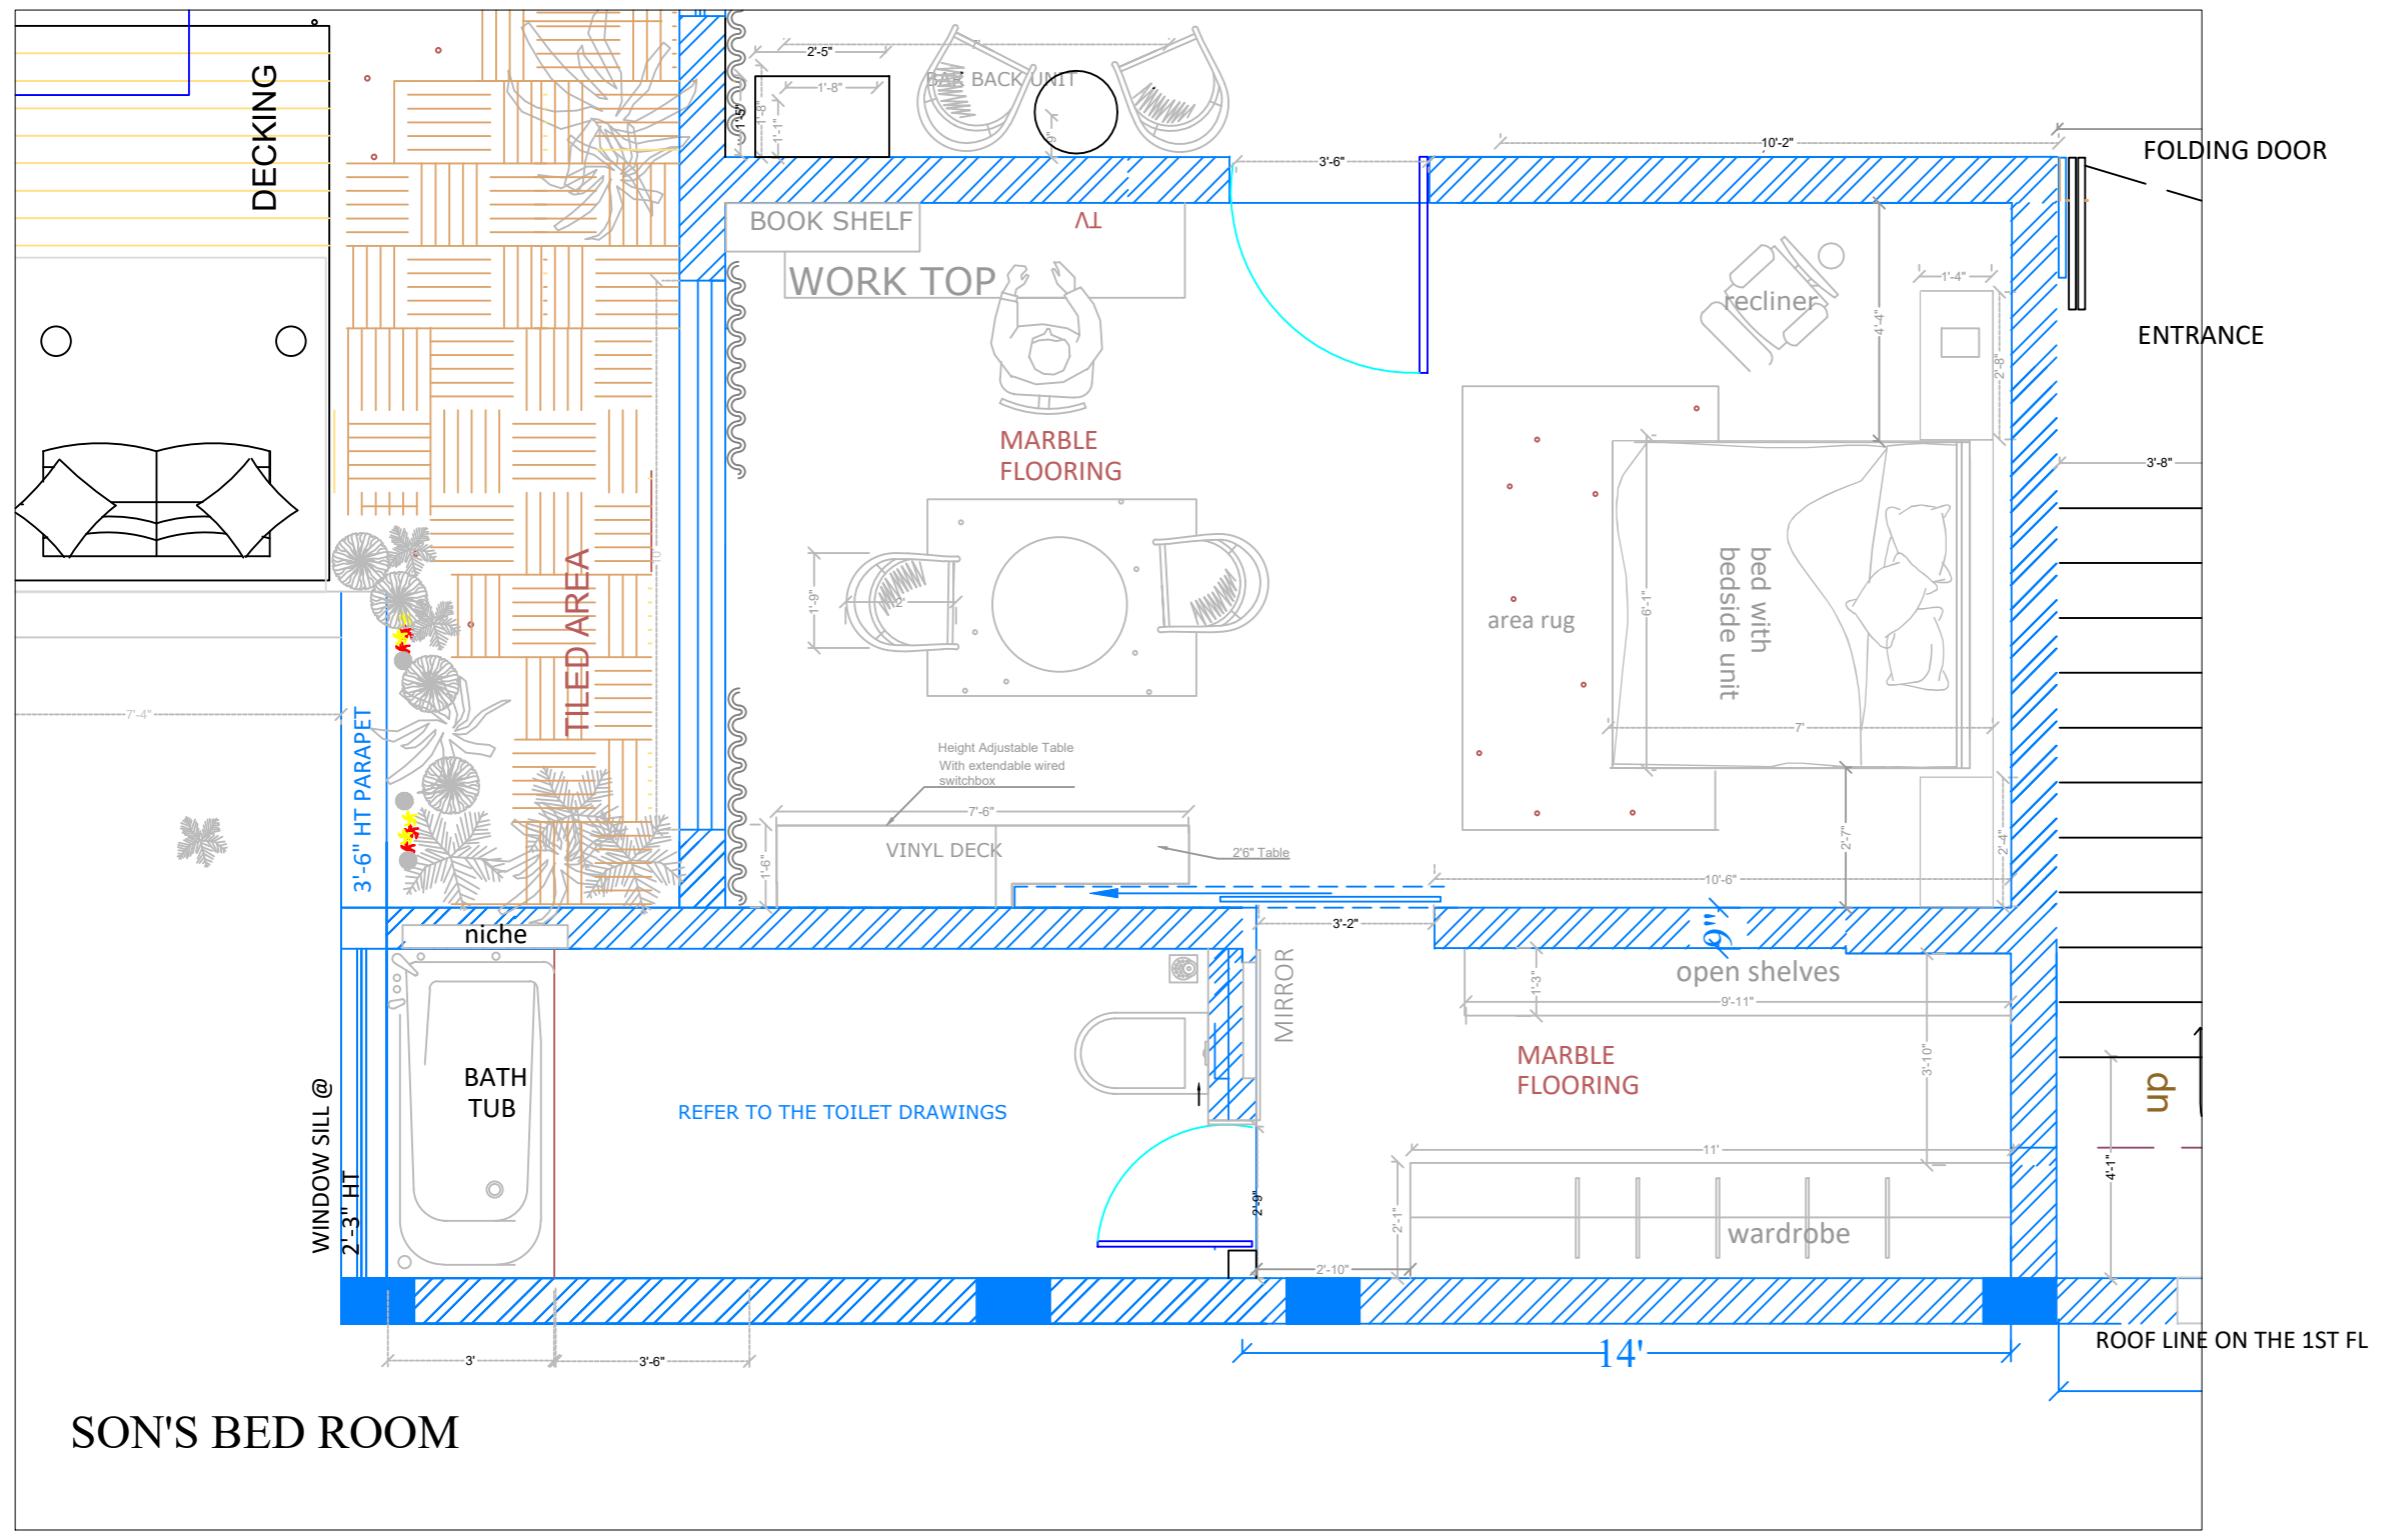

NOTES

1. THIS DRAWING IS THE PROPERTY OF **Builders and Designers (A Unit of MAESTER (R))**, AND SHALL NOT BE COPIED OR USED WITHOUT PRIOR PERMISSION.
2. THE DRAWING IS NOT TO THE SCALE. ONLY WRITTEN DIMENSION SHALL BE FOLLOWED.
3. ALL DIMENSIONS ARE IN MM.

TITLE

SON'S BED ROOM Plan


SCALE: NTS

CLIENT:- Tulsian Family

DATE OF ISSUE: 21.04.2026

REVISIONS SHEET A3

SN	REVISION NO	DATE
01	R0	21-04-2026
02		
03		

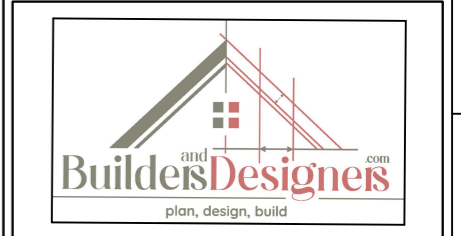

DESIGN BY TABREZ


DRAWN BY TAHER

CHECKED BY TABREZ

DRAWING NO RWSH-12

SON'S BED ROOM

ALL DIMENSIONS ARE IN FT

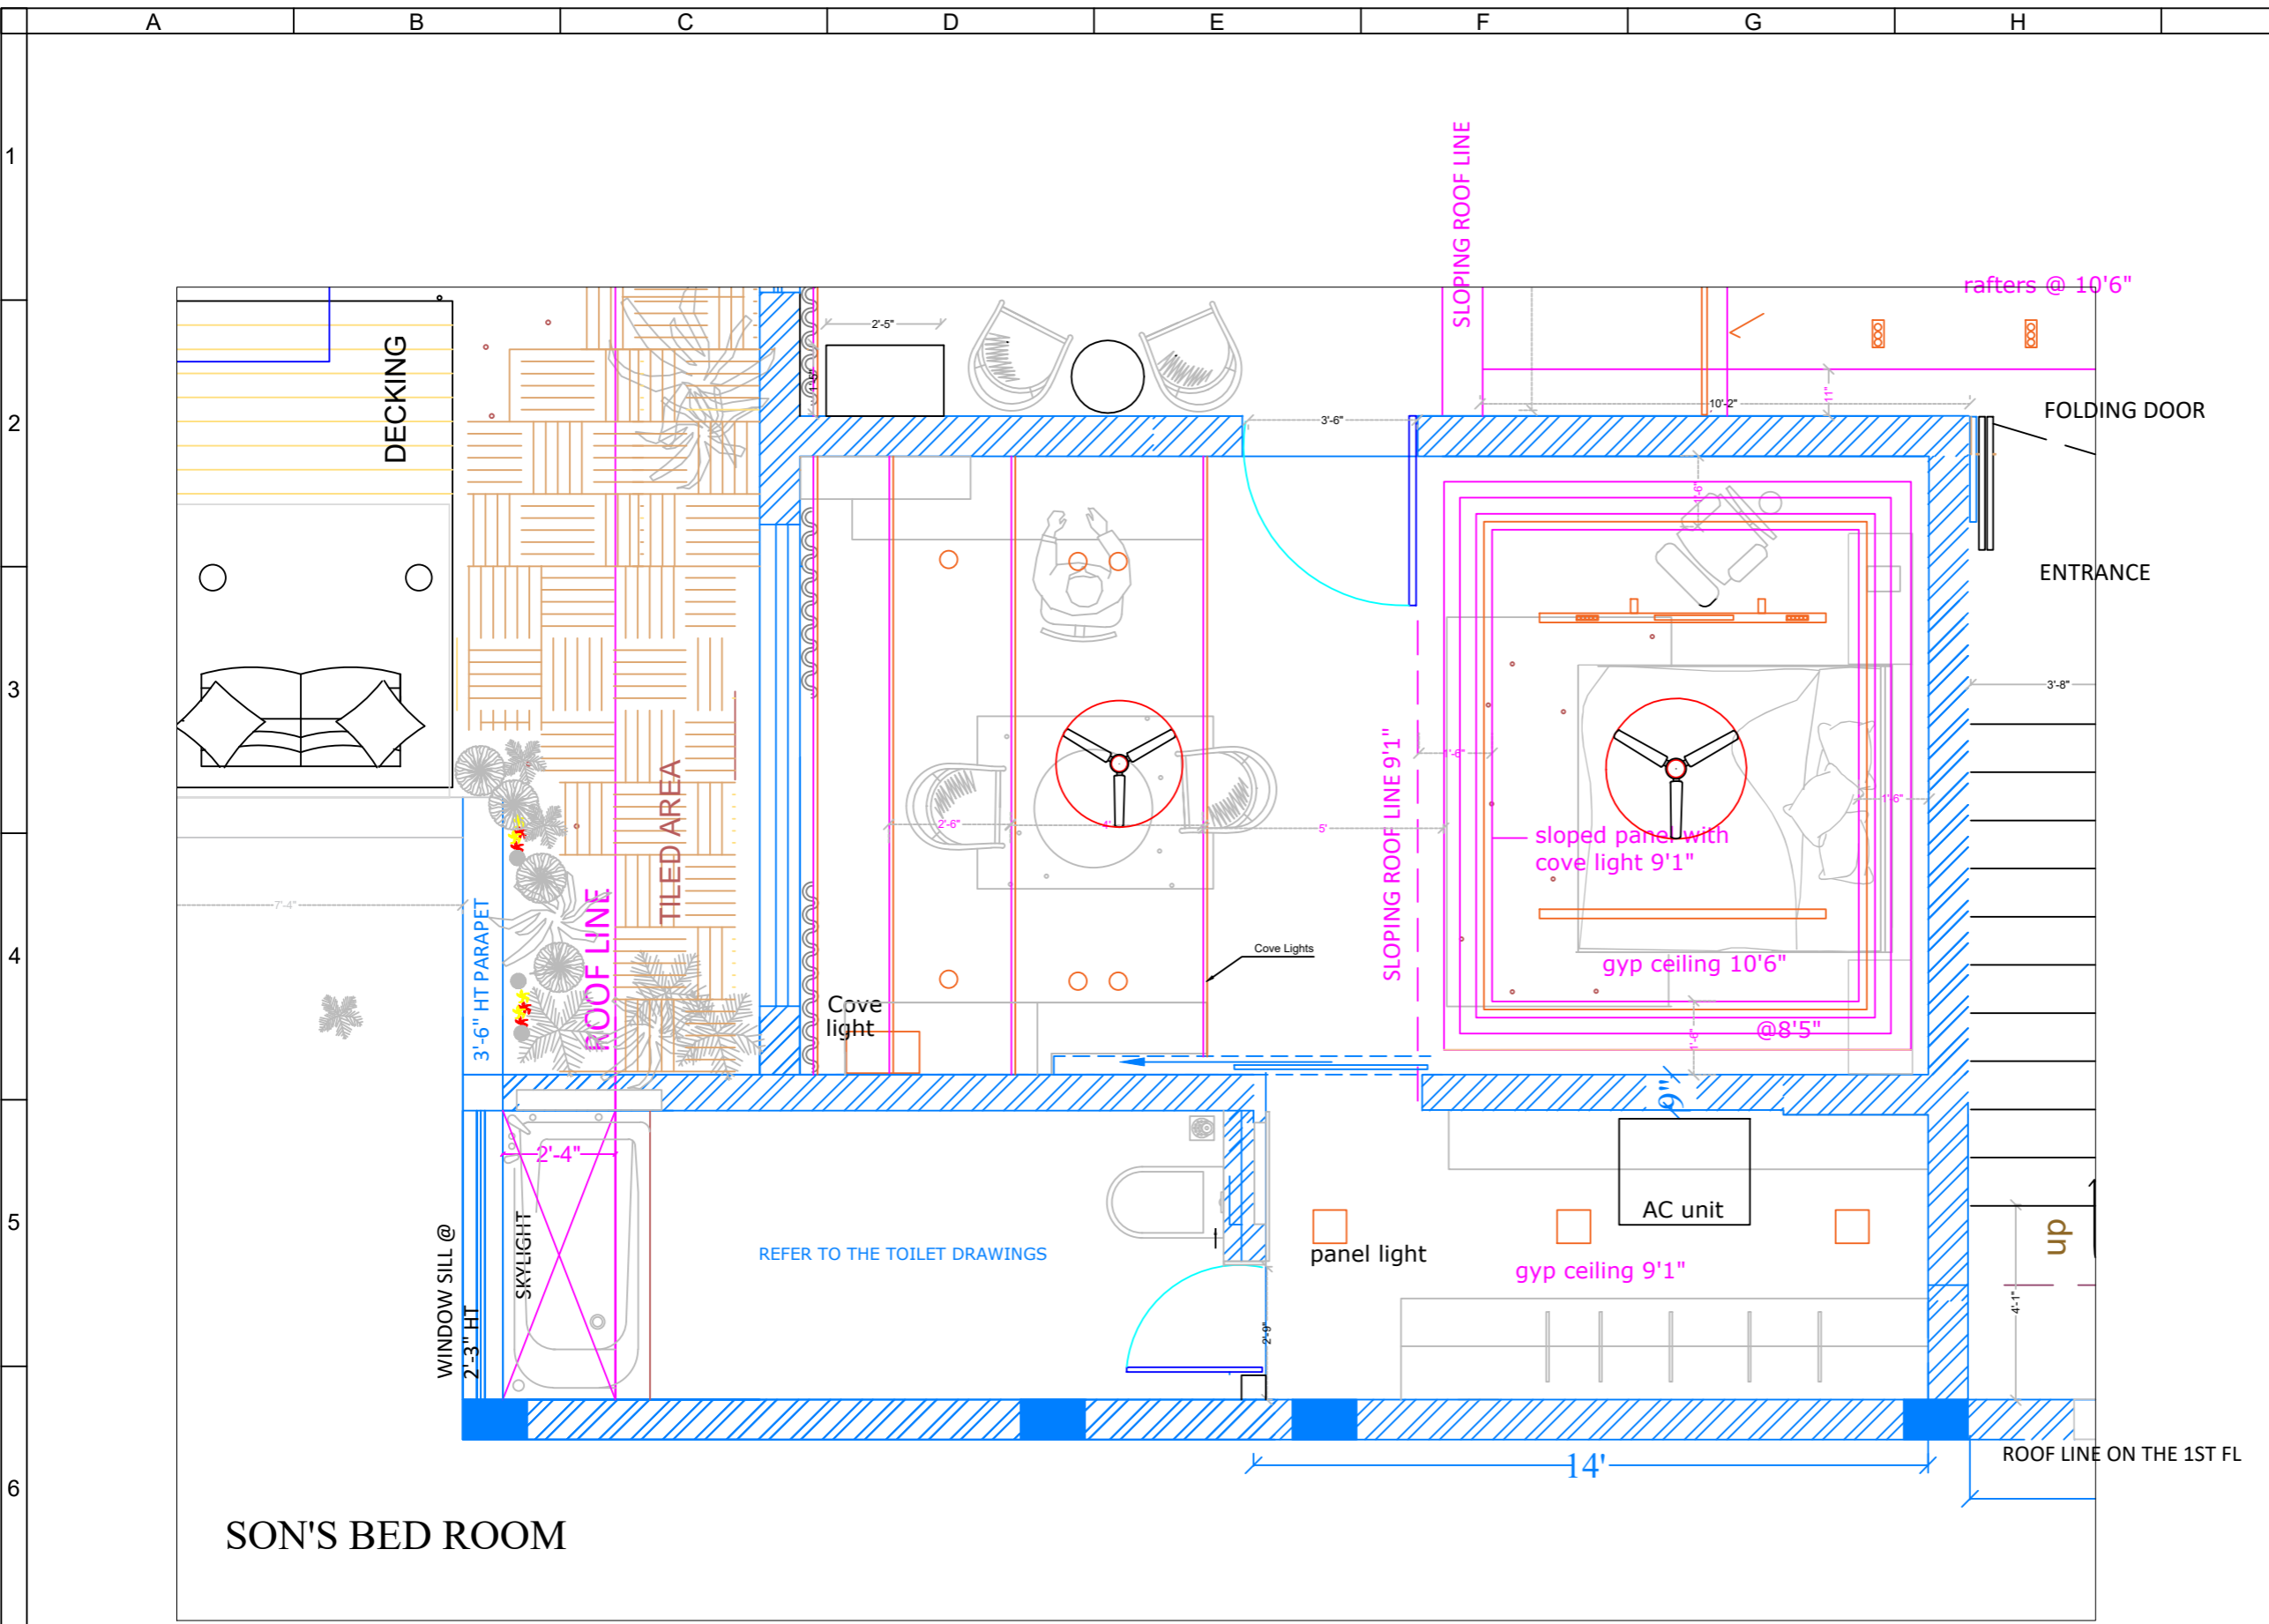


SON'S BED ROOM

- NOTES**
1. THIS DRAWING IS THE PROPERTY OF **Builders and Designers (A Unit of MAESTER (R))**, AND SHALL NOT BE COPIED OR USED WITHOUT PRIOR PERMISSION.
 2. THE DRAWING IS NOT TO THE SCALE. ONLY WRITTEN DIMENSION SHALL BE FOLLOWED.
 3. ALL DIMENSIONS ARE IN MM.

TITLE

SON'S BED ROOM
Beam Layout

SCALE: NTS
CLIENT:-
Tulsiyan Family

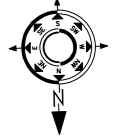

DATE OF ISSUE: 21.04.2026


REVISIONS SHEET A3

SN	REVISION NO	DATE
01	R0	21-04-2026
02		
03		



DESIGN BY TABREZ
DRAWN BY TAHER
CHECKED BY TABREZ
DRAWING NO RWSH-12

ALL DIMENSIONS ARE IN FT

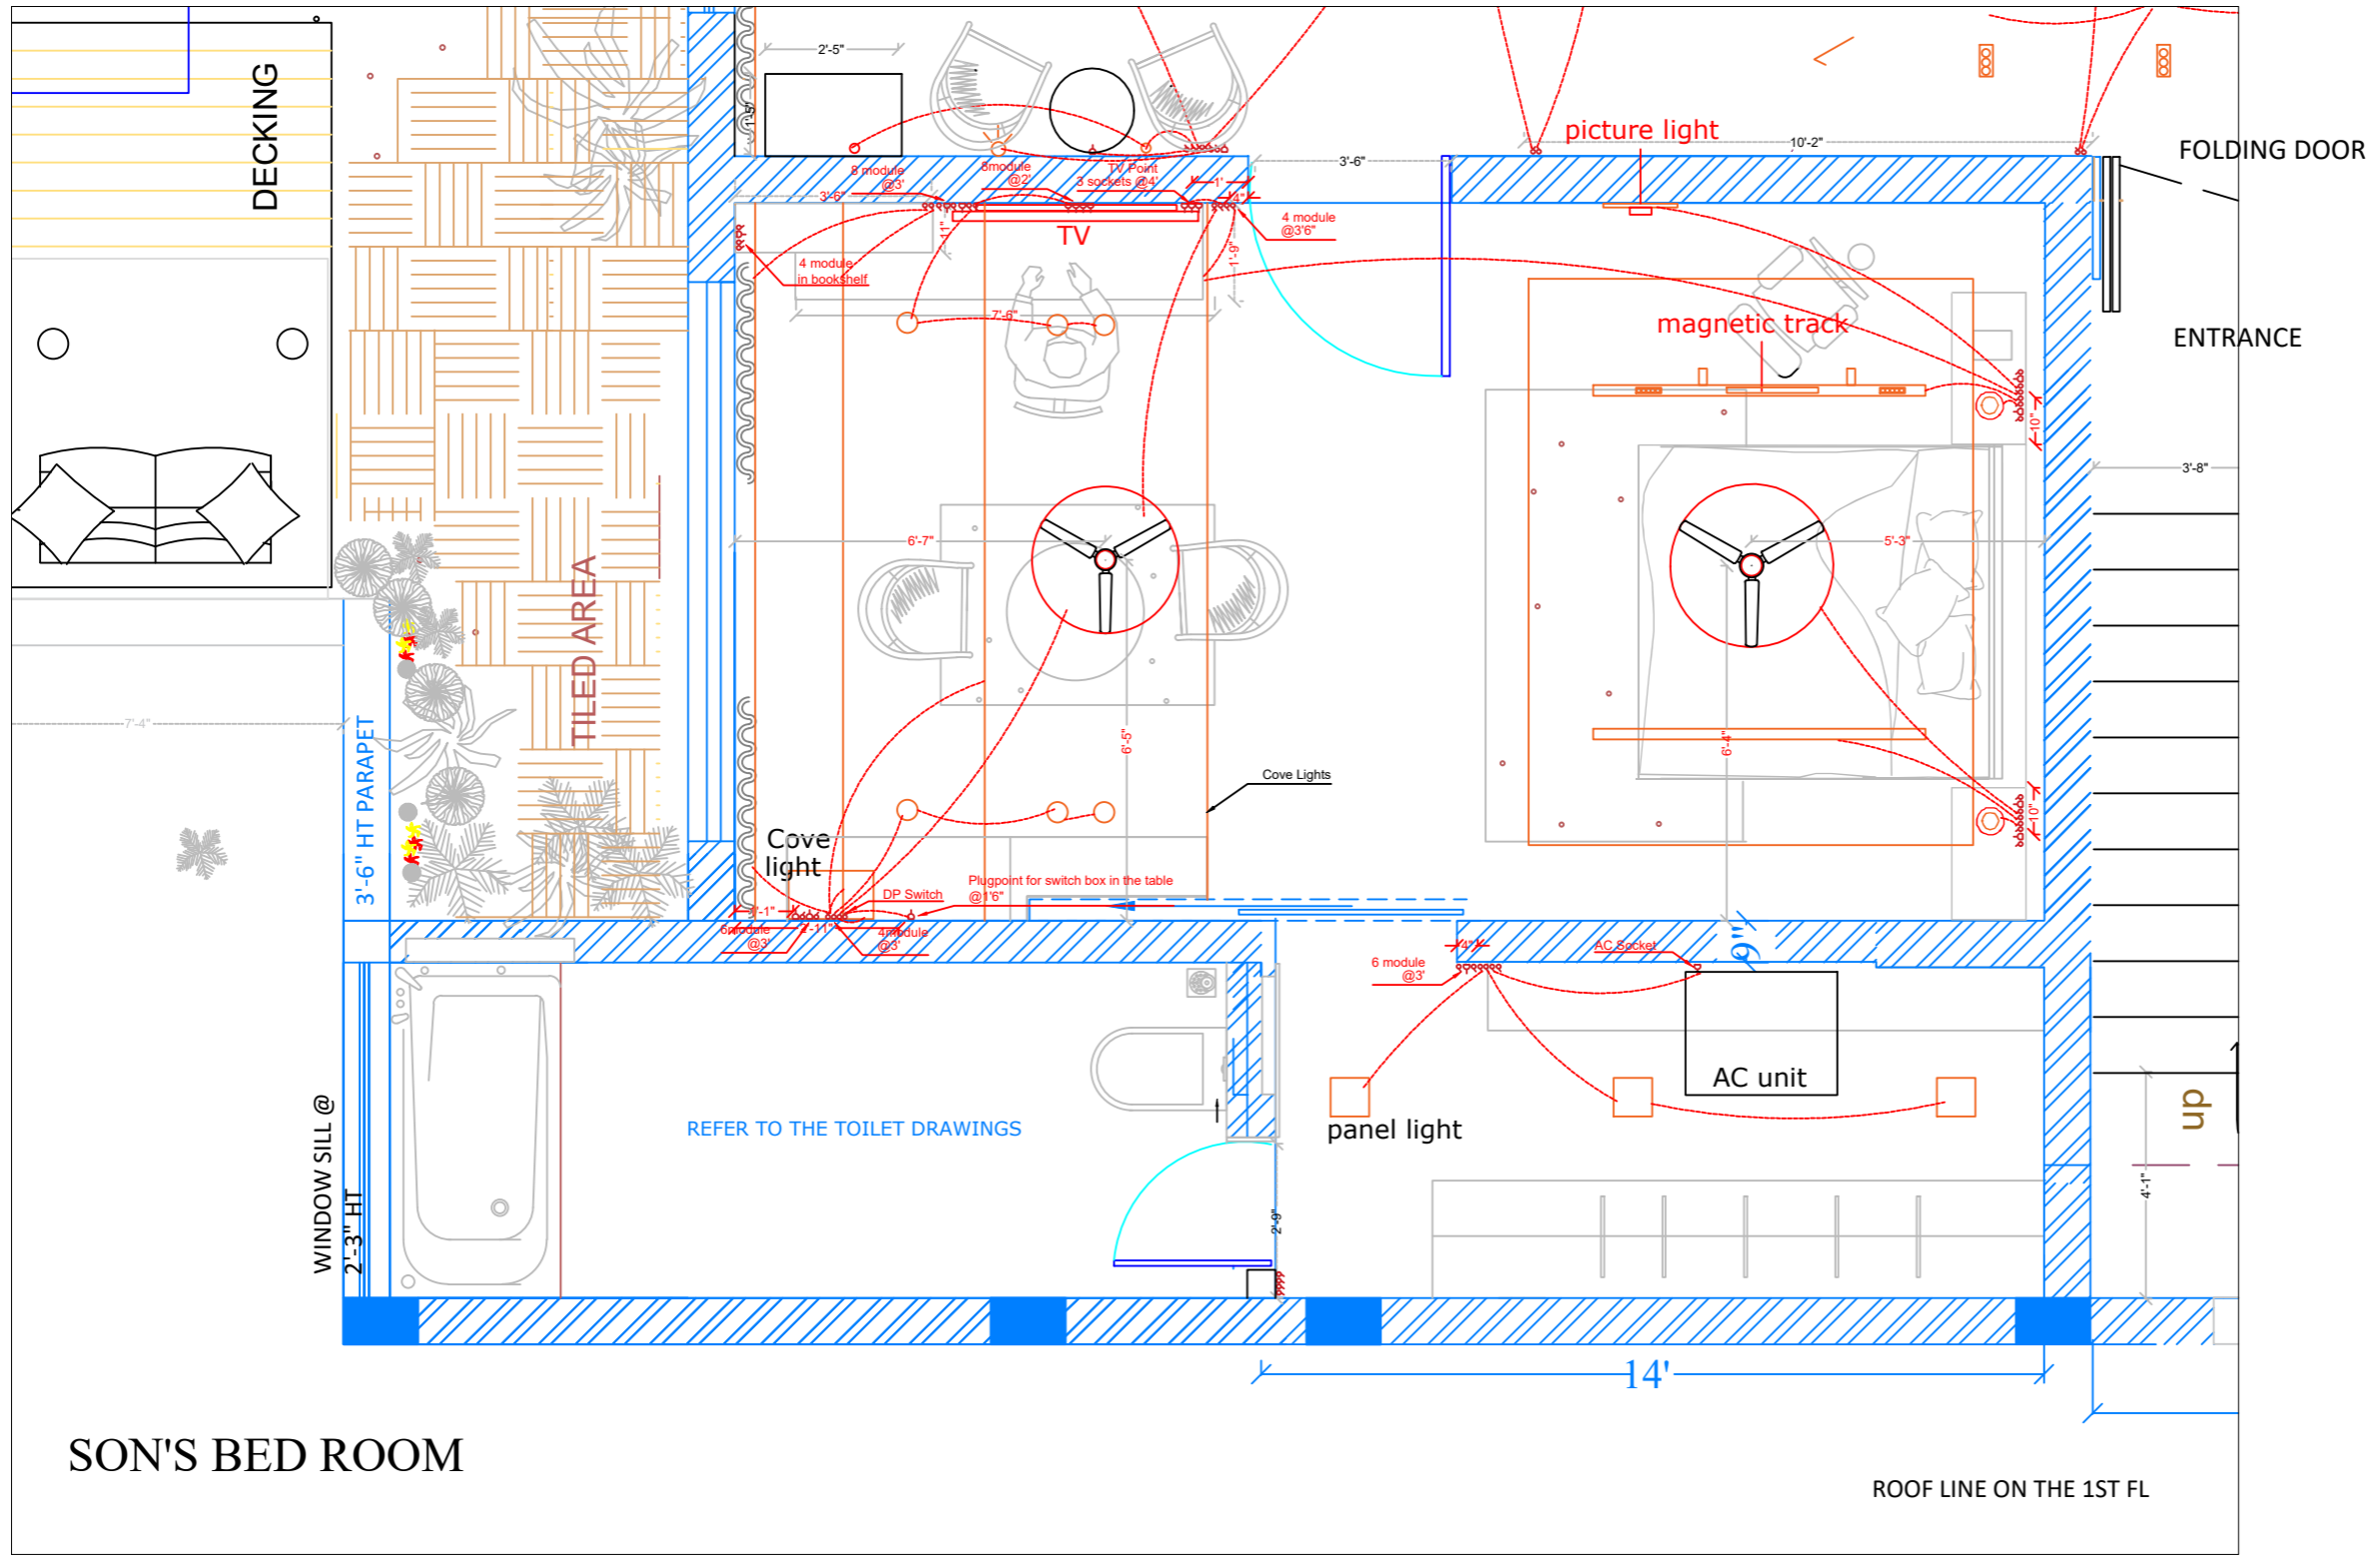

NOTES


1. THIS DRAWING IS THE PROPERTY OF **Builders and Designers (A Unit of MAESTER (R))**, AND SHALL NOT BE COPIED OR USED WITHOUT PRIOR PERMISSION.
2. THE DRAWING IS NOT TO THE SCALE. ONLY WRITTEN DIMENSION SHALL BE FOLLOWED.
3. ALL DIMENSIONS ARE IN MM.

TITLE

**SON'S BED ROOM
Electrical Layout**

SCALE: NTS

CLIENT:-
Tulsiyan Family



DATE OF ISSUE: 21.04.2026

REVISIONS SHEET A3

SN	REVISION NO	DATE
01	R0	21-04-2026
02		
03		



DESIGN BY TABREZ

DRAWN BY TAHER


CHECKED BY TABREZ

DRAWING NO RWSH-12

ALL DIMENSIONS ARE IN FT

SON'S BED ROOM

SBR TV WALL

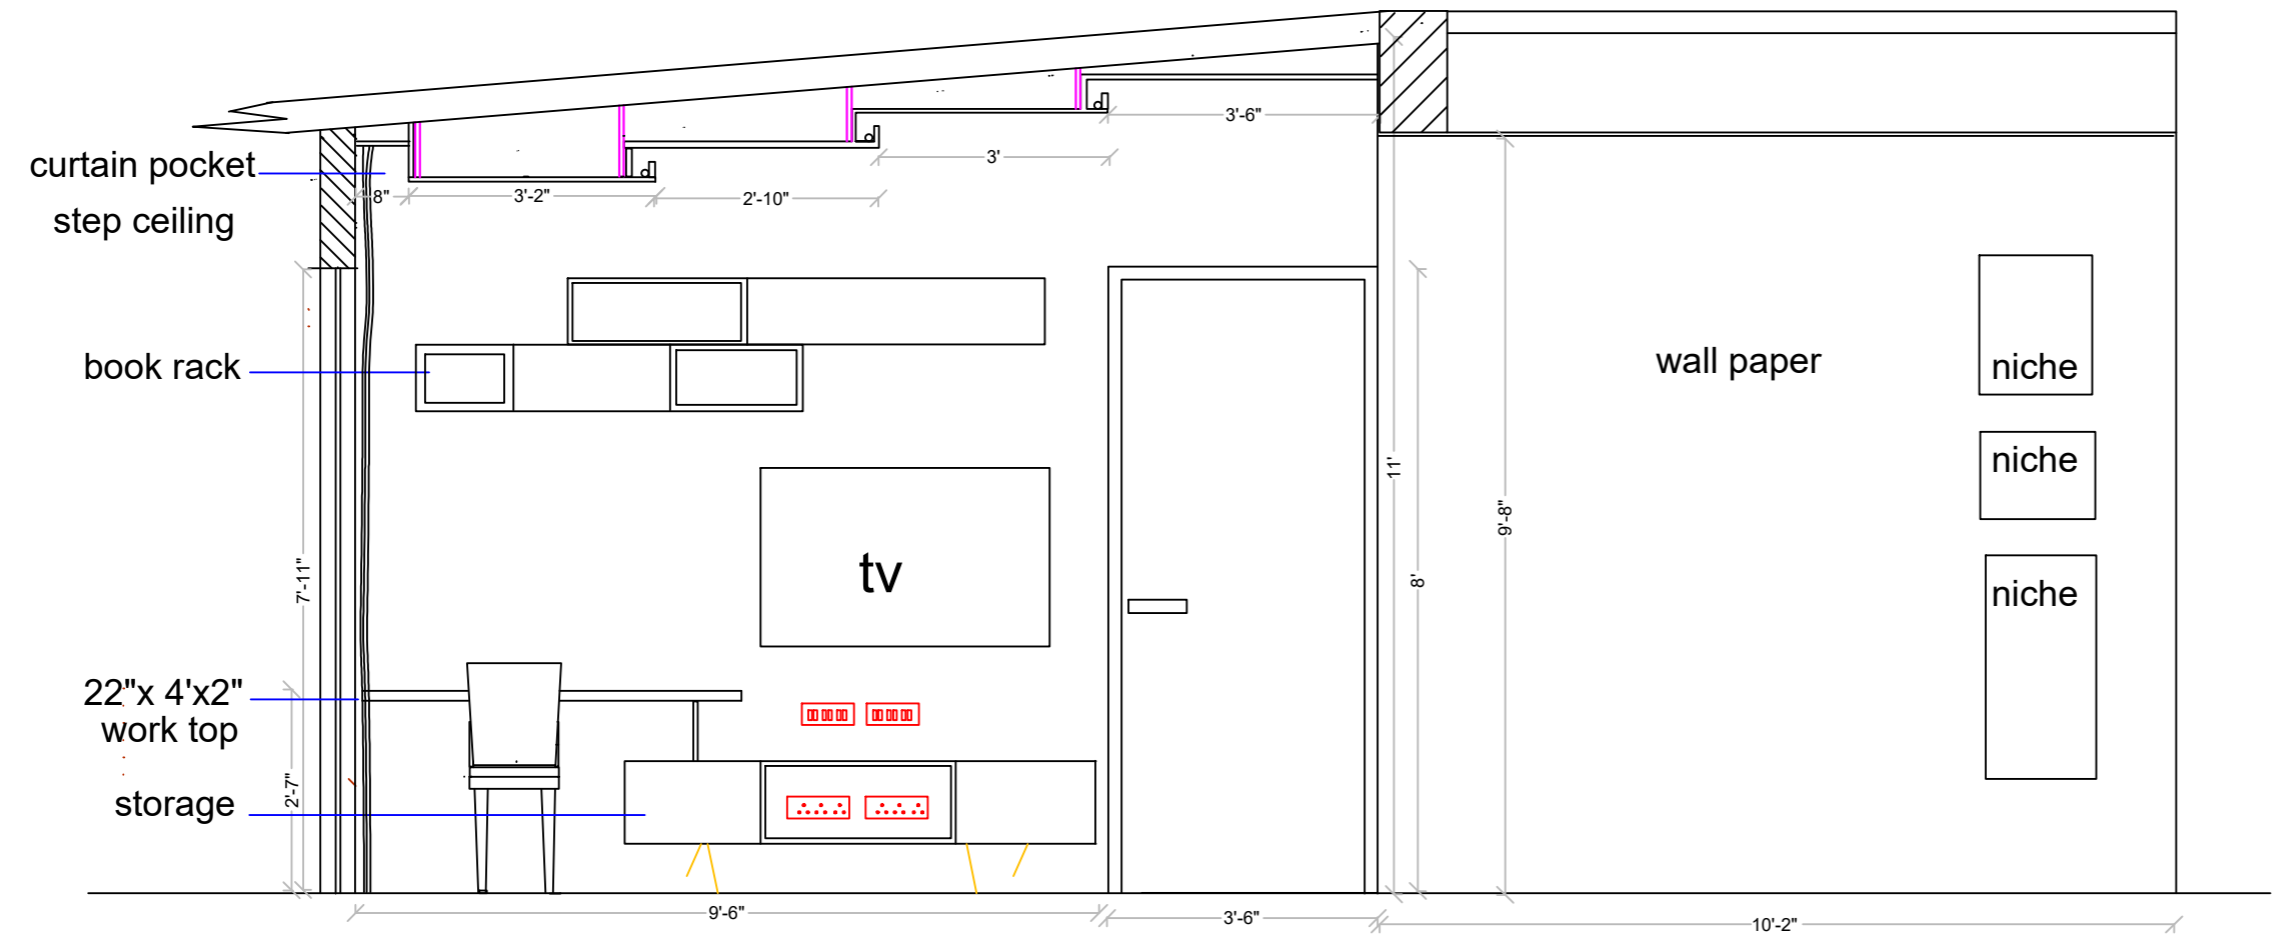

NOTES


1. THIS DRAWING IS THE PROPERTY OF **Builders and Designers (A Unit of MAESTER (R))**, AND SHALL NOT BE COPIED OR USED WITHOUT PRIOR PERMISSION.
2. THE DRAWING IS NOT TO THE SCALE. ONLY WRITTEN DIMENSION SHALL BE FOLLOWED.
3. ALL DIMENSIONS ARE IN MM.

TITLE

SBR TV WALL

SCALE: NTS


CLIENT:-
Tulsiyan Family

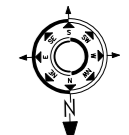

DATE OF ISSUE: 21.04.2026

REVISIONS SHEET A3

SN	REVISION NO	DATE
01	R0	21-04-2026
02		
03		

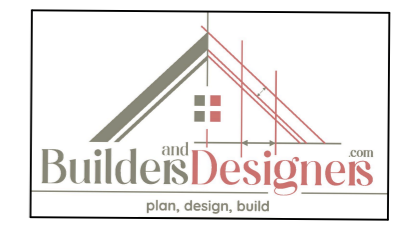

DESIGN BY TABREZ


DRAWN BY TAHER

CHECKED BY TABREZ

DRAWING NO RWSH-12

ALL DIMENSIONS ARE IN FT

SBR Vinyl deck wall

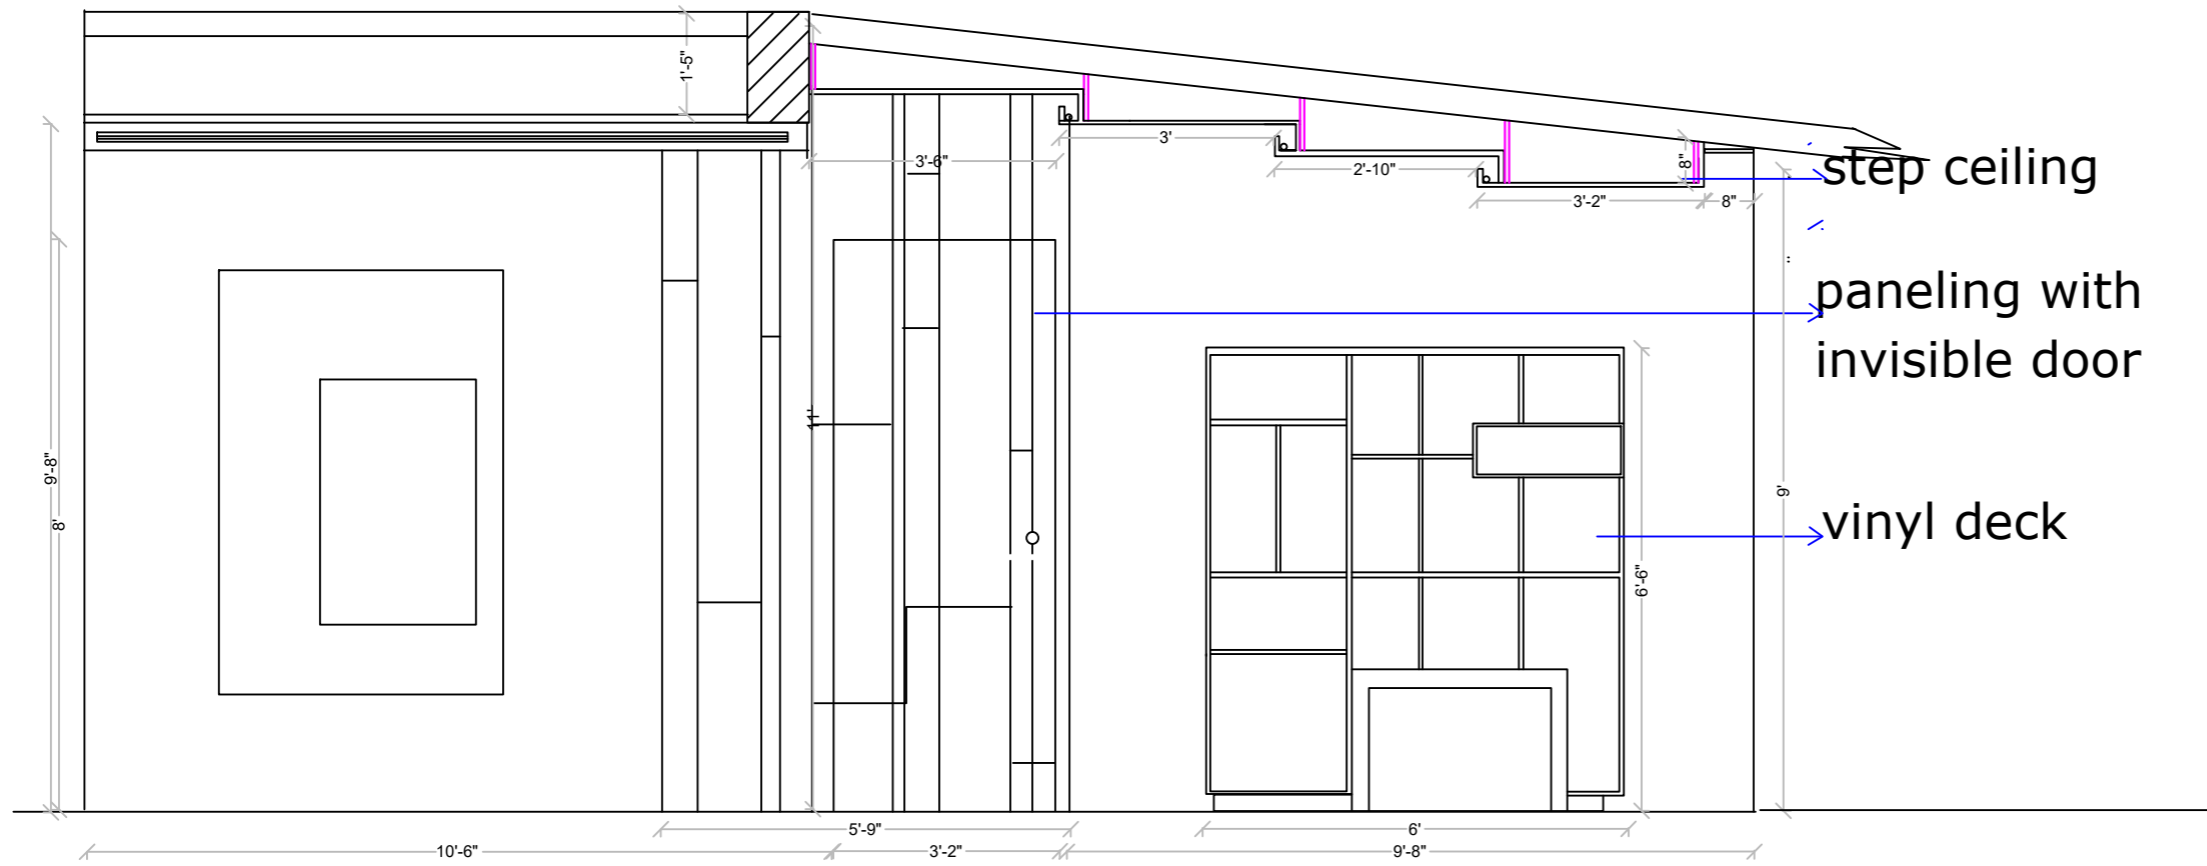


NOTES

1. THIS DRAWING IS THE PROPERTY OF **Builders and Designers (A Unit of MAESTER (R))**, AND SHELL NOT BE COPIED OR USED WITHOUT PRIOR PERMISSION.
2. THE DRAWING IS NOT TO THE SCALE. ONLY WRITTEN DIMENSION SHALL BE FOLLOWED.
3. ALL DIMENSIONS ARE IN MM.

TITLE

SBR Vinyl deck wall


SCALE: NTS
 CLIENT:-
 Tulsian Family

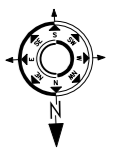

DATE OF ISSUE: 21.04.2026

REVISIONS SHEET A3

SN	REVISION NO	DATE
01	R0	21-04-2026
02		
03		

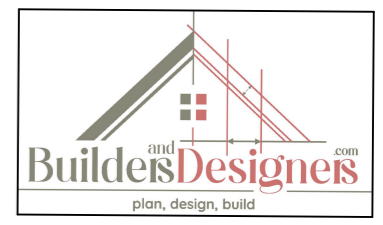


DESIGN BY TABREZ
 DRAWN BY TAHER
 CHECKED BY TABREZ
 DRAWING NO RWSH-12

ALL DIMENSIONS ARE IN FT


NOTES

1. THIS DRAWING IS THE PROPERTY OF **Builders and Designers (A Unit of MAESTER (R))**, AND SHALL NOT BE COPIED OR USED WITHOUT PRIOR PERMISSION.
2. THE DRAWING IS NOT TO THE SCALE. ONLY WRITTEN DIMENSION SHALL BE FOLLOWED.
3. ALL DIMENSIONS ARE IN MM.


SON'S BEDROOM WARDROBE

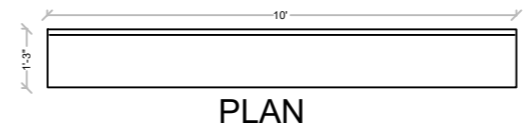


PLAN

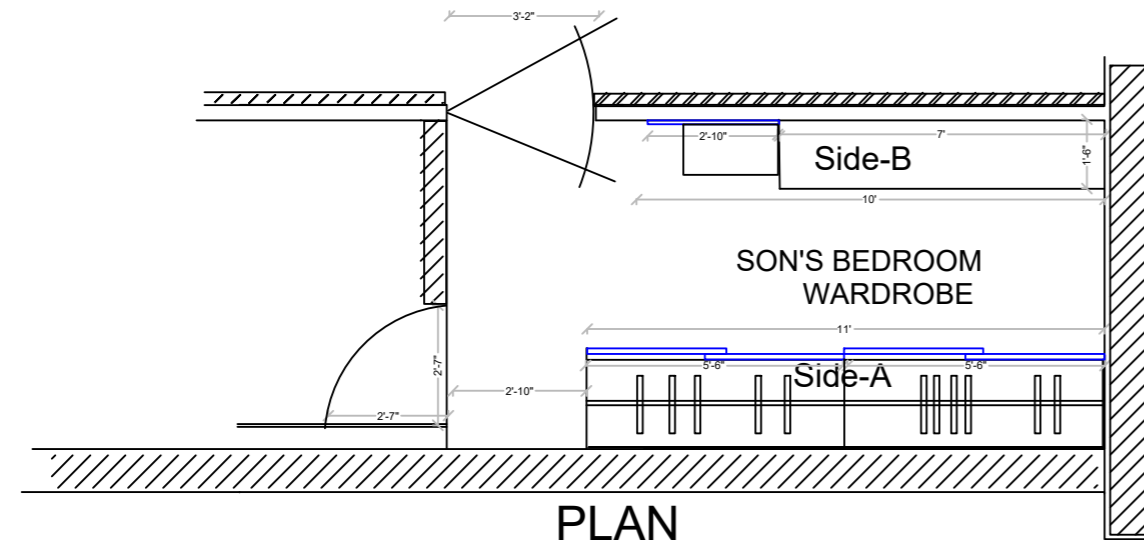

PLAN

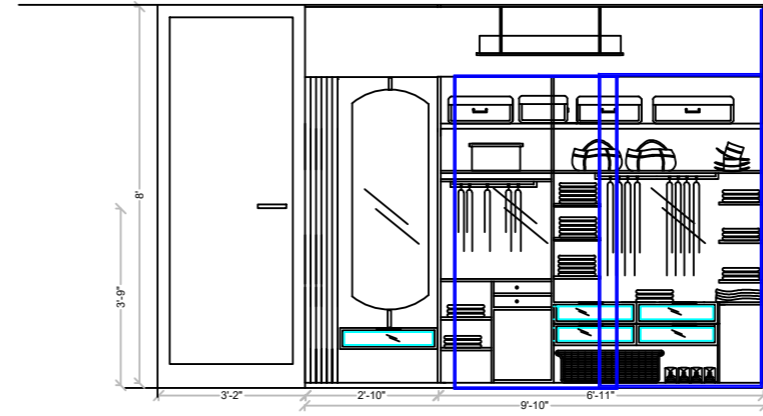

ELEVATIONS
SON'S WIC, 1st FLOOR, SIDE B

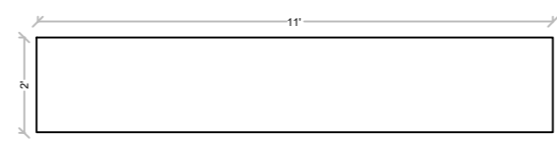

PLAN

TITLE

SON'S BEDROOM WARDROBE


SCALE: NTS

CLIENT:-
Tulsiyan Family


DATE OF ISSUE: 21.04.2026

REVISIONS SHEET A3


SN	REVISION NO	DATE
01	R0	21-04-2026
02		
03		

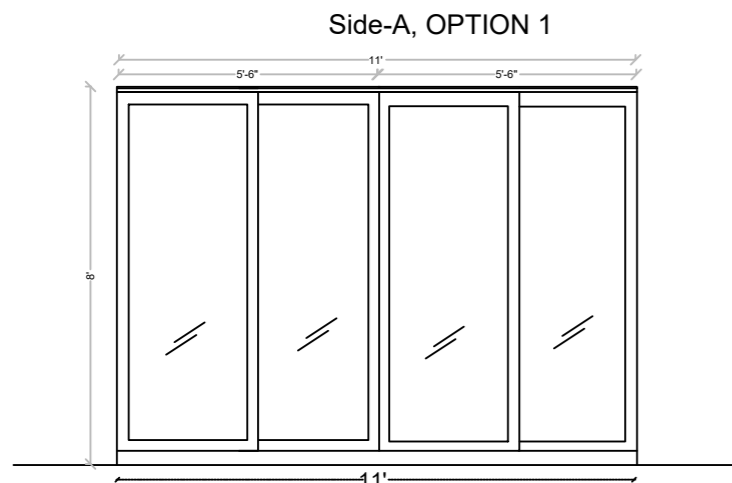

ELEVATIONS
SON'S WARDROBE 1st FLOOR, Exterior

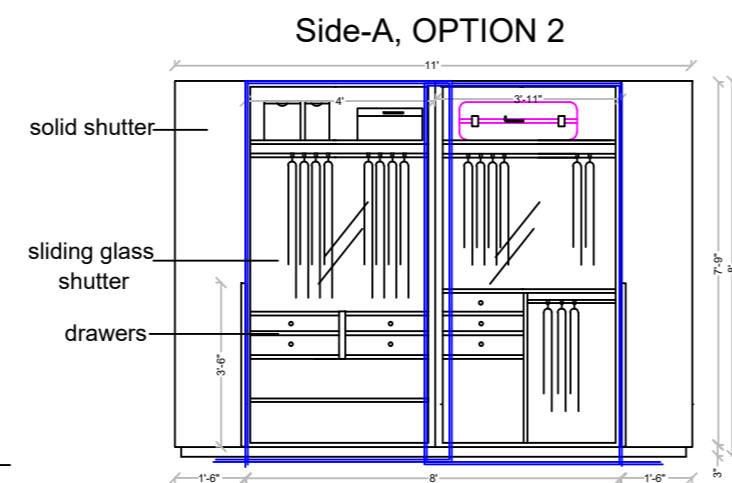


ELEVATIONS
SON'S WARDROBE 1st FLOOR, Exterior

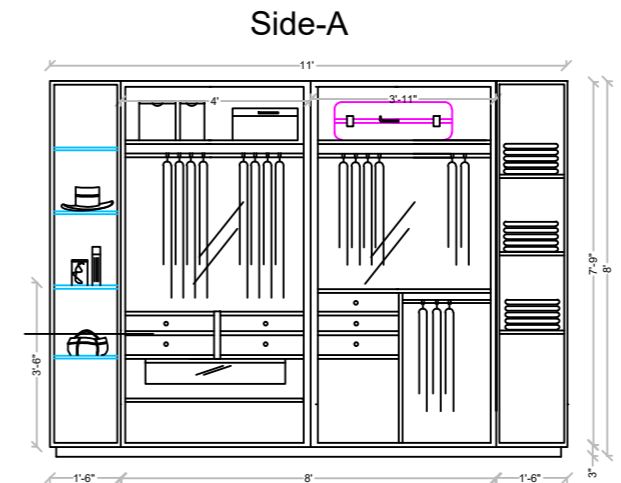

ELEVATIONS
SON'S WARDROBE 1st FLOOR, Interior

ALL DIMENSIONS ARE IN FT

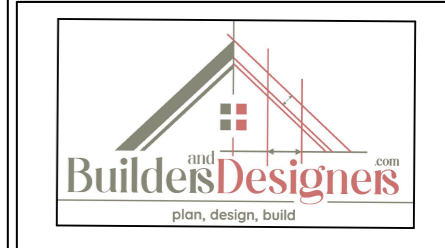


DESIGN BY TABREZ

DRAWN BY TAHER

CHECKED BY TABREZ

DRAWING NO RWSH-12

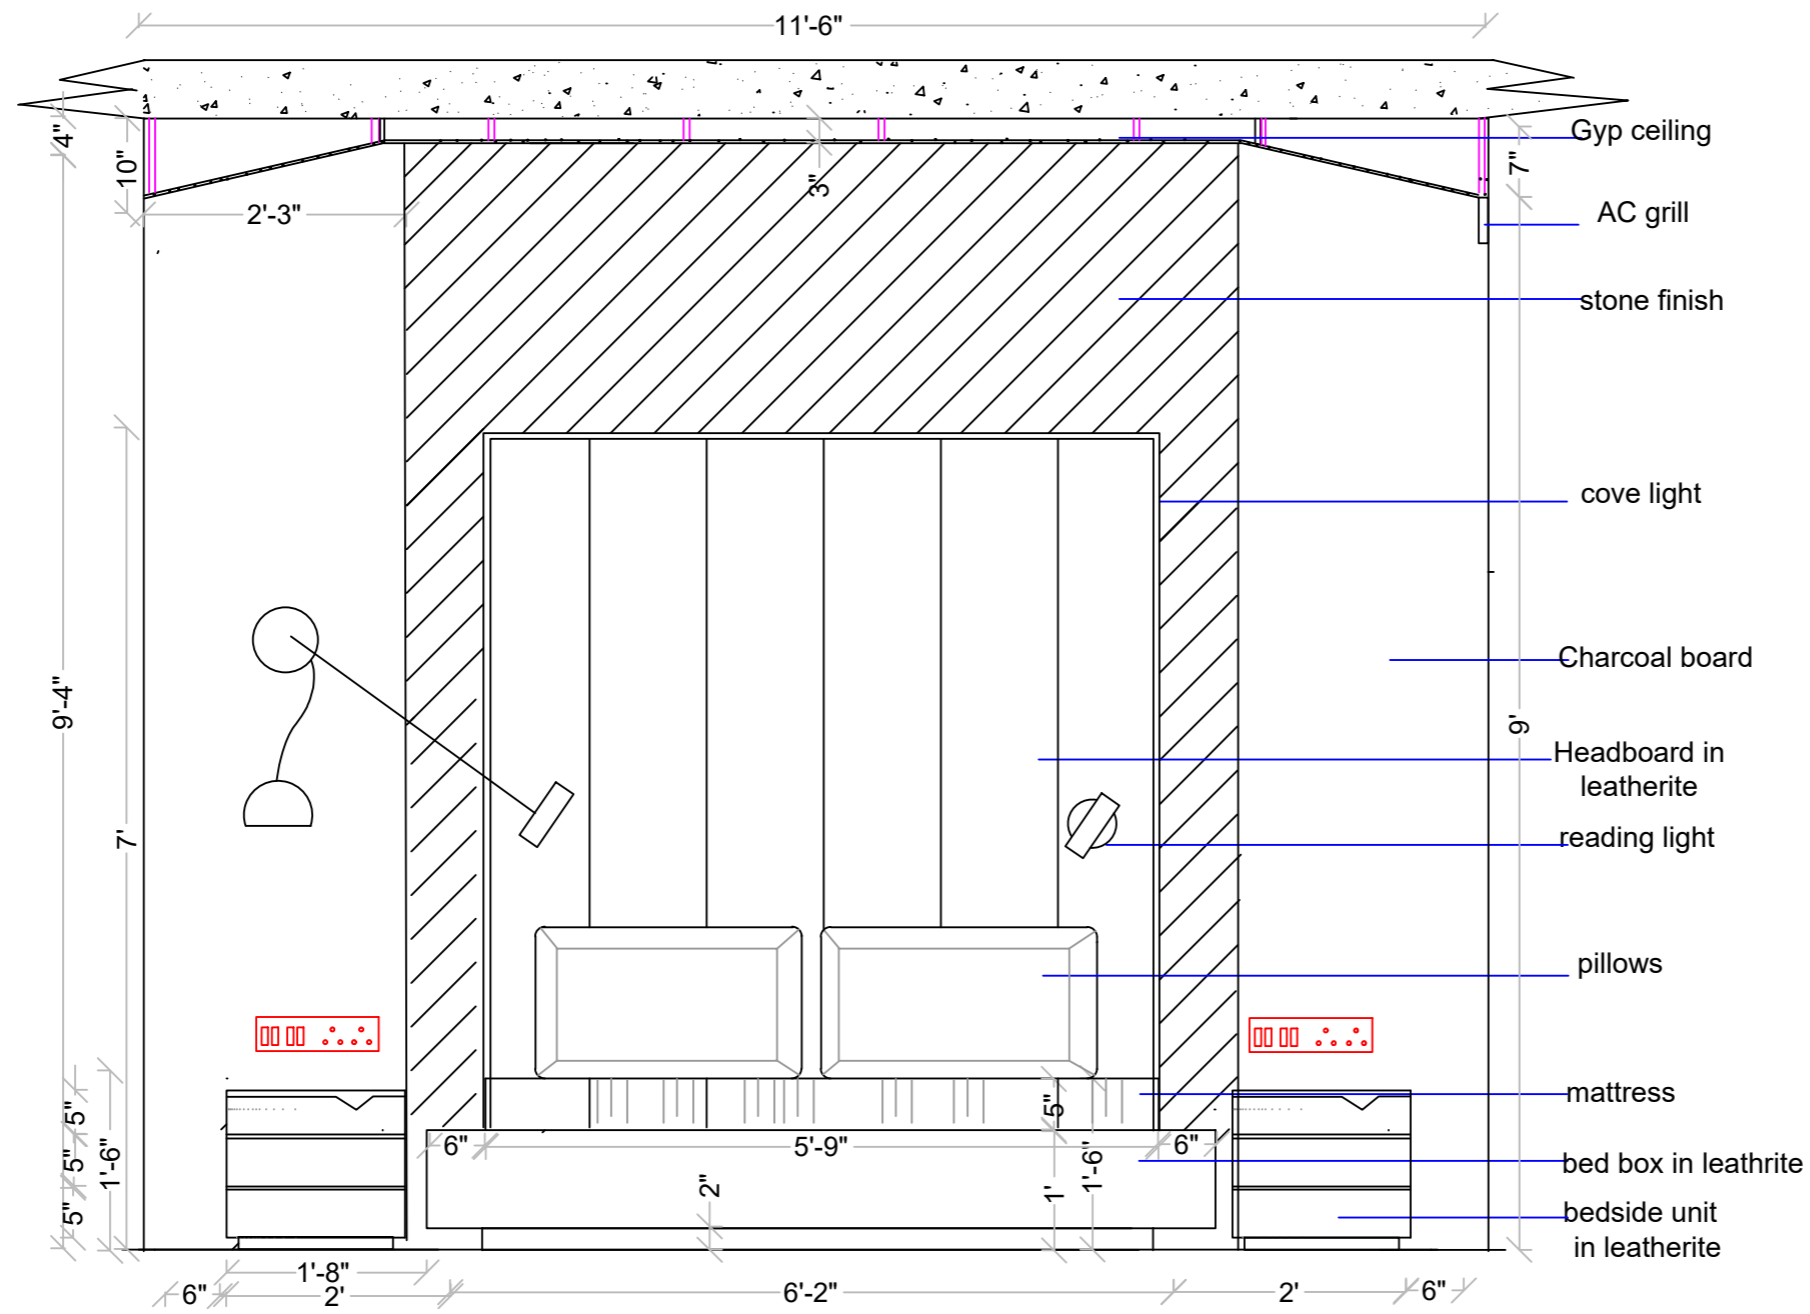

BEDSTEAD WALL, SBR

SON'S BED ROOM

ALL DIMENSIONS ARE IN FT

NOTES


1. THIS DRAWING IS THE PROPERTY OF **Builders and Designers (A Unit of MAESTER (R))**, AND SHELL NOT BE COPIED OR USED WITHOUT PRIOR PERMISSION.
2. THE DRAWING IS NOT TO THE SCALE. ONLY WRITTEN DIMENSION SHALL BE FOLLOWED.
3. ALL DIMENSIONS ARE IN MM.

TITLE

SON'S BED ROOM
Badetead WALL

SCALE: NTS


CLIENT:-
Tulsiyan Family

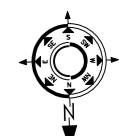

DATE OF ISSUE: 21.04.2026

REVISIONS SHEET A3

SN	REVISION NO	DATE
01	R0	21-04-2026
02		
03		

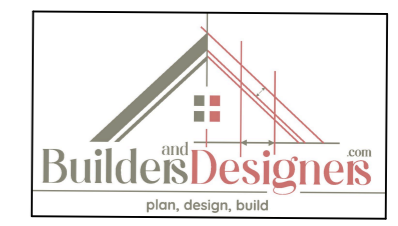

DESIGN BY TABREZ


DRAWN BY TAHER

CHECKED BY TABREZ

DRAWING NO RWSH-12

NOTES

1. THIS DRAWING IS THE PROPERTY OF **Builders and Designers (A Unit of MAESTER (R))**, AND SHELL NOT BE COPIED OR USED WITHOUT PRIOR PERMISSION.
2. THE DRAWING IS NOT TO THE SCALE. ONLY WRITTEN DIMENSION SHALL BE FOLLOWED.
3. ALL DIMENSIONS ARE IN MM.

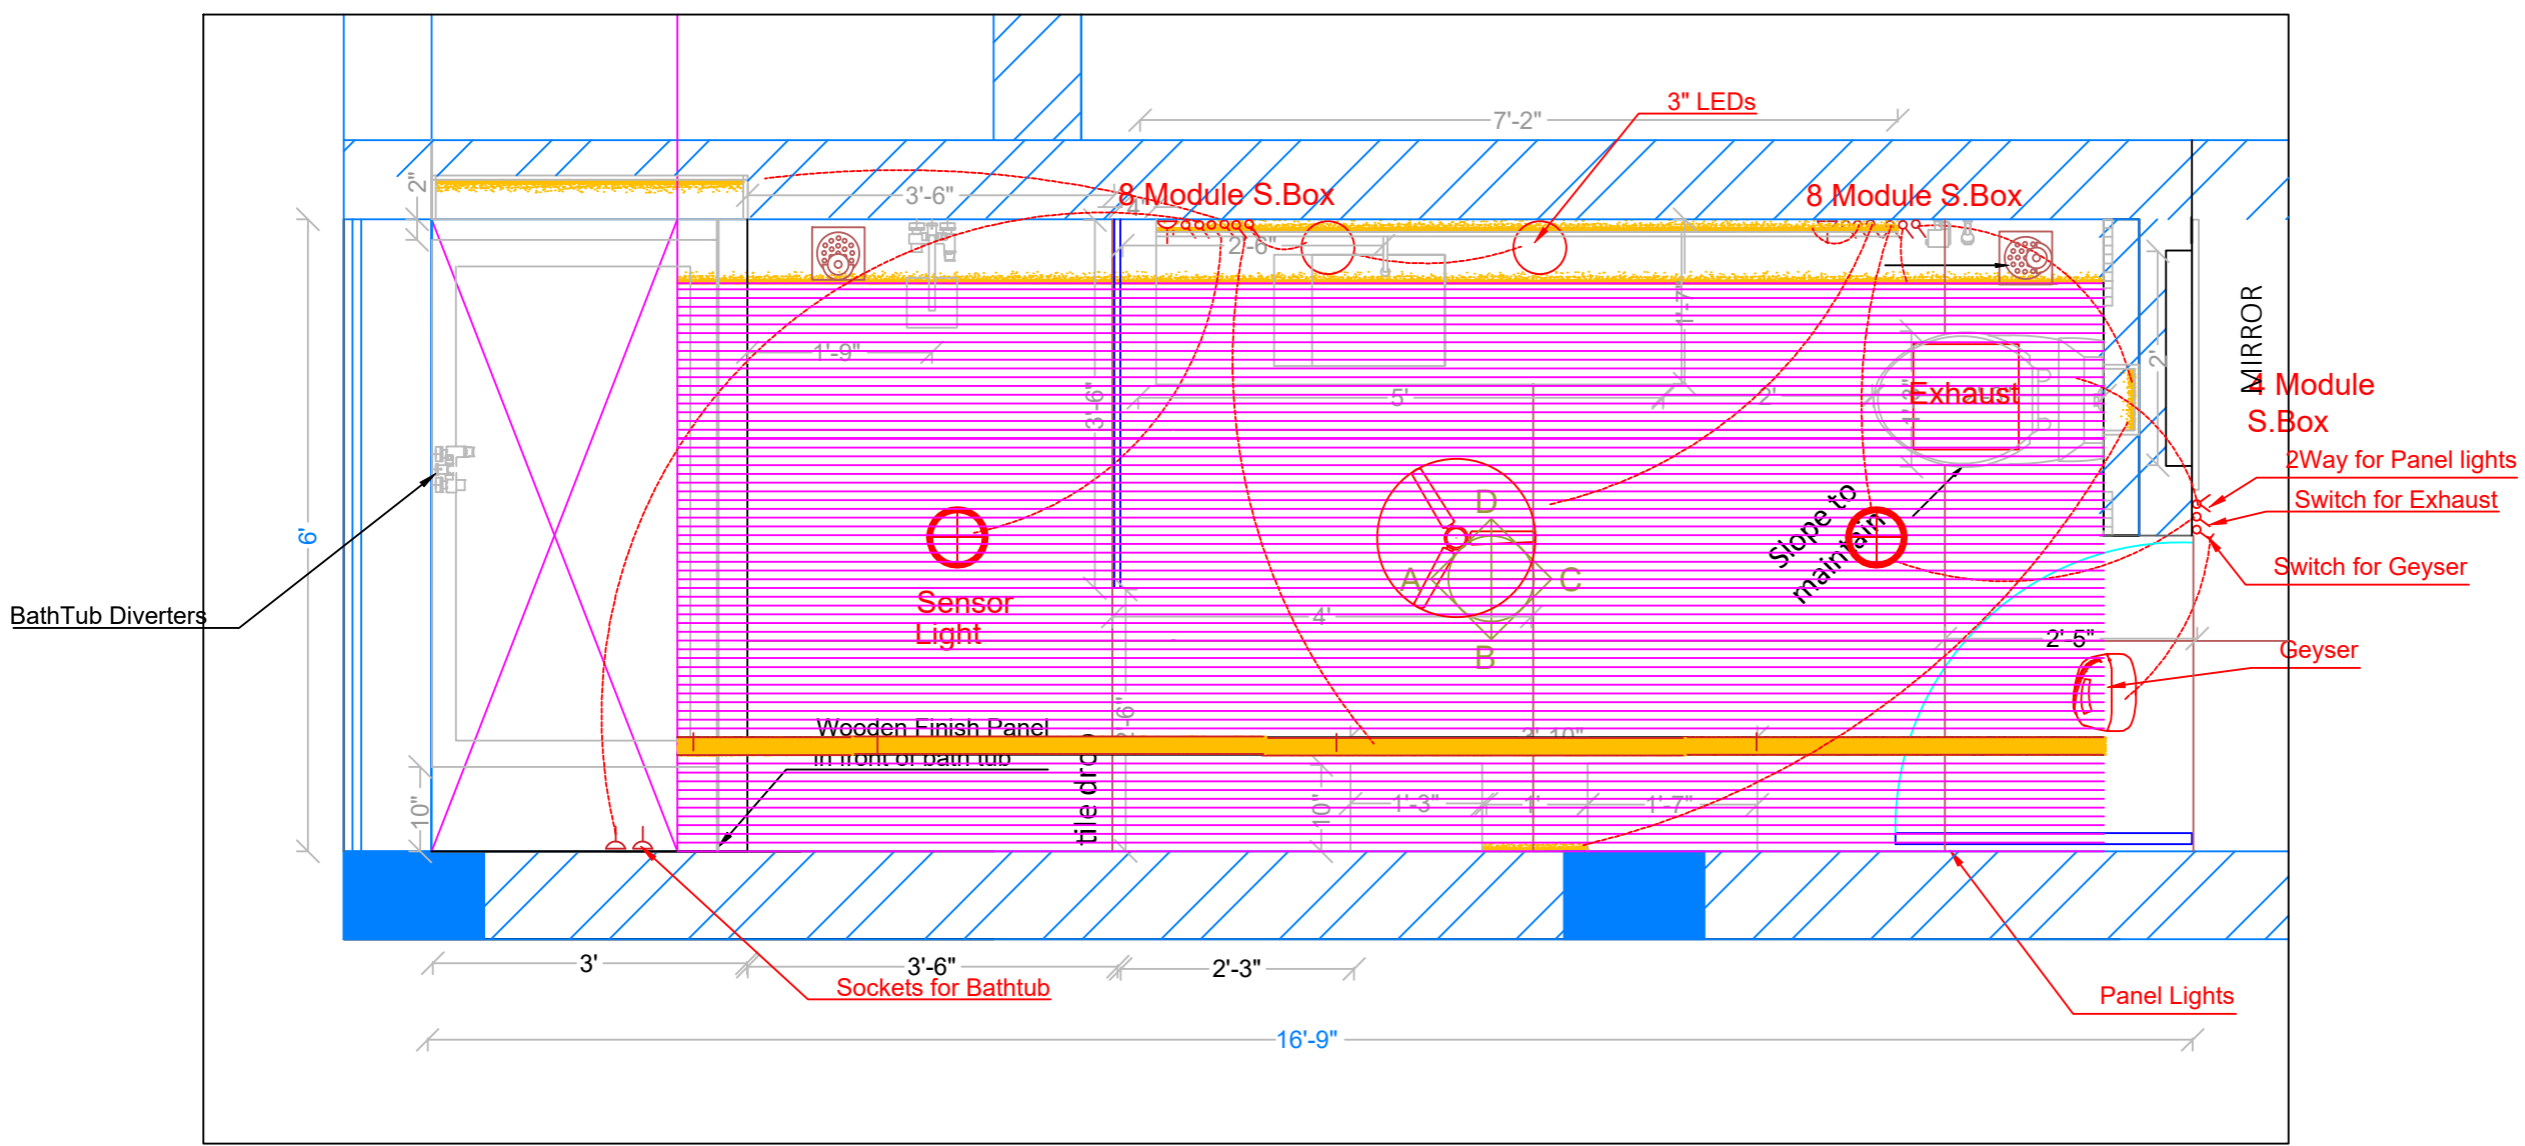


TITLE

**SONS ROOM TOILET
Electrical Layout**

SCALE: NTS

CLIENT:-
Tulsiyan Family

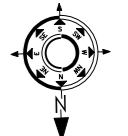


DATE OF ISSUE: 21.04.2026

REVISIONS SHEET A3

SN	REVISION NO	DATE
01	R0	21-04-2026
02		
03		



SONS ROOM TOILET

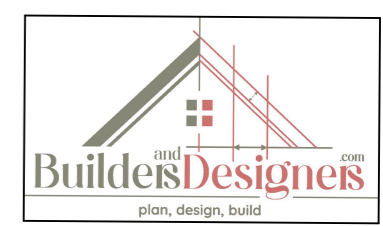

DESIGN BY	TABREZ
DRAWN BY	TAHER
CHECKED BY	TABREZ
DRAWING NO	RWSH-12

ALL DIMENSIONS ARE IN FT

Sons Toilet Elevations

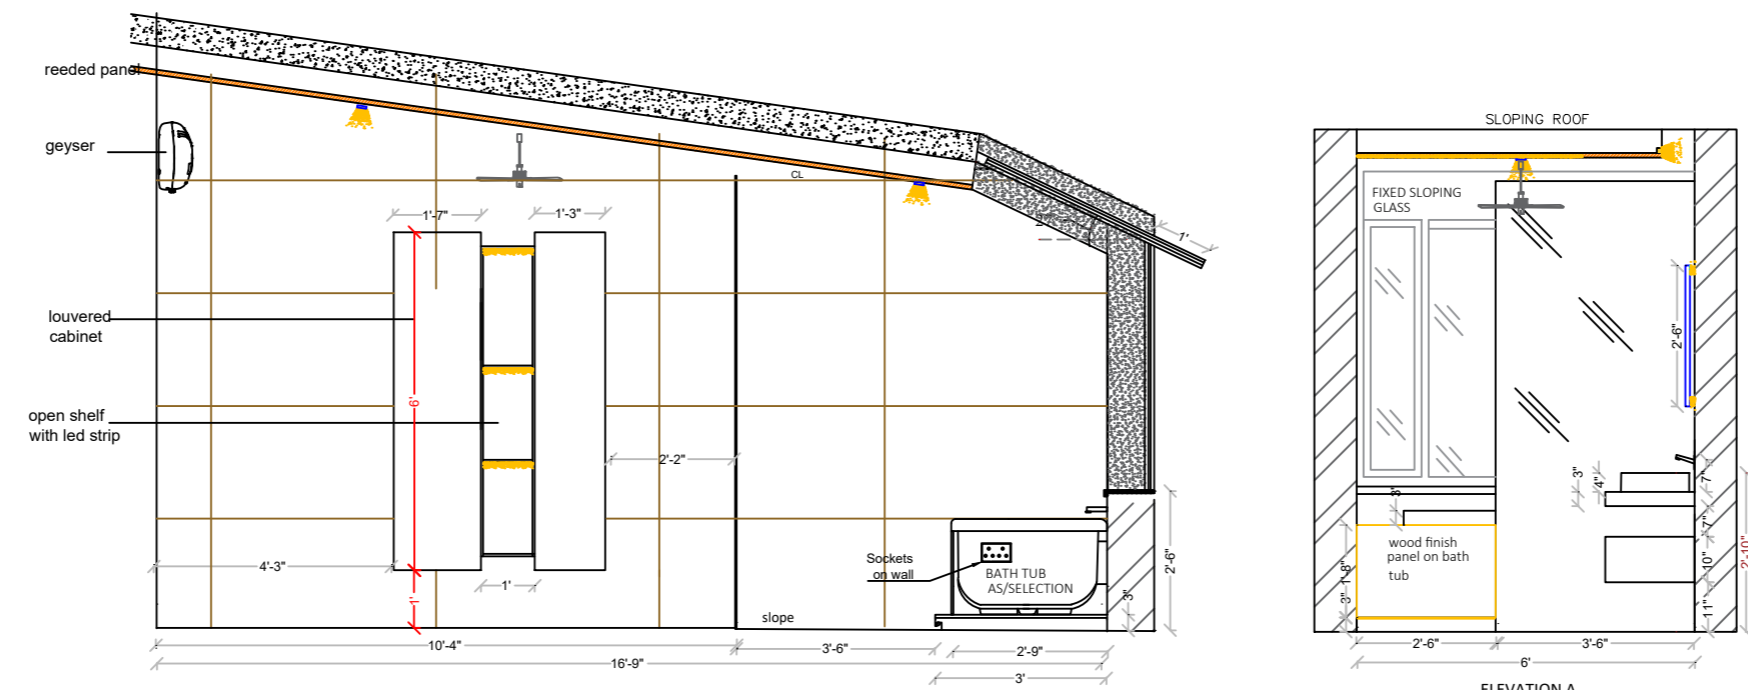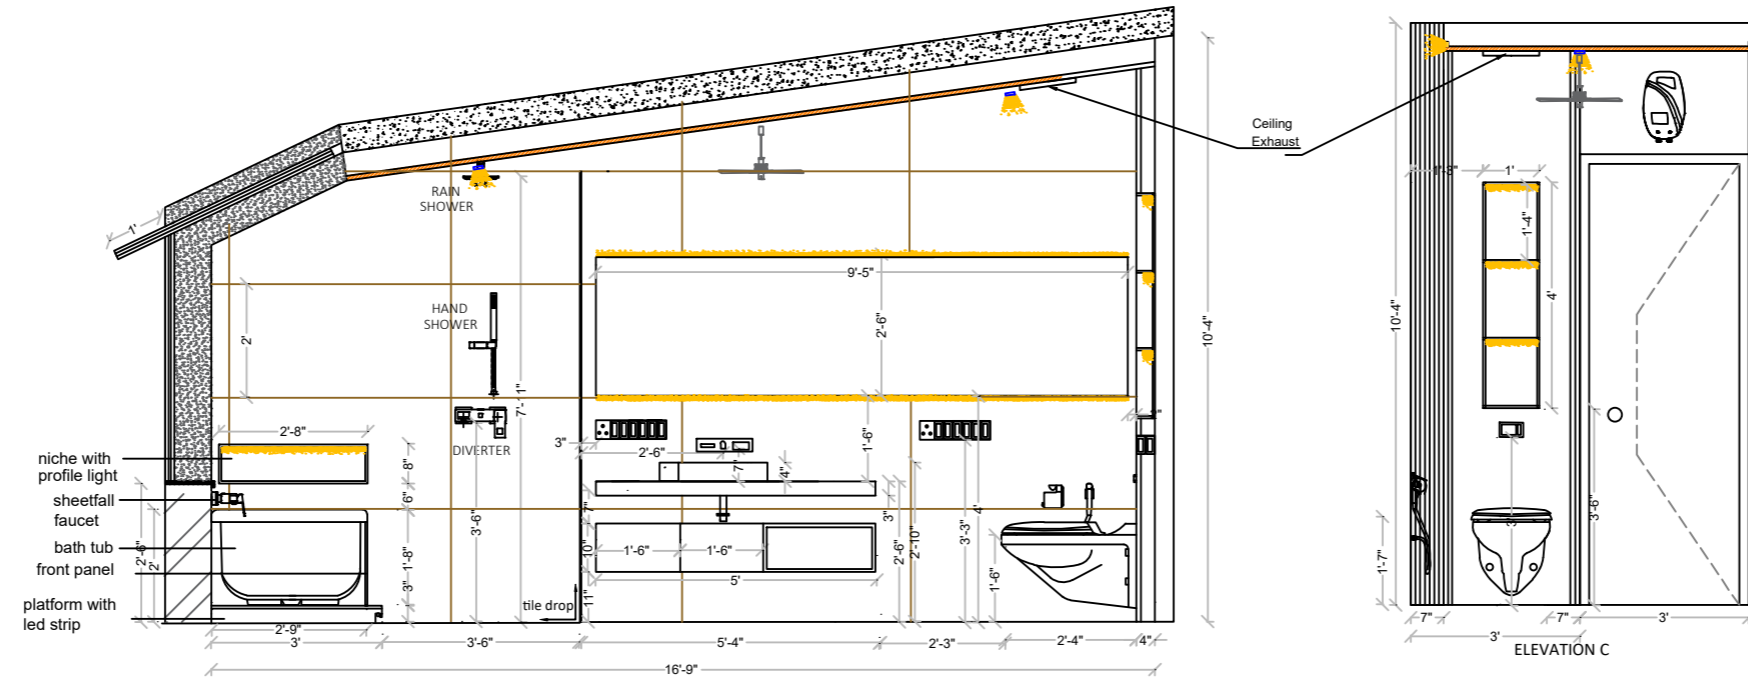

NOTES

1. THIS DRAWING IS THE PROPERTY OF **Builders and Designers (A Unit of MAESTER (R))**, AND SHELL NOT BE COPIED OR USED WITHOUT PRIOR PERMISSION.
2. THE DRAWING IS NOT TO THE SCALE. ONLY WRITTEN DIMENSION SHALL BE FOLLOWED.
3. ALL DIMENSIONS ARE IN MM.

TITLE

Sons Toilet Elevations


SCALE: NTS

CLIENT:-
Tulsiyan Family

DATE OF ISSUE: 21.04.2026

REVISIONS SHEET A3

SN	REVISION NO	DATE
01	R0	21-04-2026
02		
03		

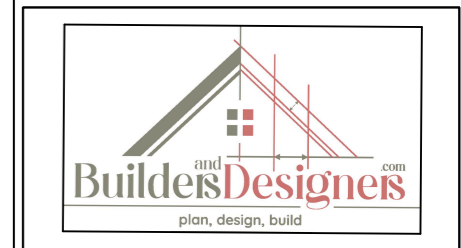


DESIGN BY TABREZ

DRAWN BY TAHER

CHECKED BY TABREZ

DRAWING NO RWSH-12

ALL DIMENSIONS ARE IN FT

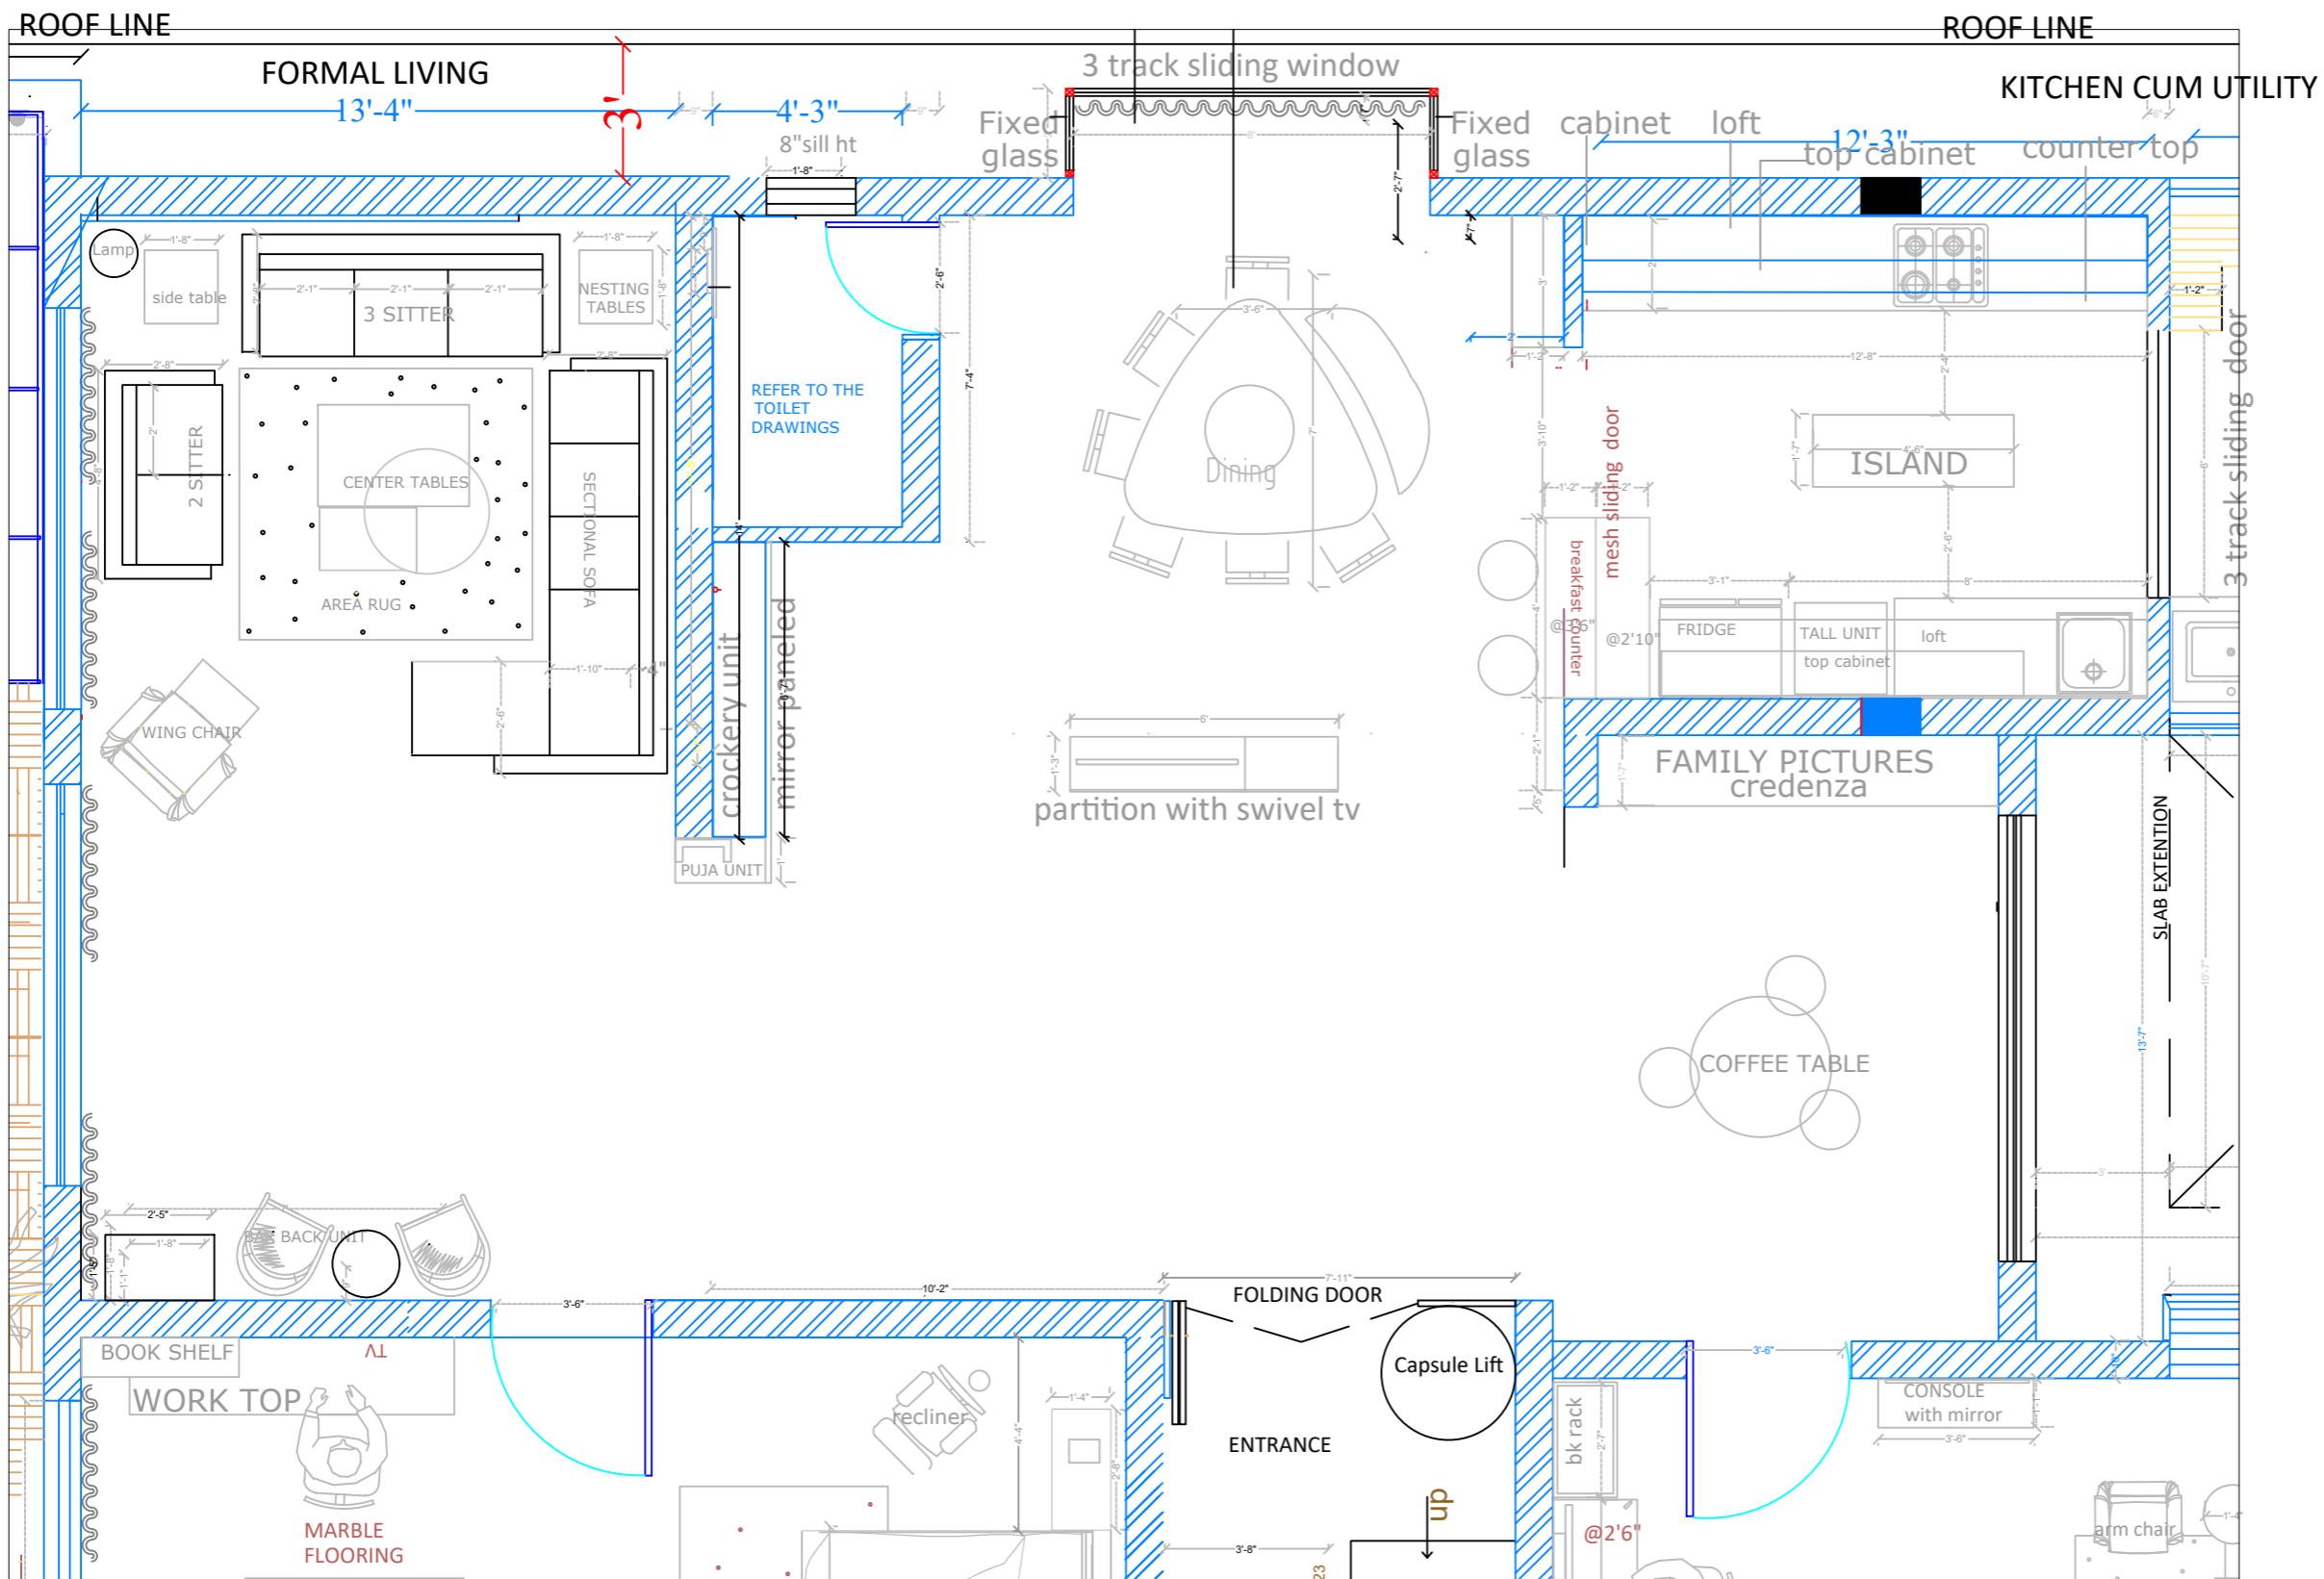

NOTES

1. THIS DRAWING IS THE PROPERTY OF **Builders and Designers (A Unit of MAESTER (R))**, AND SHALL NOT BE COPIED OR USED WITHOUT PRIOR PERMISSION.
2. THE DRAWING IS NOT TO THE SCALE. ONLY WRITTEN DIMENSION SHALL BE FOLLOWED.
3. ALL DIMENSIONS ARE IN MM.

TITLE

FORMAL LIVING, KITCHEN CUM UTILITY, Dining.


SCALE: NTS

CLIENT:- Tulsyan Family

DATE OF ISSUE: 21.04.2026

REVISIONS SHEET A3

SN	REVISION NO	DATE
01	R0	21-04-2026
02		
03		

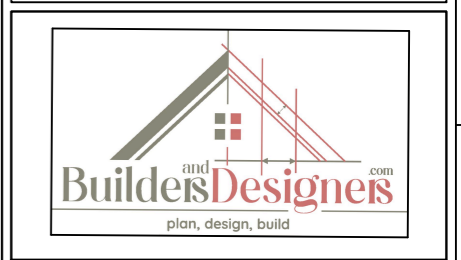


DESIGN BY TABREZ

DRAWN BY TAHER

CHECKED BY TABREZ

DRAWING NO RWSH-12

ALL DIMENSIONS ARE IN FT

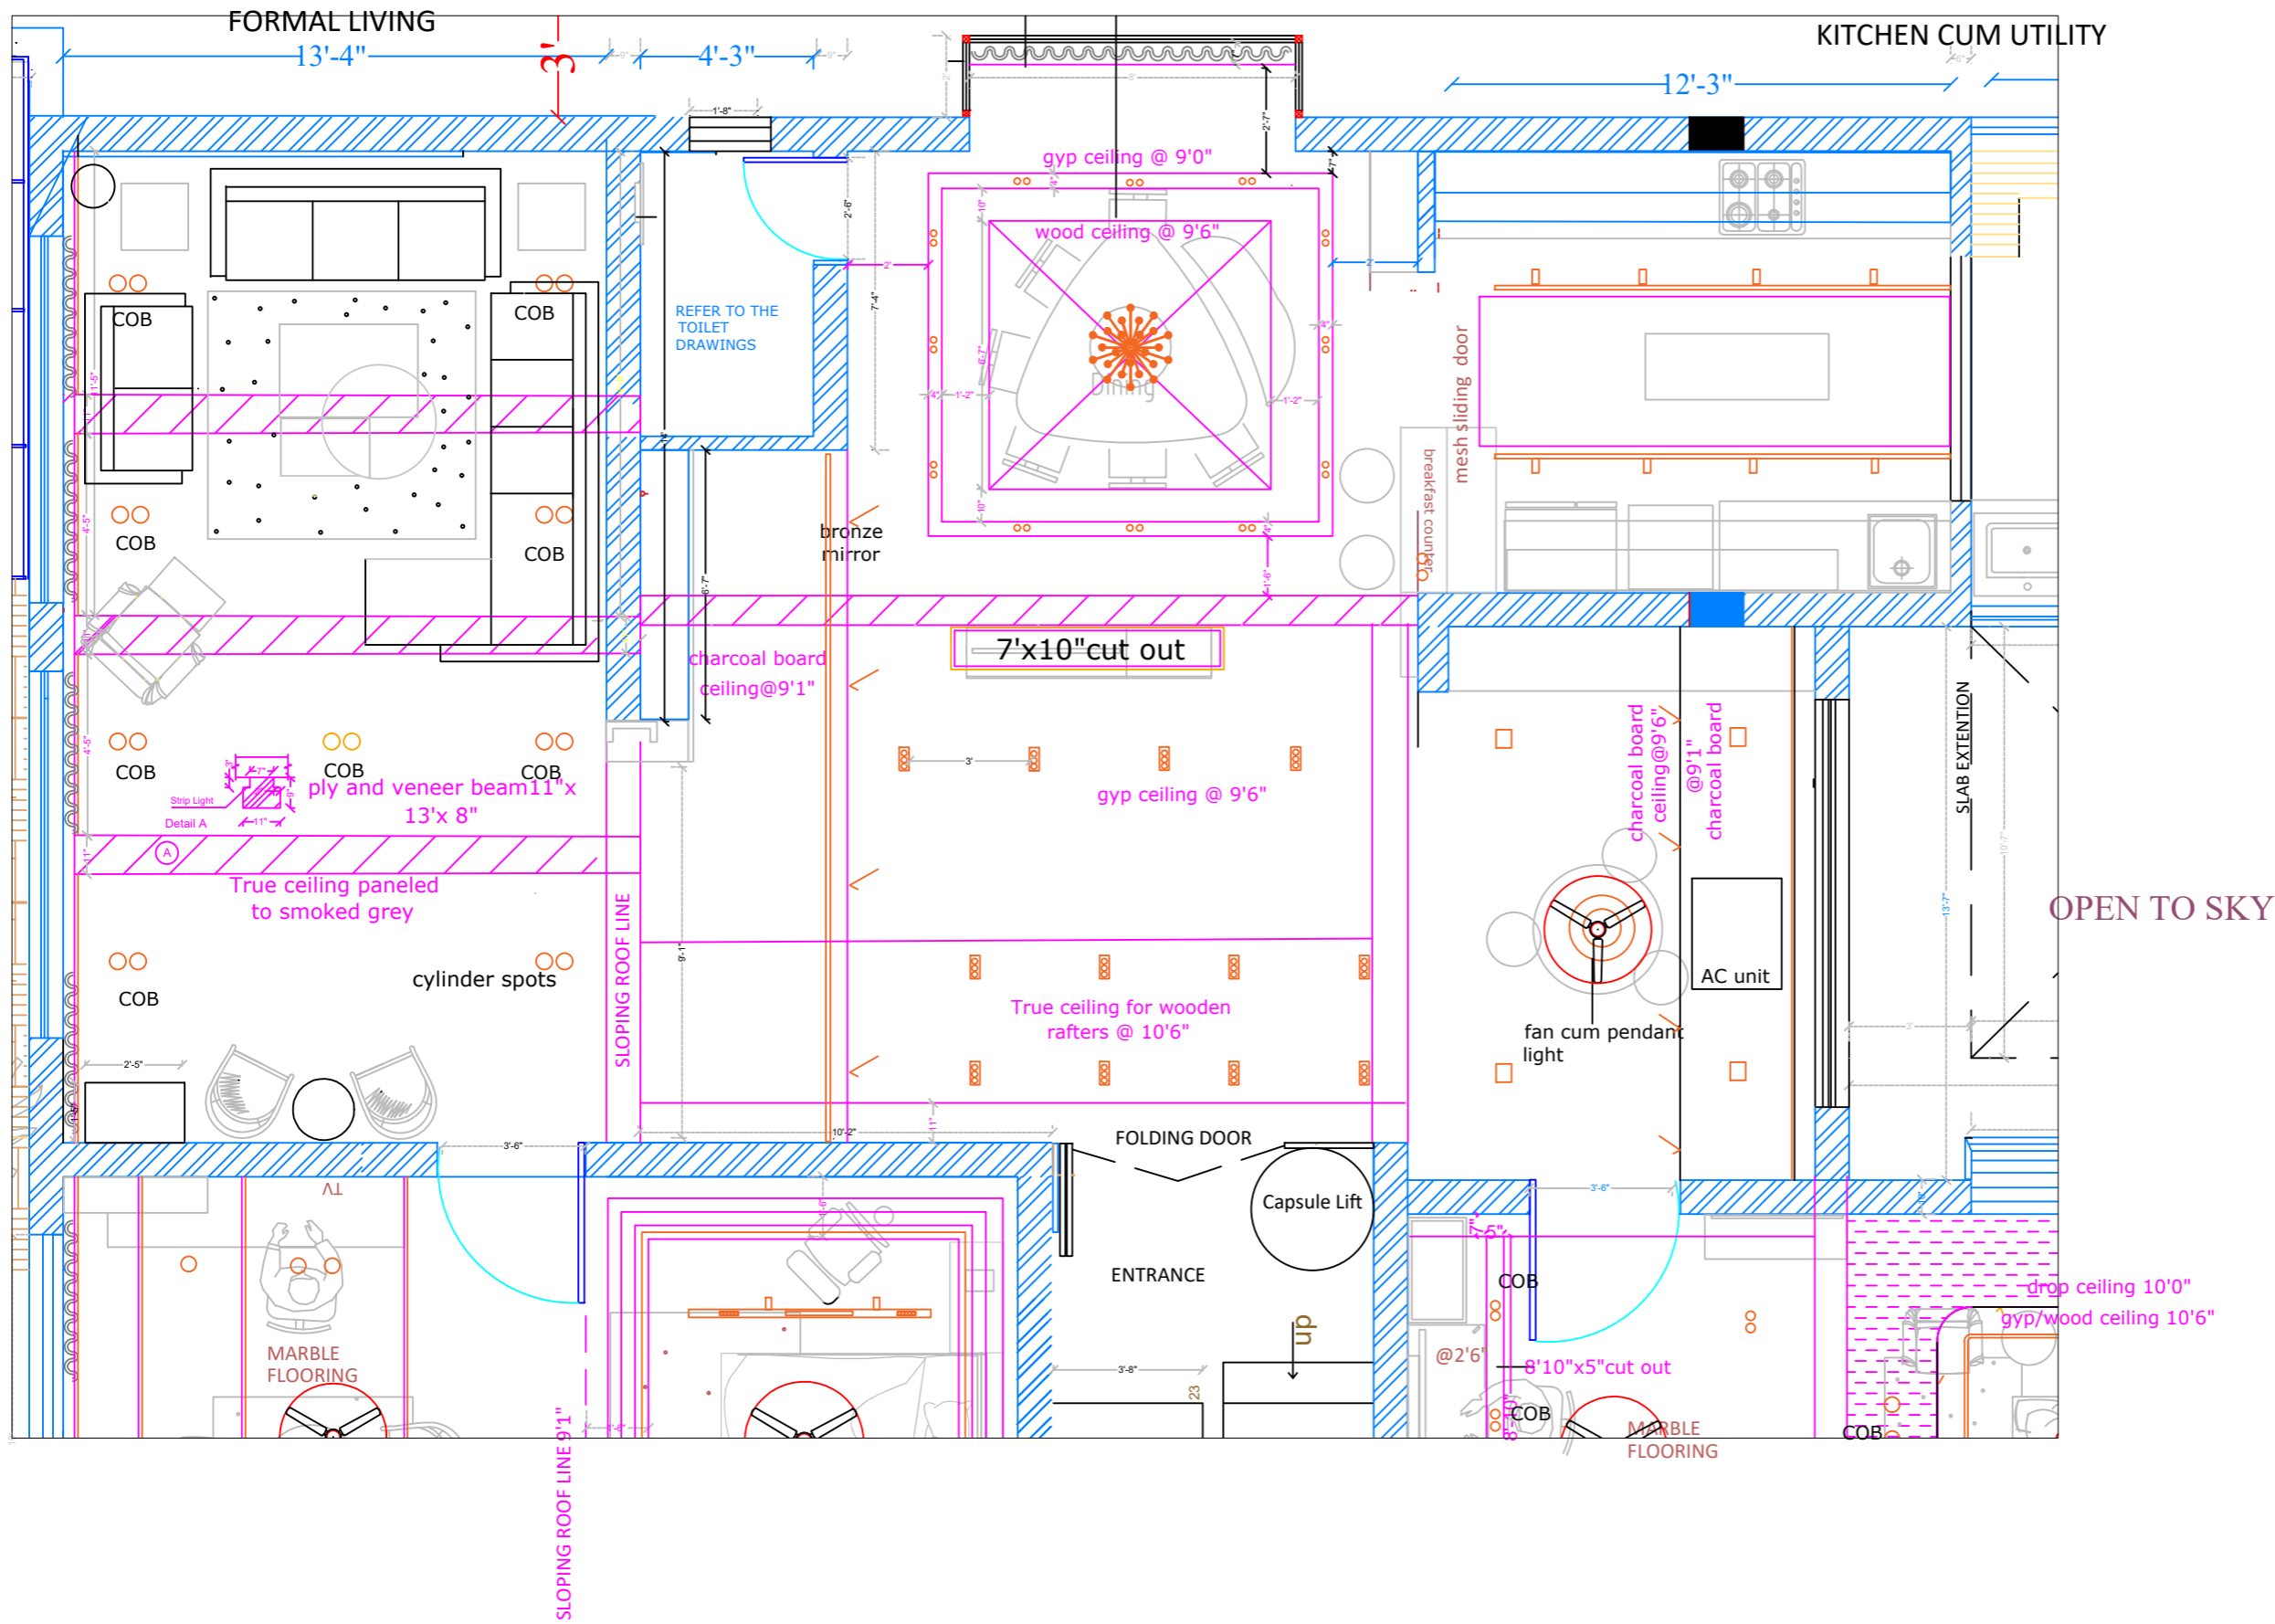

NOTES

1. THIS DRAWING IS THE PROPERTY OF **Builders and Designers (A Unit of MAESTER (R))**, AND SHALL NOT BE COPIED OR USED WITHOUT PRIOR PERMISSION.
2. THE DRAWING IS NOT TO THE SCALE. ONLY WRITTEN DIMENSION SHALL BE FOLLOWED.
3. ALL DIMENSIONS ARE IN MM.

TITLE

FORMAL LIVING, KITCHEN CUM UTILITY, Dining Ceiling Plan

SCALE: NTS

CLIENT:- Tulsayan Family

DATE OF ISSUE: 21.04.2026

REVISIONS SHEET A3

SN	REVISION NO	DATE
01	R0	21-04-2026
02		
03		




DESIGN BY TABREZ

DRAWN BY TAHER

CHECKED BY TABREZ

DRAWING NO RWSH-12

ALL DIMENSIONS ARE IN FT

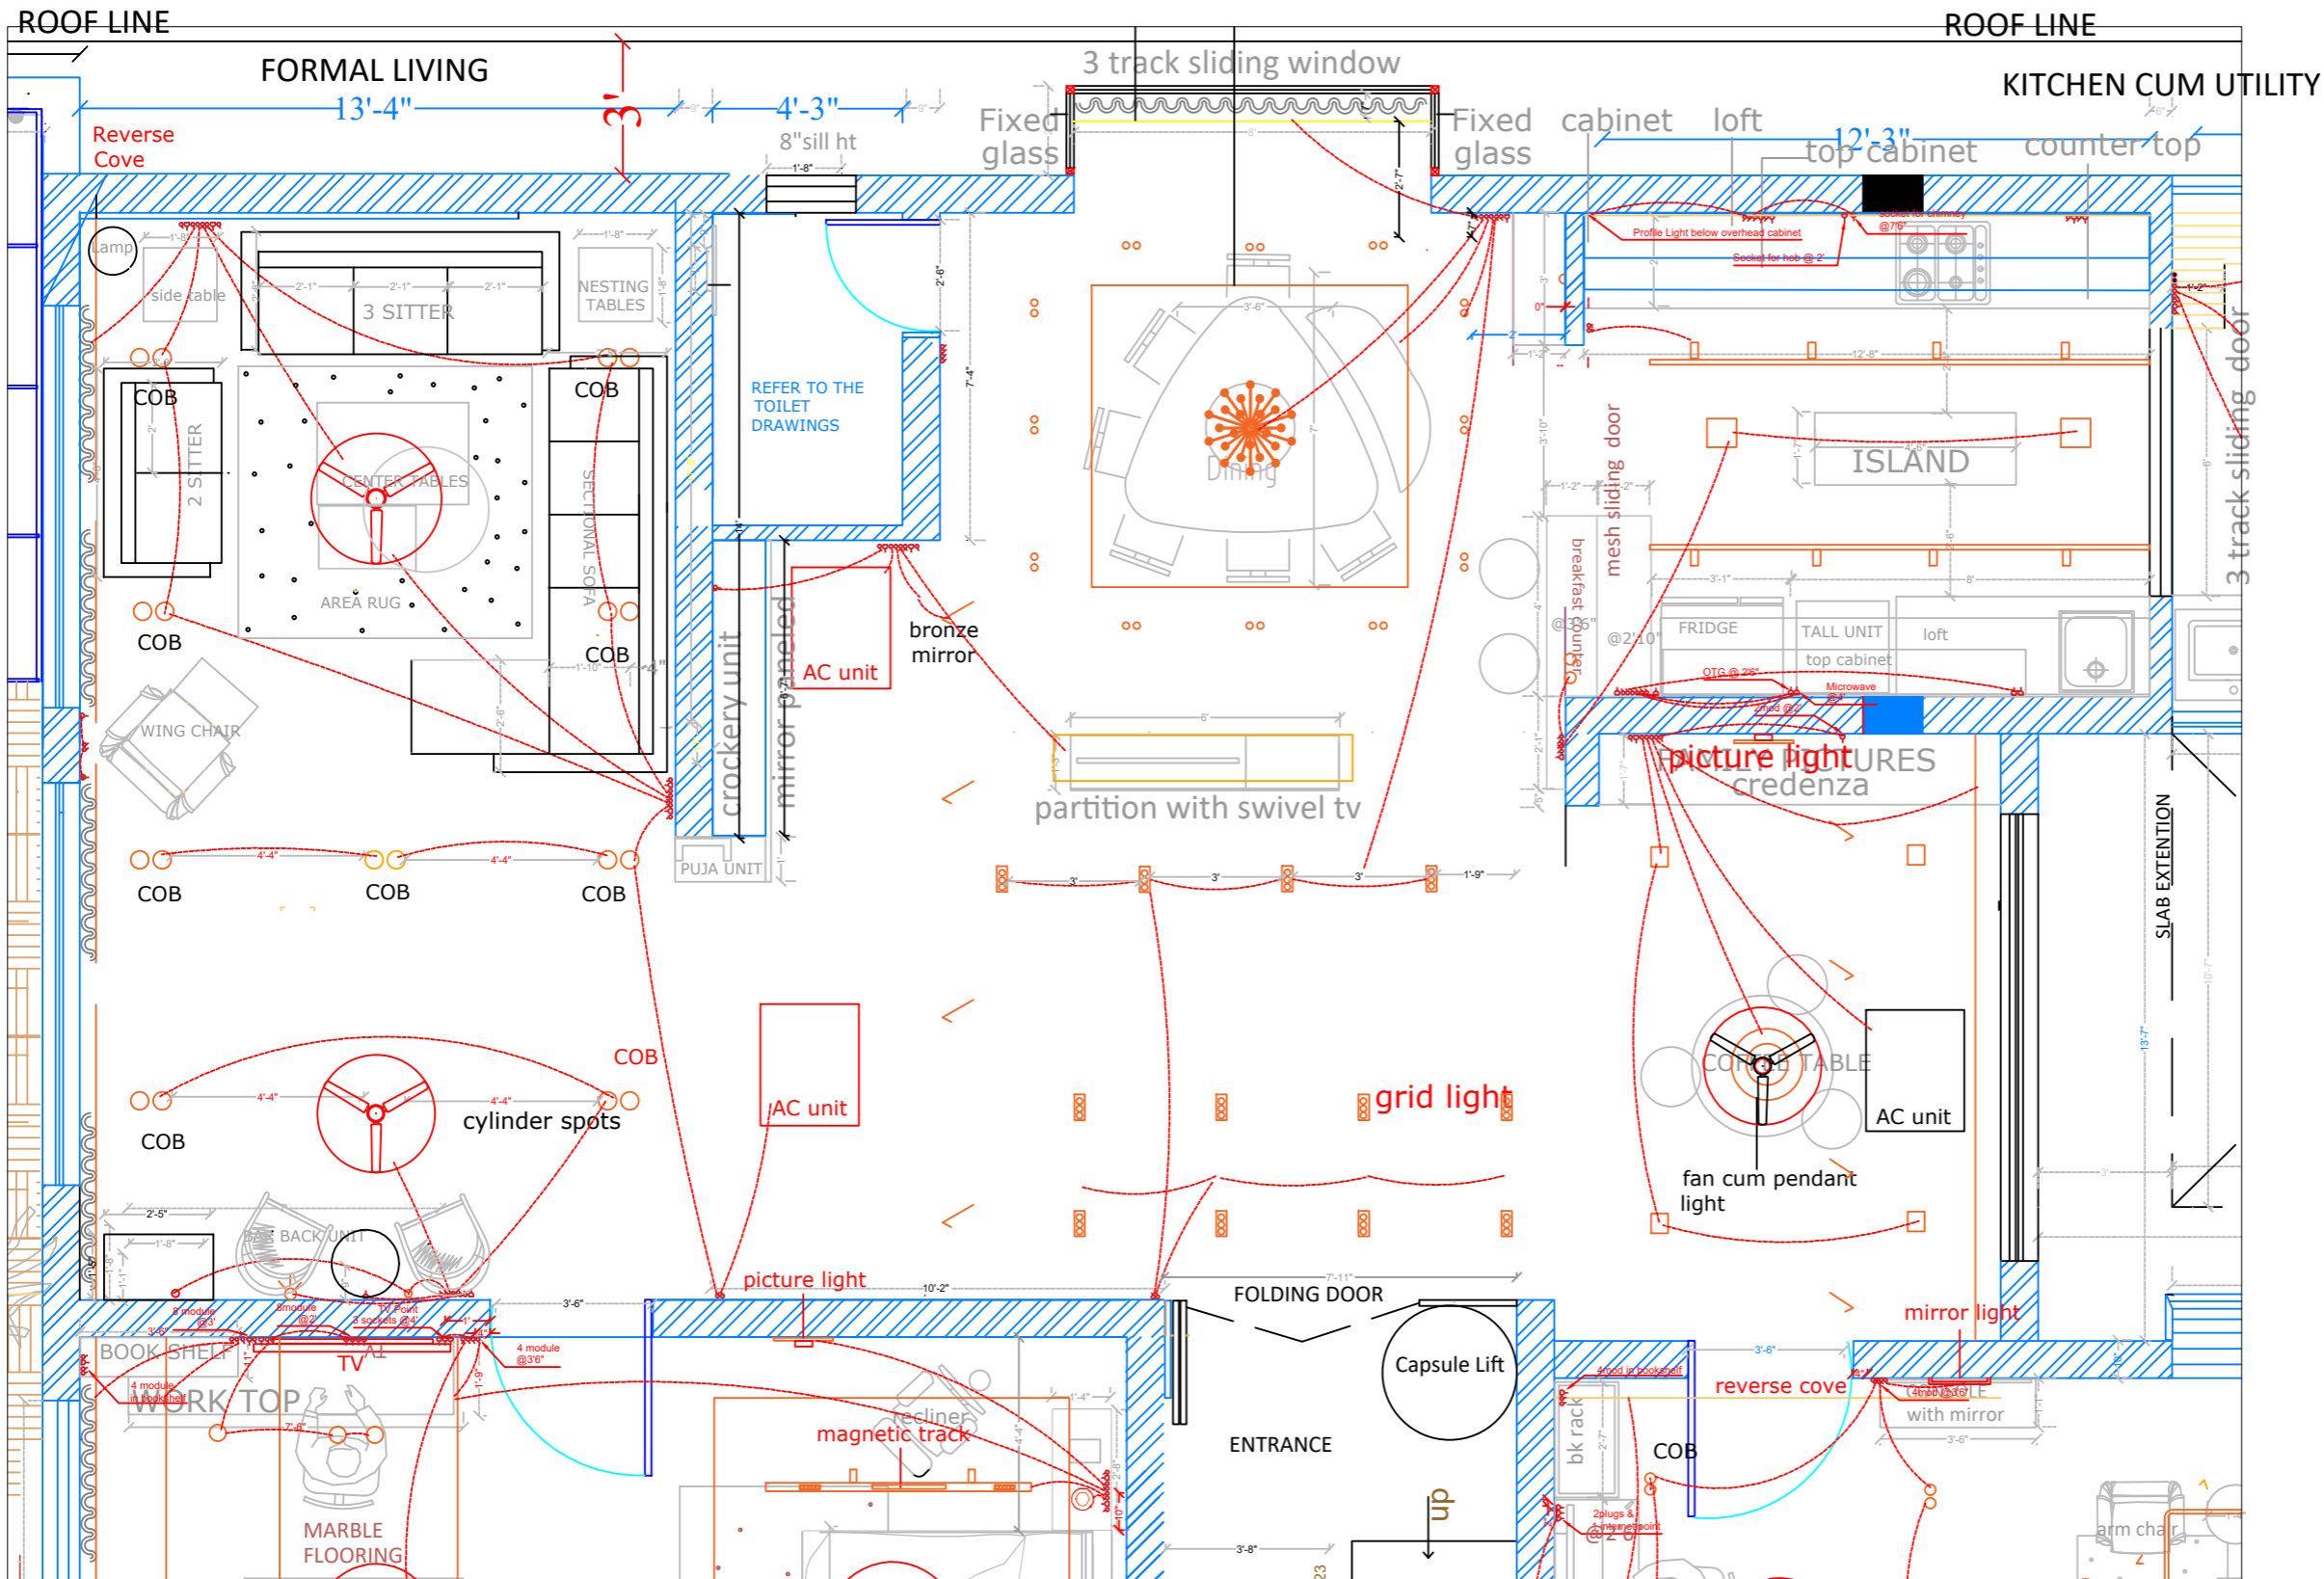

NOTES

 
1. THIS DRAWING IS THE PROPERTY OF **Builders and Designers (A Unit of MAESTER (R))**, AND SHALL NOT BE COPIED OR USED WITHOUT PRIOR PERMISSION.
2. THE DRAWING IS NOT TO THE SCALE. ONLY WRITTEN DIMENSION SHALL BE FOLLOWED.
3. ALL DIMENSIONS ARE IN MM.

TITLE

FORMAL LIVING, KITCHEN CUM UTILITY, Dining-Electrical Layout

SCALE: NTS

CLIENT:-
Tulsiyan Family



DATE OF ISSUE: 21.04.2026

REVISIONS

SHEET
A3

SN	REVISION NO	DATE
01	R0	21-04-2026
02		
03		



DESIGN BY TABREZ





DRAWN BY TAHER

CHECKED BY TABREZ

DRAWING NO RWSH-12

ALL DIMENSIONS ARE IN FT

Powder Toilet Elevations

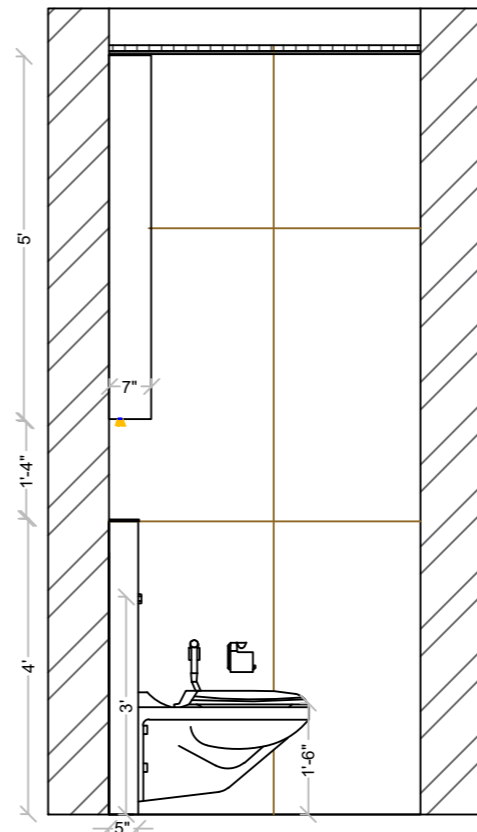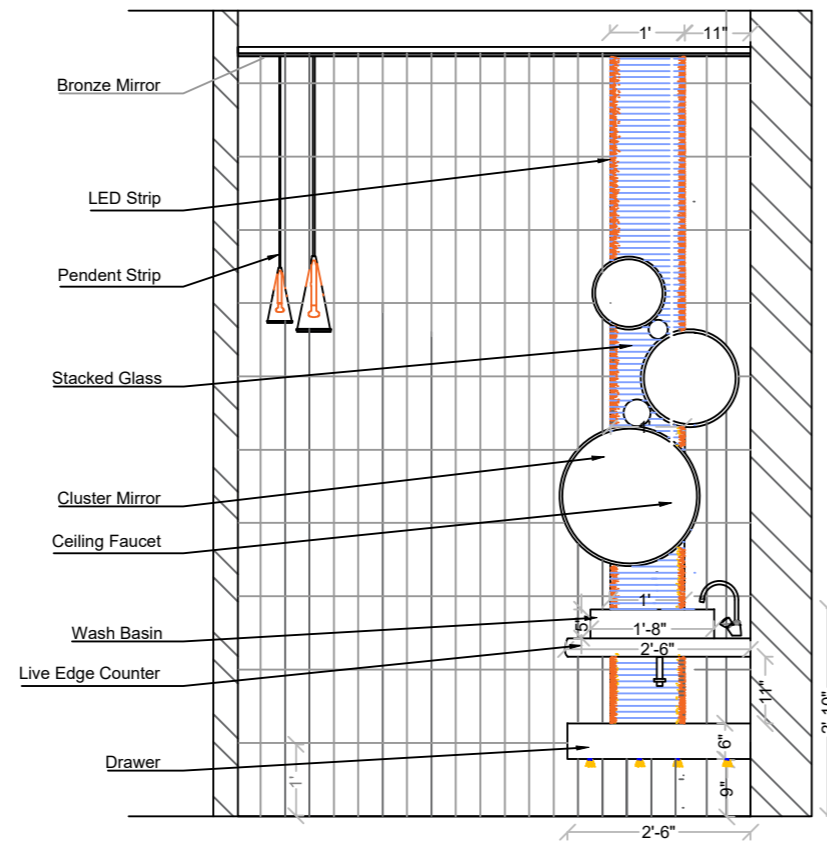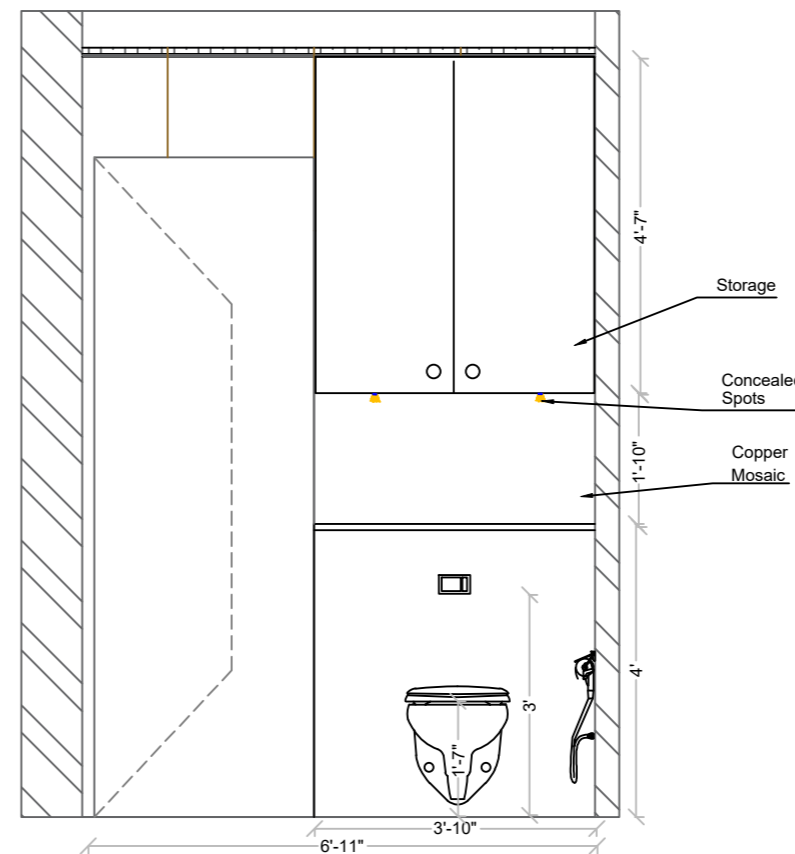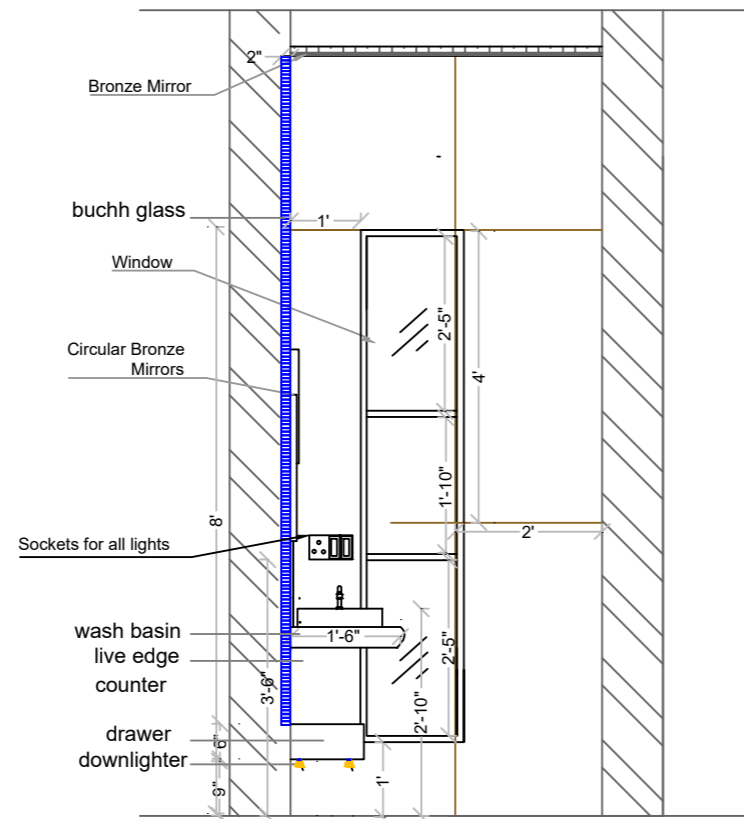

NOTES

1. THIS DRAWING IS THE PROPERTY OF **Builders and Designers (A Unit of MAESTER (R))**, AND SHELL NOT BE COPIED OR USED WITHOUT PRIOR PERMISSION.
2. THE DRAWING IS NOT TO THE SCALE. ONLY WRITTEN DIMENSION SHALL BE FOLLOWED.
3. ALL DIMENSIONS ARE IN MM.

TITLE

Powder Toilet Elevations

SCALE: NTS

CLIENT:-
Tulsiyan Family

DATE OF ISSUE: 21.04.2026

REVISIONS SHEET A3

SN	REVISION NO	DATE
01	R0	21-04-2026
02		
03		



DESIGN BY TABREZ


DRAWN BY TAHER

CHECKED BY TABREZ

DRAWING NO RWSH-12

ALL DIMENSIONS ARE IN FT

Living, TV partition

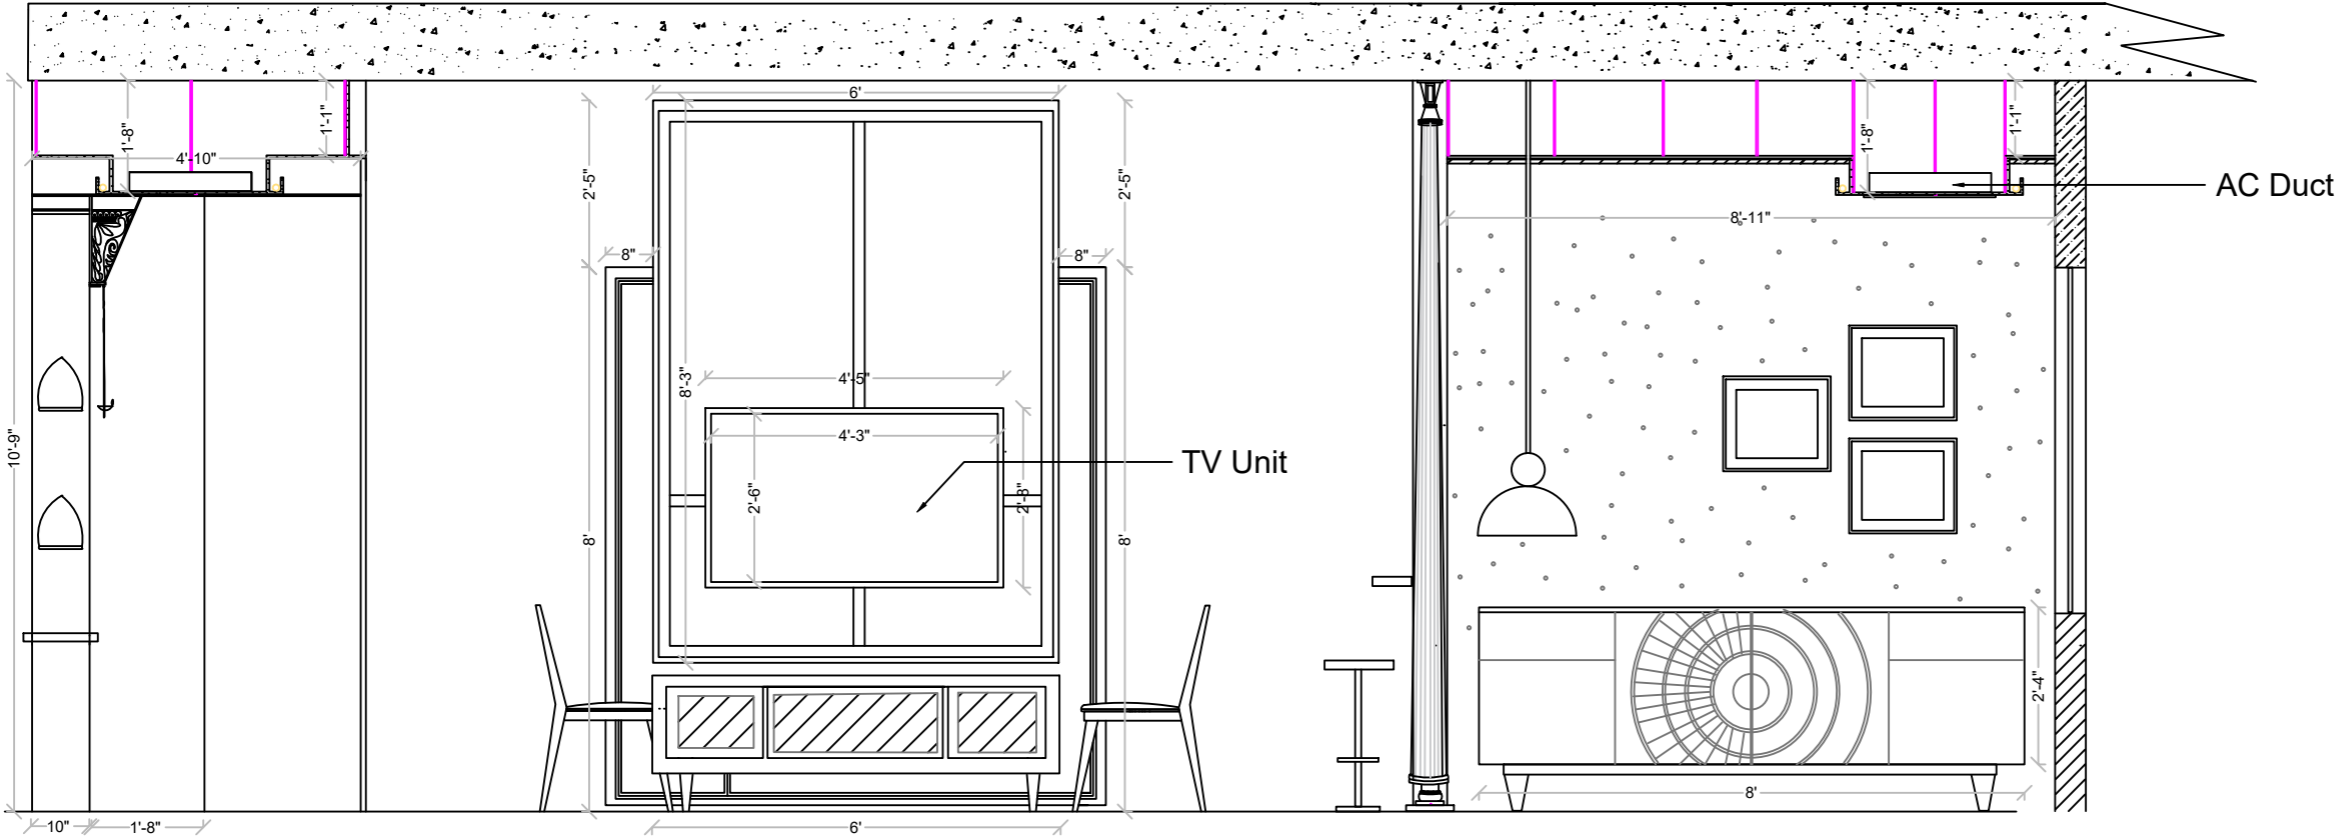

NOTES

 
1. THIS DRAWING IS THE PROPERTY OF **Builders and Designers (A Unit of MAESTER (R))**, AND SHELL NOT BE COPIED OR USED WITHOUT PRIOR PERMISSION.
2. THE DRAWING IS NOT TO THE SCALE. ONLY WRITTEN DIMENSION SHALL BE FOLLOWED.
3. ALL DIMENSIONS ARE IN MM.

TITLE

Living, TV partition

SCALE: NTS

CLIENT:-
Tulsiyan Family




DATE OF ISSUE: 21.04.2026

REVISIONS

SHEET
A3

SN	REVISION NO	DATE
01	R0	21-04-2026
02		
03		

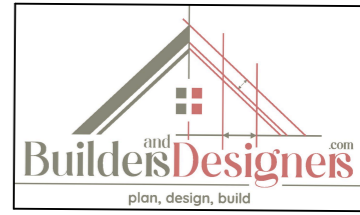

DESIGN BY TABREZ


DRAWN BY TAHER

CHECKED BY TABREZ

DRAWING NO RWSH-12

ALL DIMENSIONS ARE IN FT

Picture window

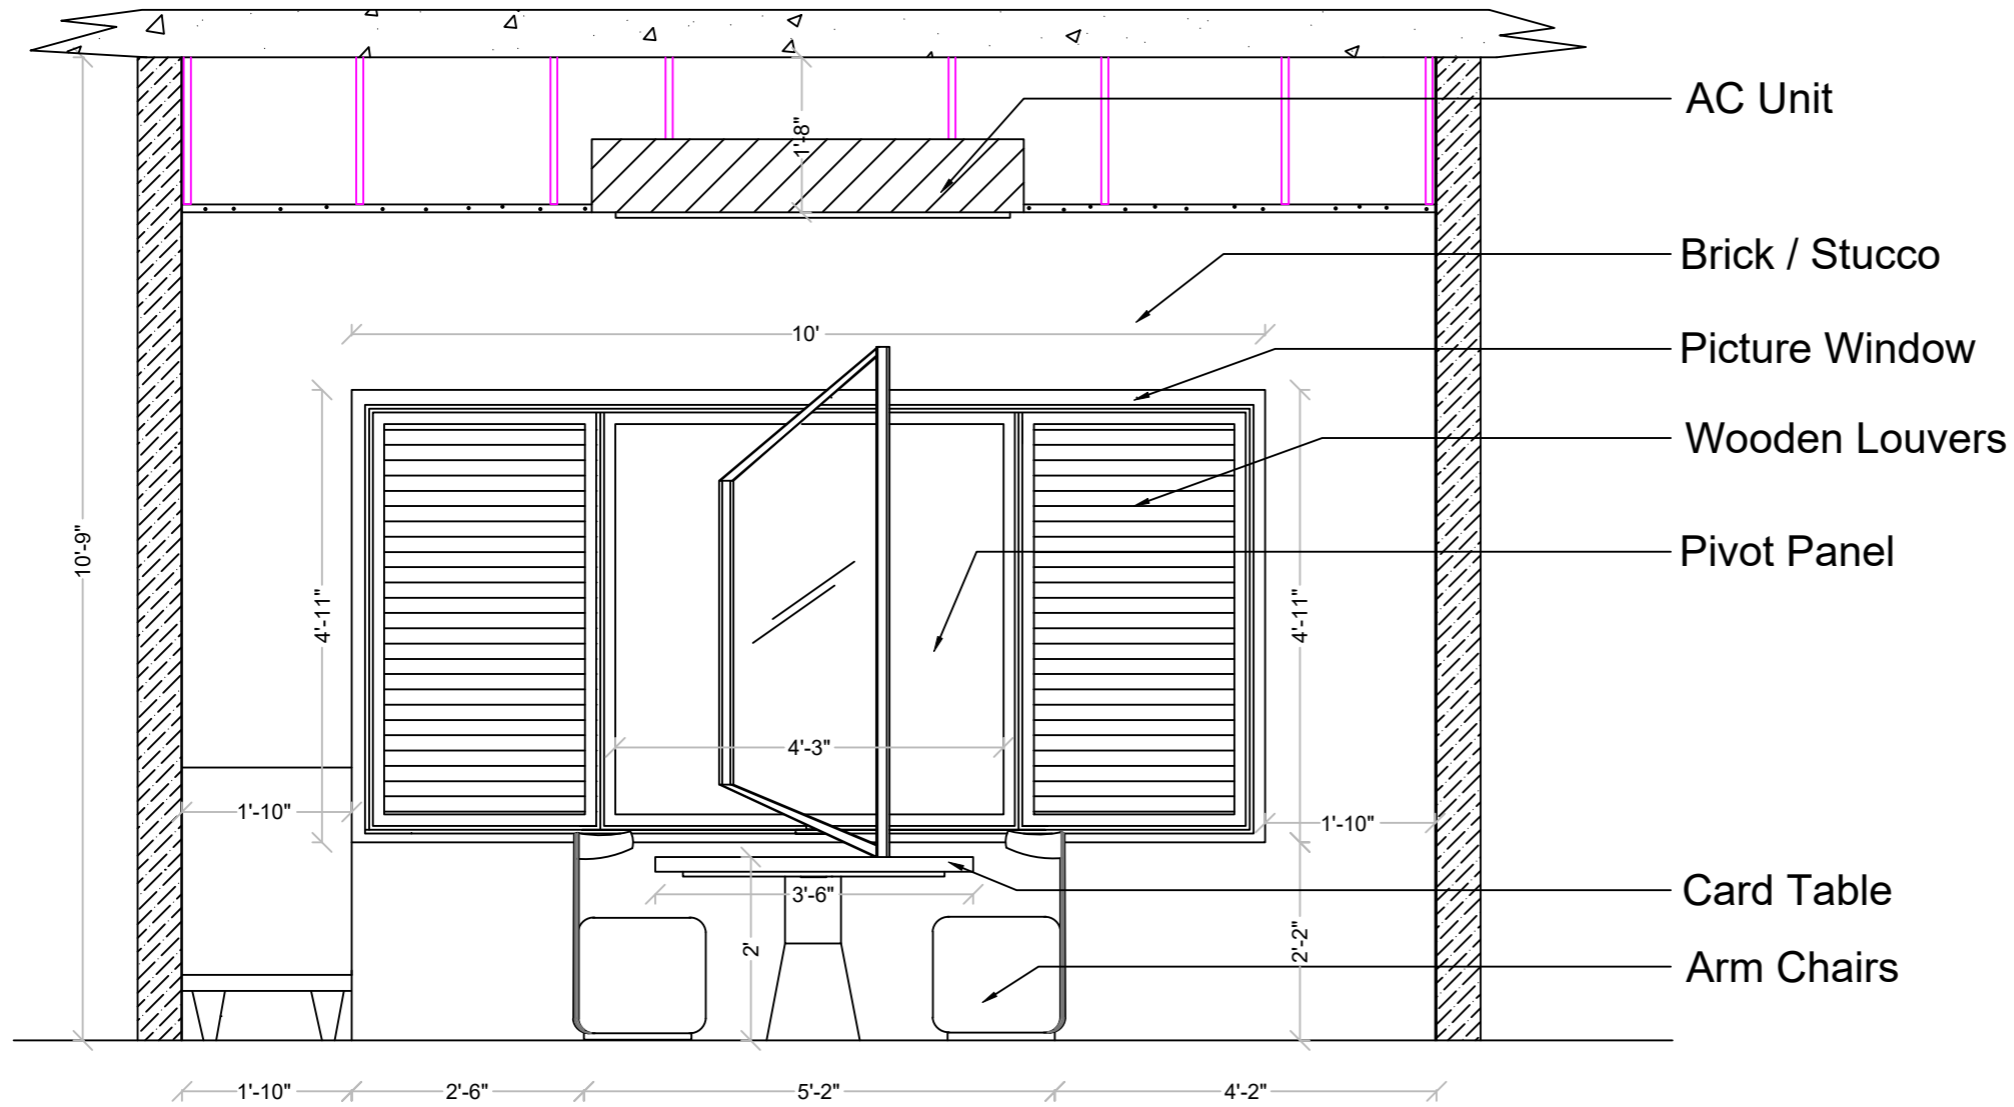

NOTES

 
1. THIS DRAWING IS THE PROPERTY OF **Builders and Designers (A Unit of MAESTER (R))**, AND SHALL NOT BE COPIED OR USED WITHOUT PRIOR PERMISSION.
2. THE DRAWING IS NOT TO THE SCALE. ONLY WRITTEN DIMENSION SHALL BE FOLLOWED.
3. ALL DIMENSIONS ARE IN MM.

TITLE

Picture window

SCALE: NTS

CLIENT:-
Tulsiyan Family




DATE OF ISSUE: 21.04.2026

REVISIONS

SHEET
A3

SN	REVISION NO	DATE
01	R0	21-04-2026
02		
03		

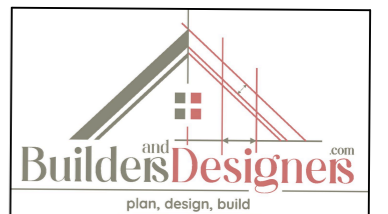


DESIGN BY TABREZ

DRAWN BY TAHER


CHECKED BY TABREZ

DRAWING NO RWSH-12

ALL DIMENSIONS ARE IN FT

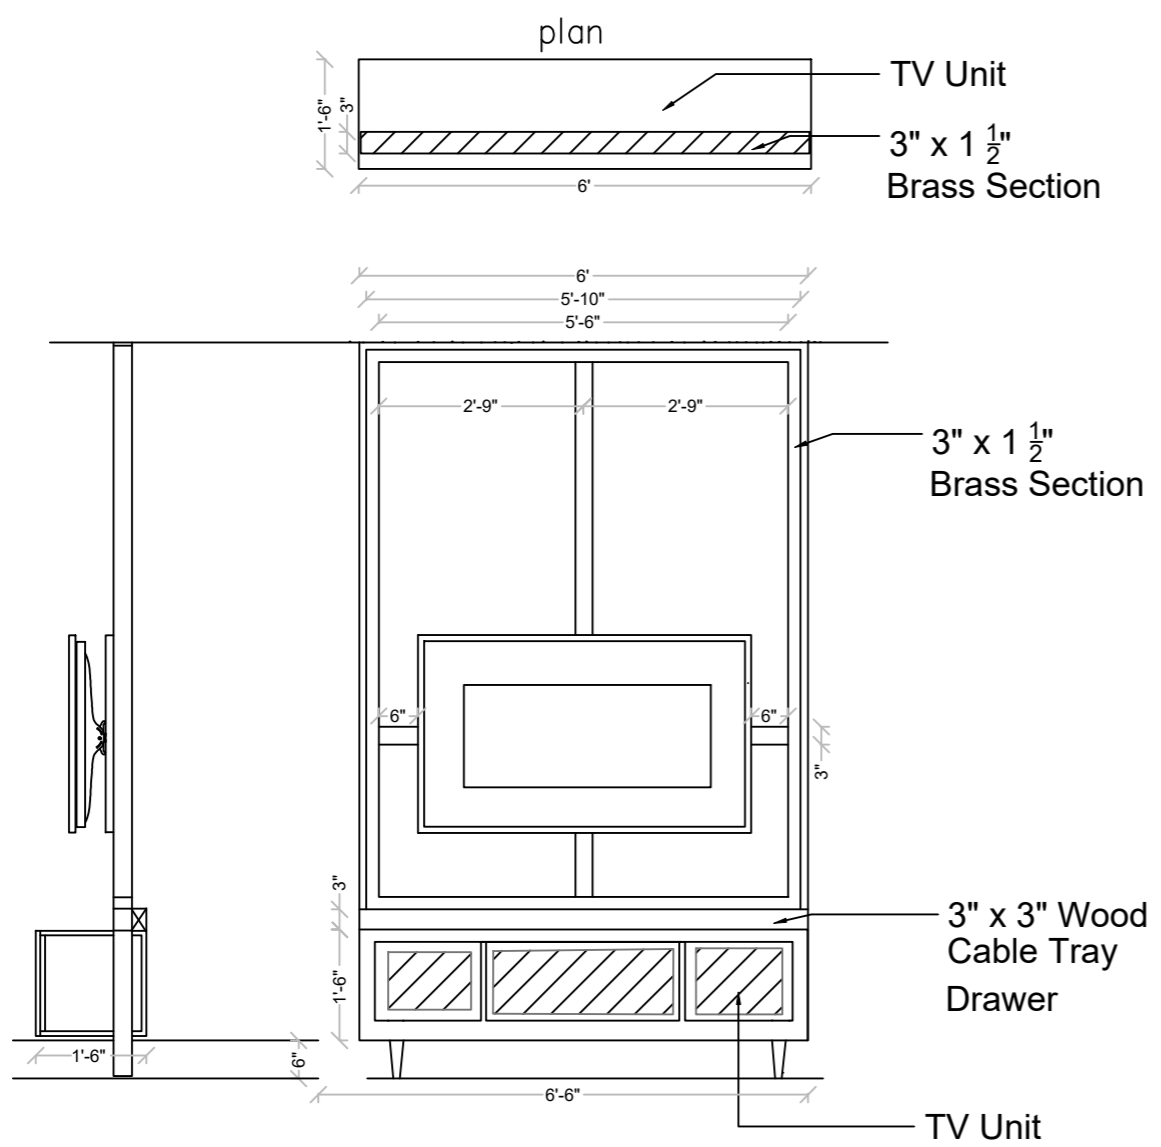

TV Unit , Hallway side

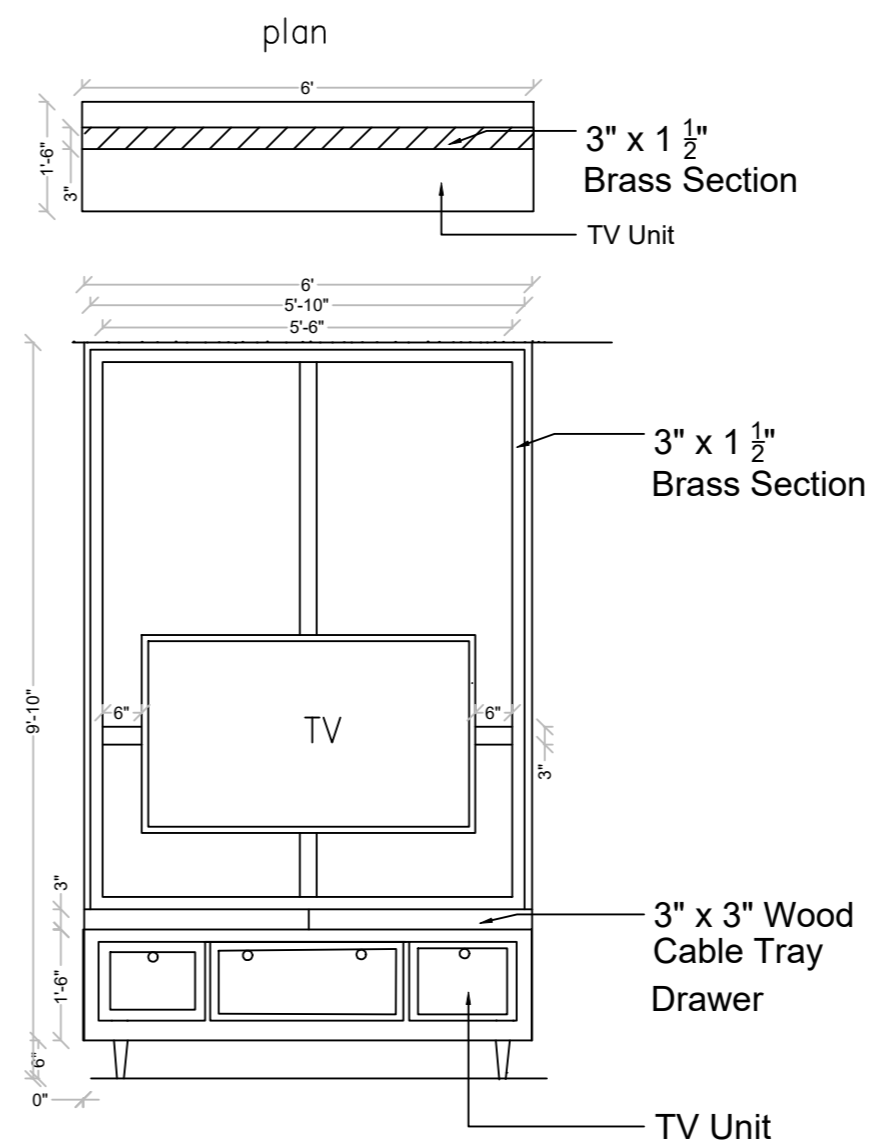

TV Unit , Dining side

NOTES

1. THIS DRAWING IS THE PROPERTY OF **Builders and Designers (A Unit of MAESTER (R))**, AND SHELL NOT BE COPIED OR USED WITHOUT PRIOR PERMISSION.
2. THE DRAWING IS NOT TO THE SCALE. ONLY WRITTEN DIMENSION SHALL BE FOLLOWED.
3. ALL DIMENSIONS ARE IN MM.

TITLE

TV Unit Elevation


SCALE: NTS

CLIENT:-
Tulsiyan Family



DATE OF ISSUE: 21.04.2026

REVISIONS		
SN	REVISION NO	DATE
01	R0	21-04-2026
02		
03		

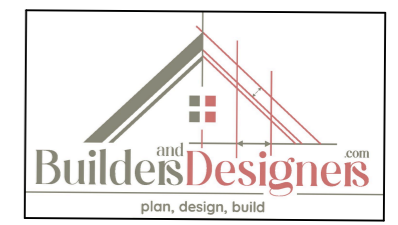


DESIGN BY TABREZ

DRAWN BY TAHER

CHECKED BY TABREZ

DRAWING NO RWSH-12

Crockery Unit , coffee area

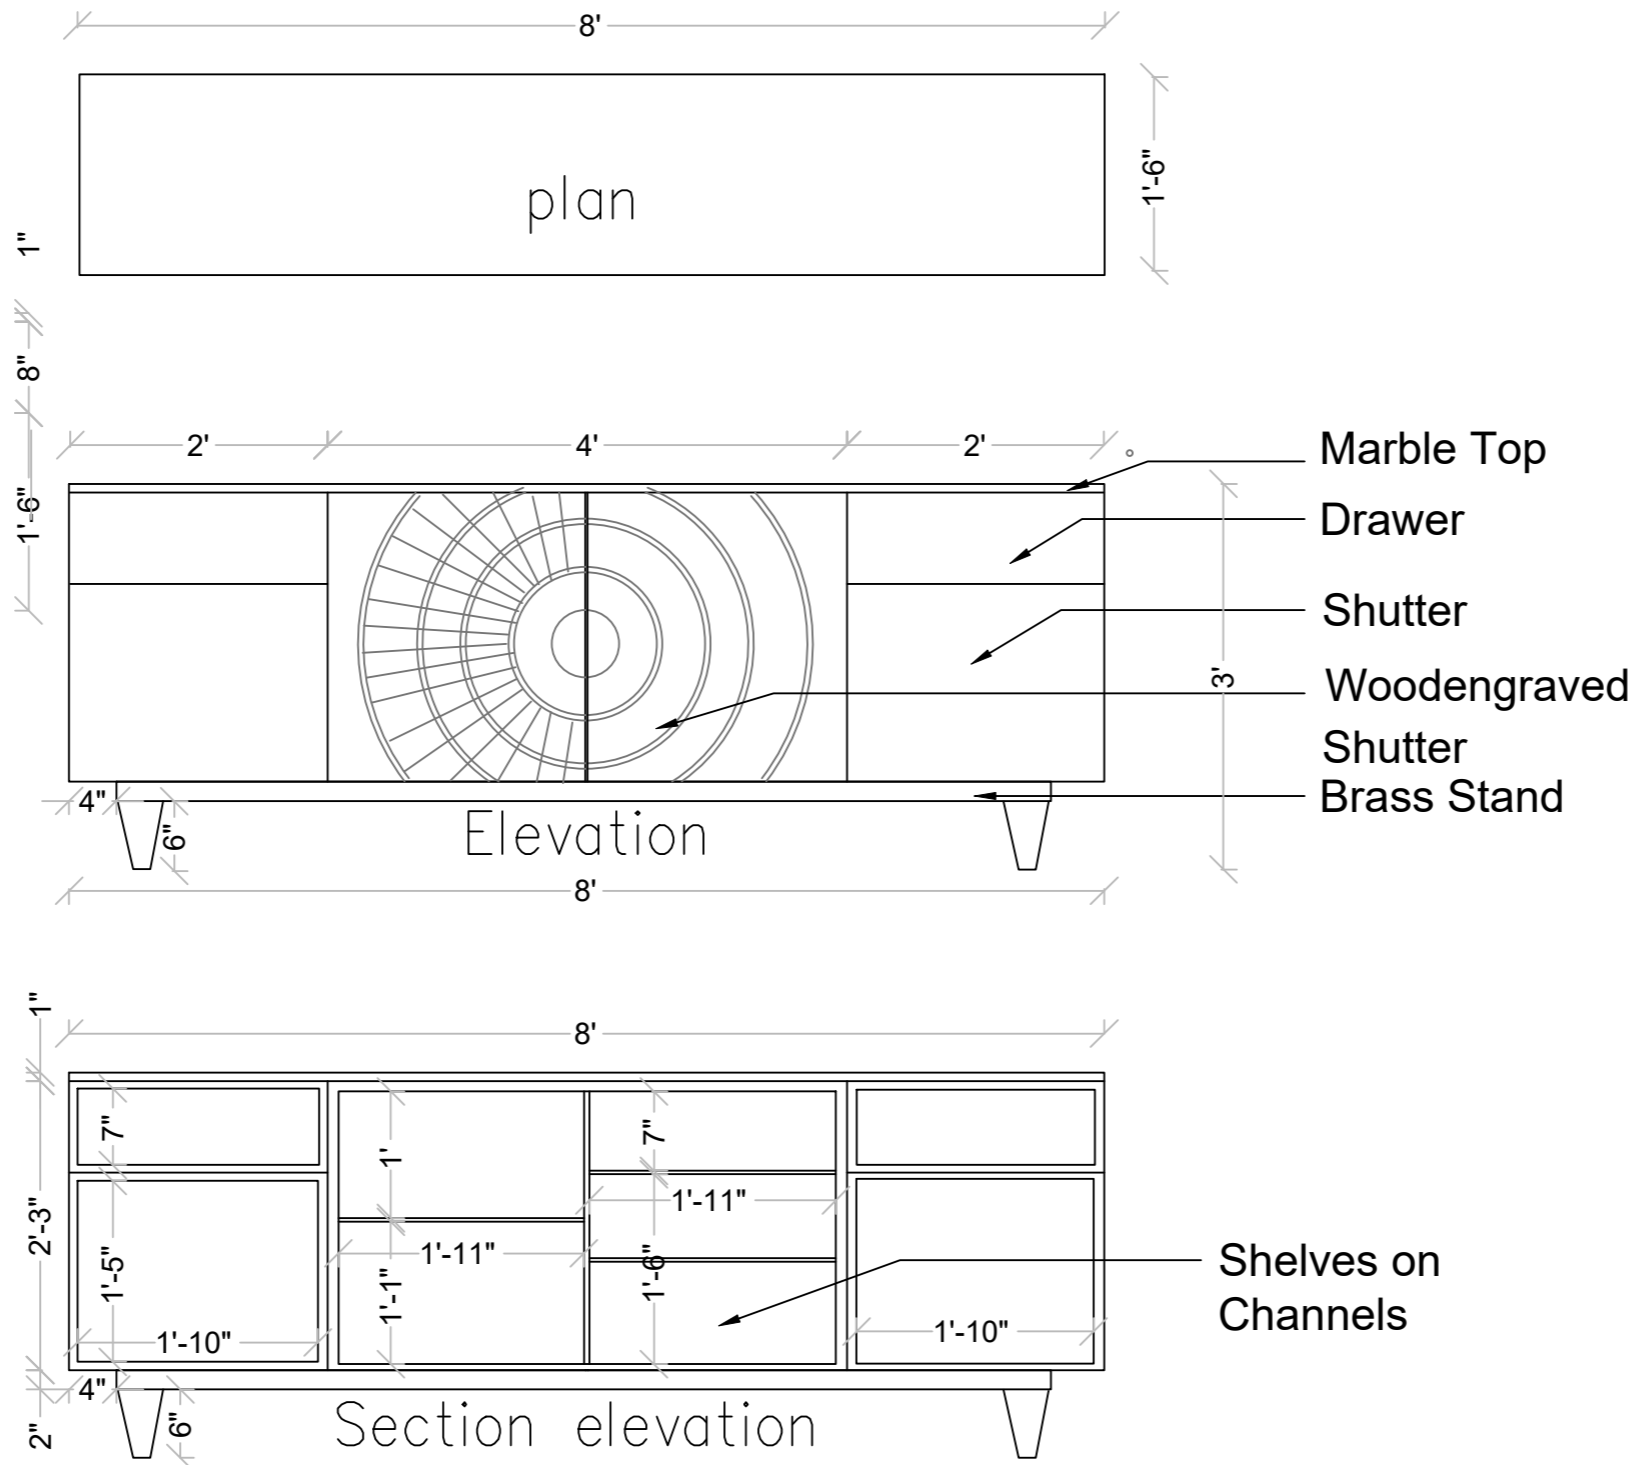

NOTES

1. THIS DRAWING IS THE PROPERTY OF **Builders and Designers (A Unit of MAESTER (R))**, AND SHALL NOT BE COPIED OR USED WITHOUT PRIOR PERMISSION.
2. THE DRAWING IS NOT TO THE SCALE. ONLY WRITTEN DIMENSION SHALL BE FOLLOWED.
3. ALL DIMENSIONS ARE IN MM.

TITLE

Crockery Unit & coffee area

SCALE: NTS

CLIENT:-
Tulsiyan Family



DATE OF ISSUE: 21.04.2026

REVISIONS

SHEET
A3

SN	REVISION NO	DATE
01	R0	21-04-2026
02		
03		



DESIGN BY TABREZ


DRAWN BY TAHER

CHECKED BY TABREZ


DRAWING NO RWSH-12

ALL DIMENSIONS ARE IN FT

Hallway Mirror cabinet,inside

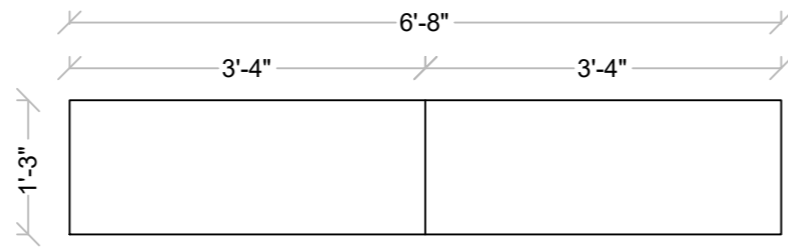

PLAN

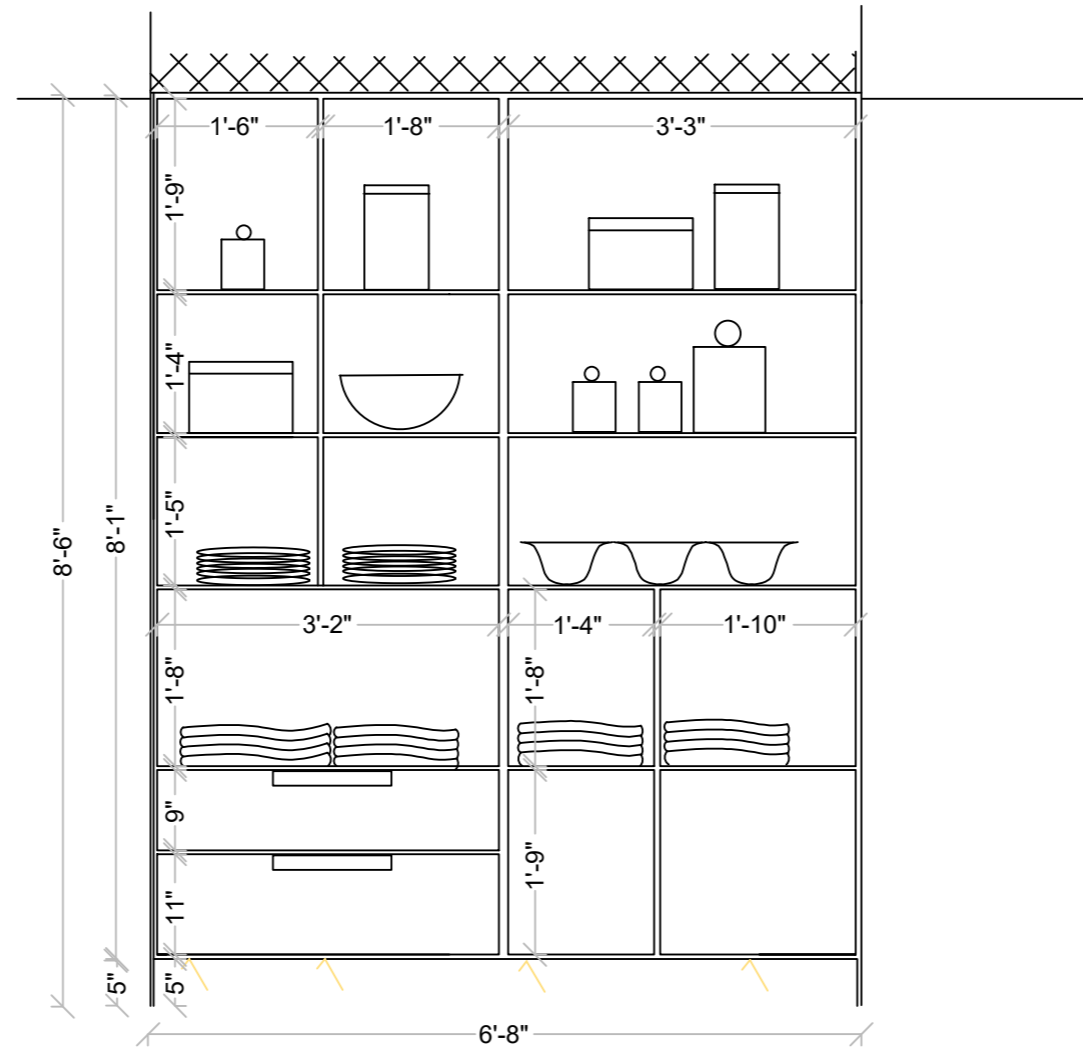

NOTES

 
1. THIS DRAWING IS THE PROPERTY OF **Builders and Designers (A Unit of MAESTER (R))**, AND SHELL NOT BE COPIED OR USED WITHOUT PRIOR PERMISSION.
2. THE DRAWING IS NOT TO THE SCALE. ONLY WRITTEN DIMENSION SHALL BE FOLLOWED.
3. ALL DIMENSIONS ARE IN MM.

TITLE

Hallway Wall cabinet inside

SCALE: NTS

CLIENT:-
Tulsiyan Family




DATE OF ISSUE: 21.04.2026

REVISIONS

SHEET
A3

SN	REVISION NO	DATE
01	R0	21-04-2026
02		
03		

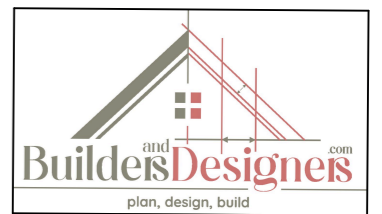

DESIGN BY TABREZ

DRAWN BY TAHER

CHECKED BY TABREZ


DRAWING NO RWSH-12

ALL DIMENSIONS ARE IN FT

Hallway Mirror wall


NOTES

1. THIS DRAWING IS THE PROPERTY OF **Builders and Designers (A Unit of MAESTER (R))**, AND SHALL NOT BE COPIED OR USED WITHOUT PRIOR PERMISSION.
2. THE DRAWING IS NOT TO THE SCALE. ONLY WRITTEN DIMENSION SHALL BE FOLLOWED.
3. ALL DIMENSIONS ARE IN MM.

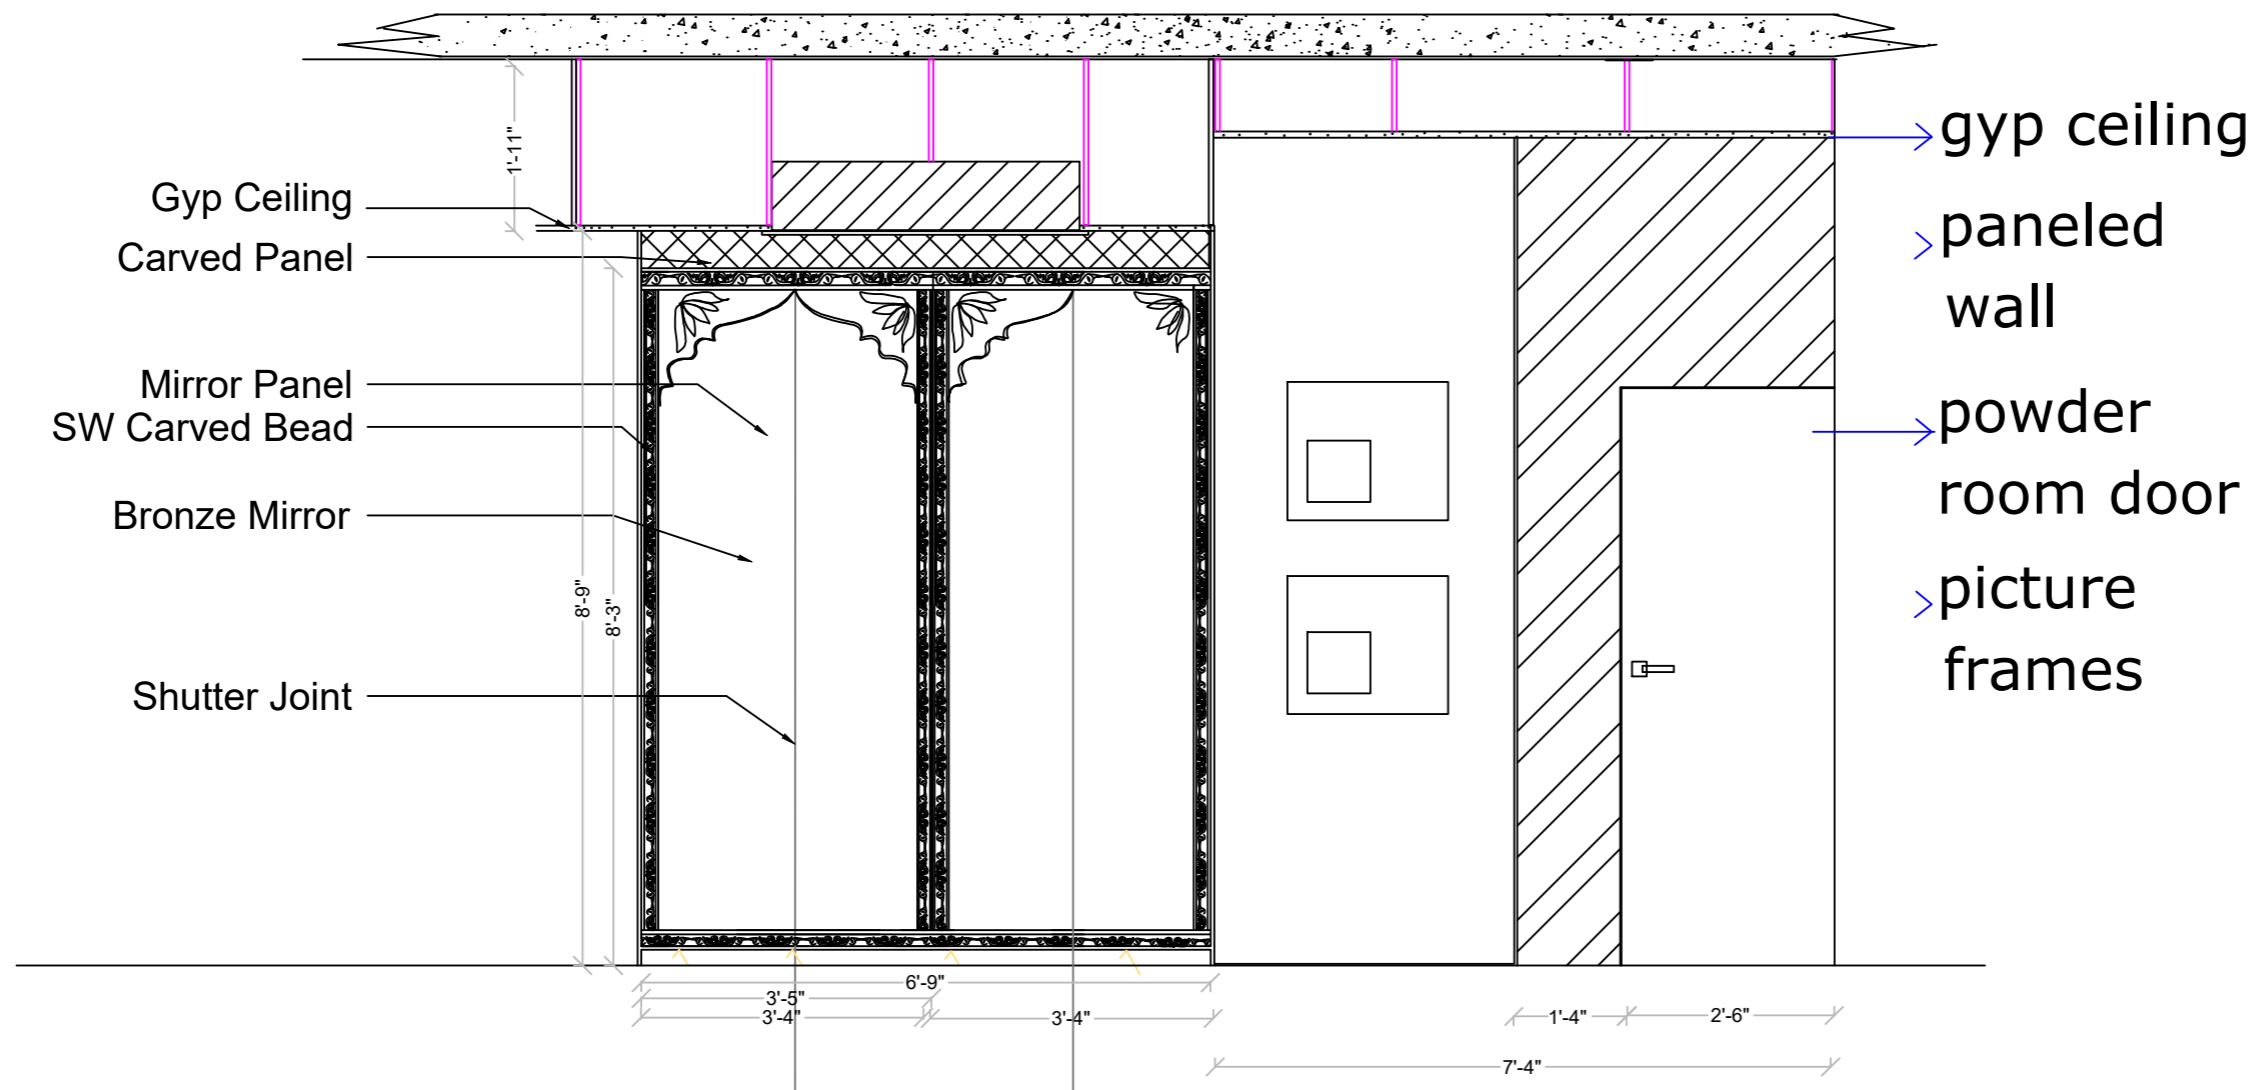

TITLE
 GROUND FLOOR
 BEAM
 REINFORCEMENT
 DETAILS


SCALE: NTS
 CLIENT:-
 Tulsian Family

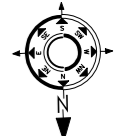

DATE OF ISSUE: 21.04.2026

REVISIONS SHEET A3


SN	REVISION NO	DATE
01	R0	21-04-2026
02		
03		

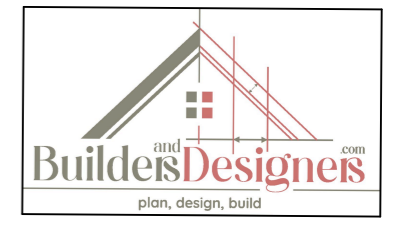

DESIGN BY TABREZ
 DRAWN BY TAHER
 CHECKED BY TABREZ
 DRAWING NO RWSH-12

ALL DIMENSIONS ARE IN FT

Dining Area

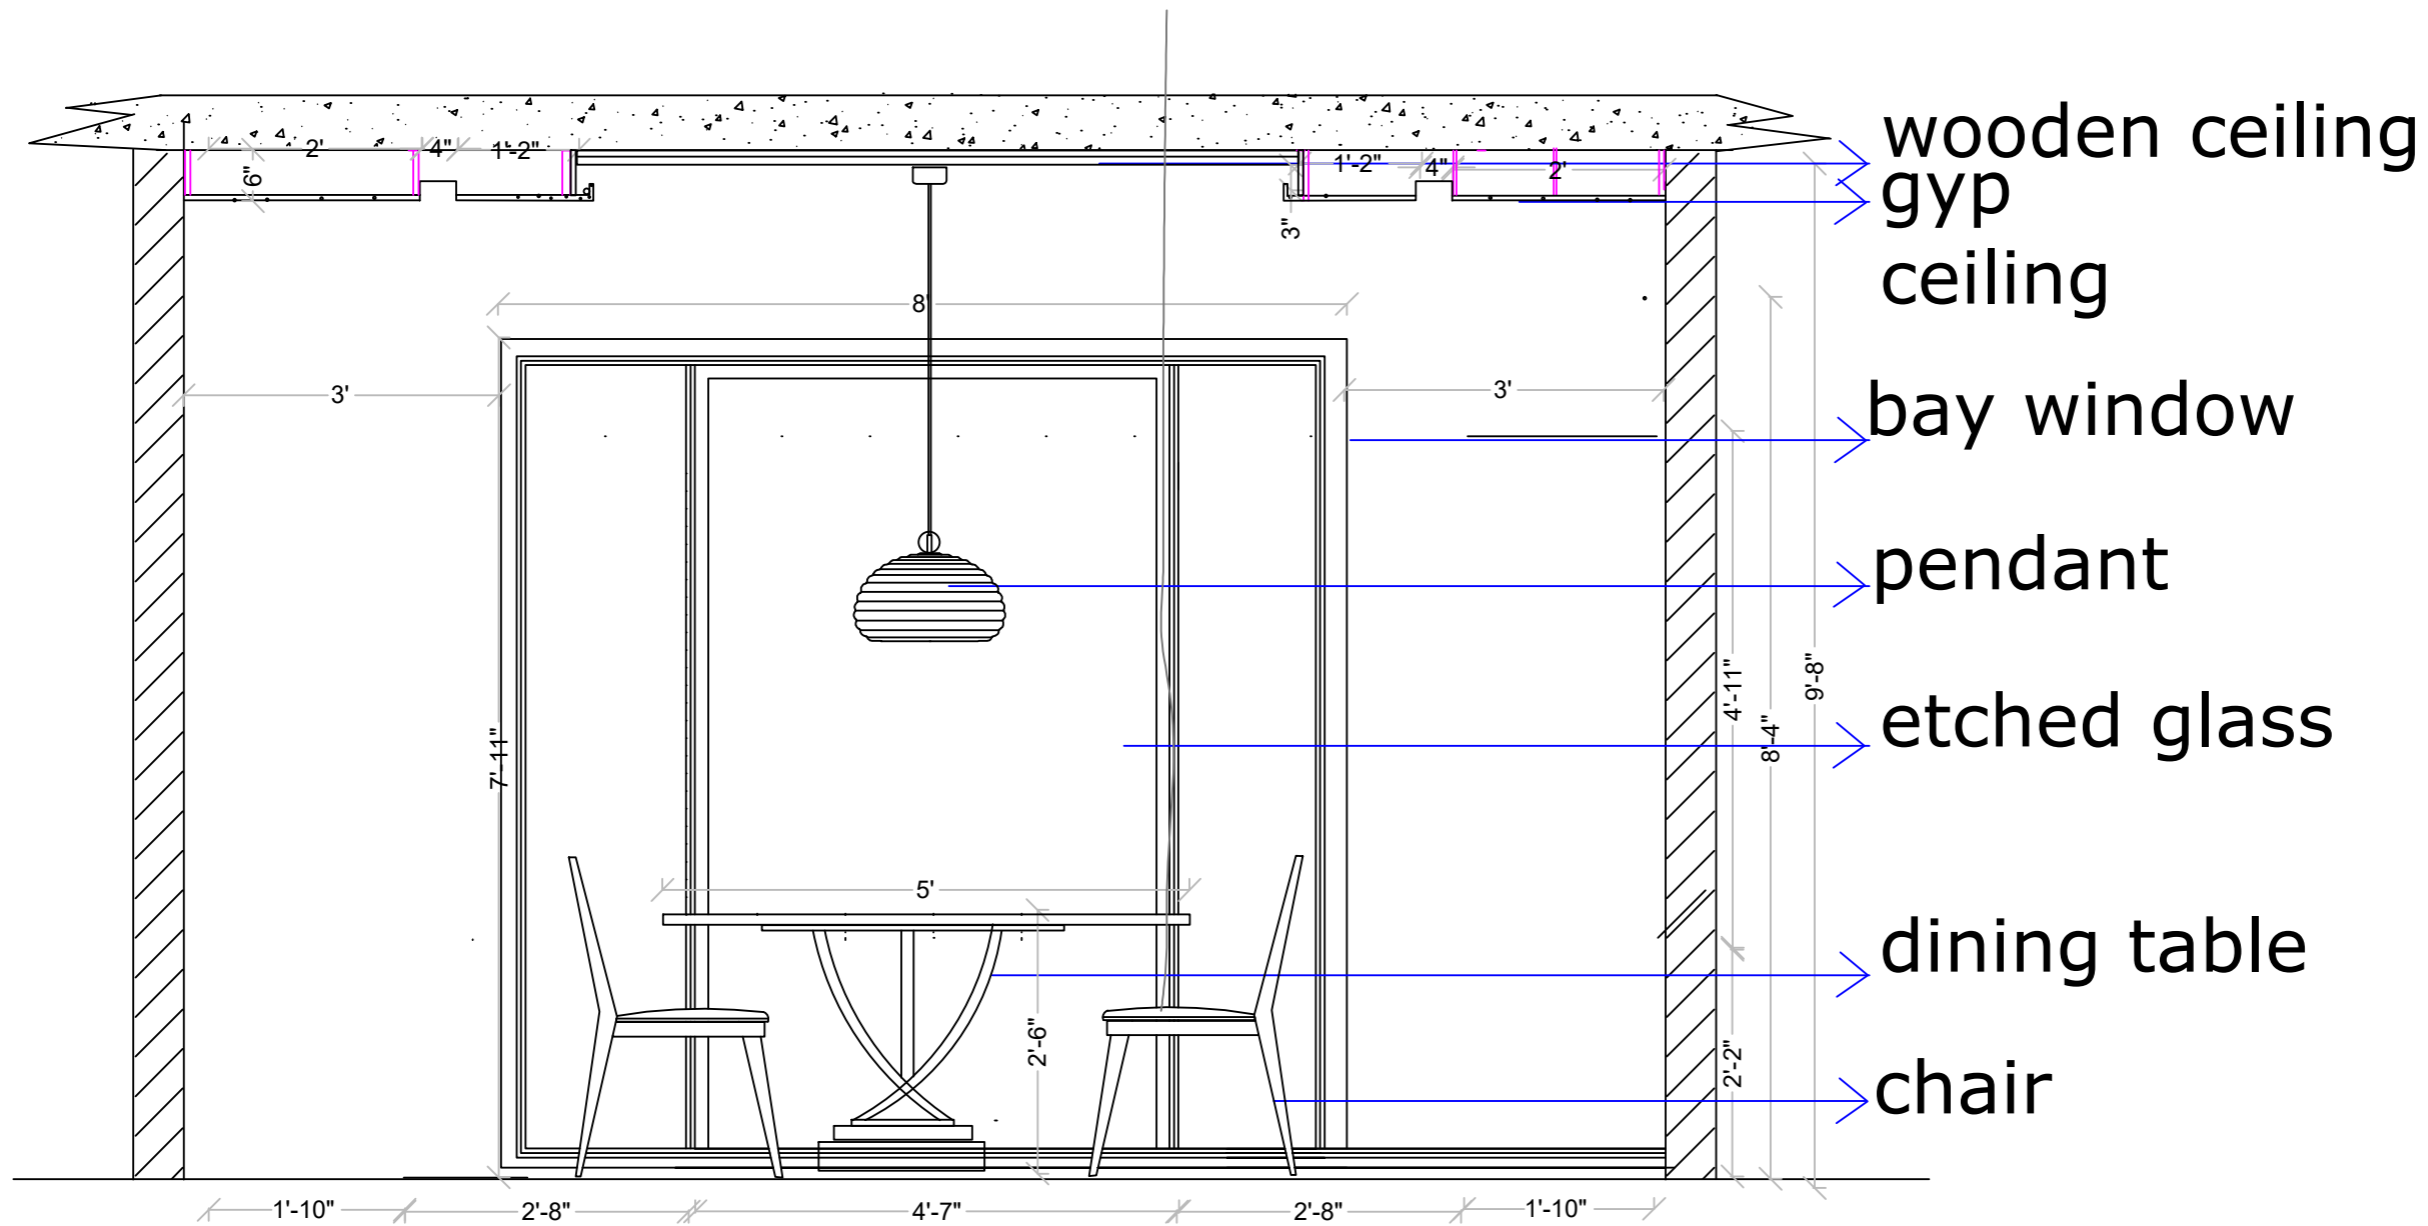

NOTES

 
1. THIS DRAWING IS THE PROPERTY OF **Builders and Designers (A Unit of MAESTER (R))**, AND SHALL NOT BE COPIED OR USED WITHOUT PRIOR PERMISSION.
2. THE DRAWING IS NOT TO THE SCALE. ONLY WRITTEN DIMENSION SHALL BE FOLLOWED.
3. ALL DIMENSIONS ARE IN MM.

TITLE

Dining Area

SCALE: NTS

CLIENT:-
Tulsiyan Family



DATE OF ISSUE: 21.04.2026

REVISIONS

SHEET
A3

SN	REVISION NO	DATE
01	R0	21-04-2026
02		
03		



DESIGN BY TABREZ


DRAWN BY TAHER

CHECKED BY TABREZ

DRAWING NO RWSH-12

ALL DIMENSIONS ARE IN FT

Cabinet wall

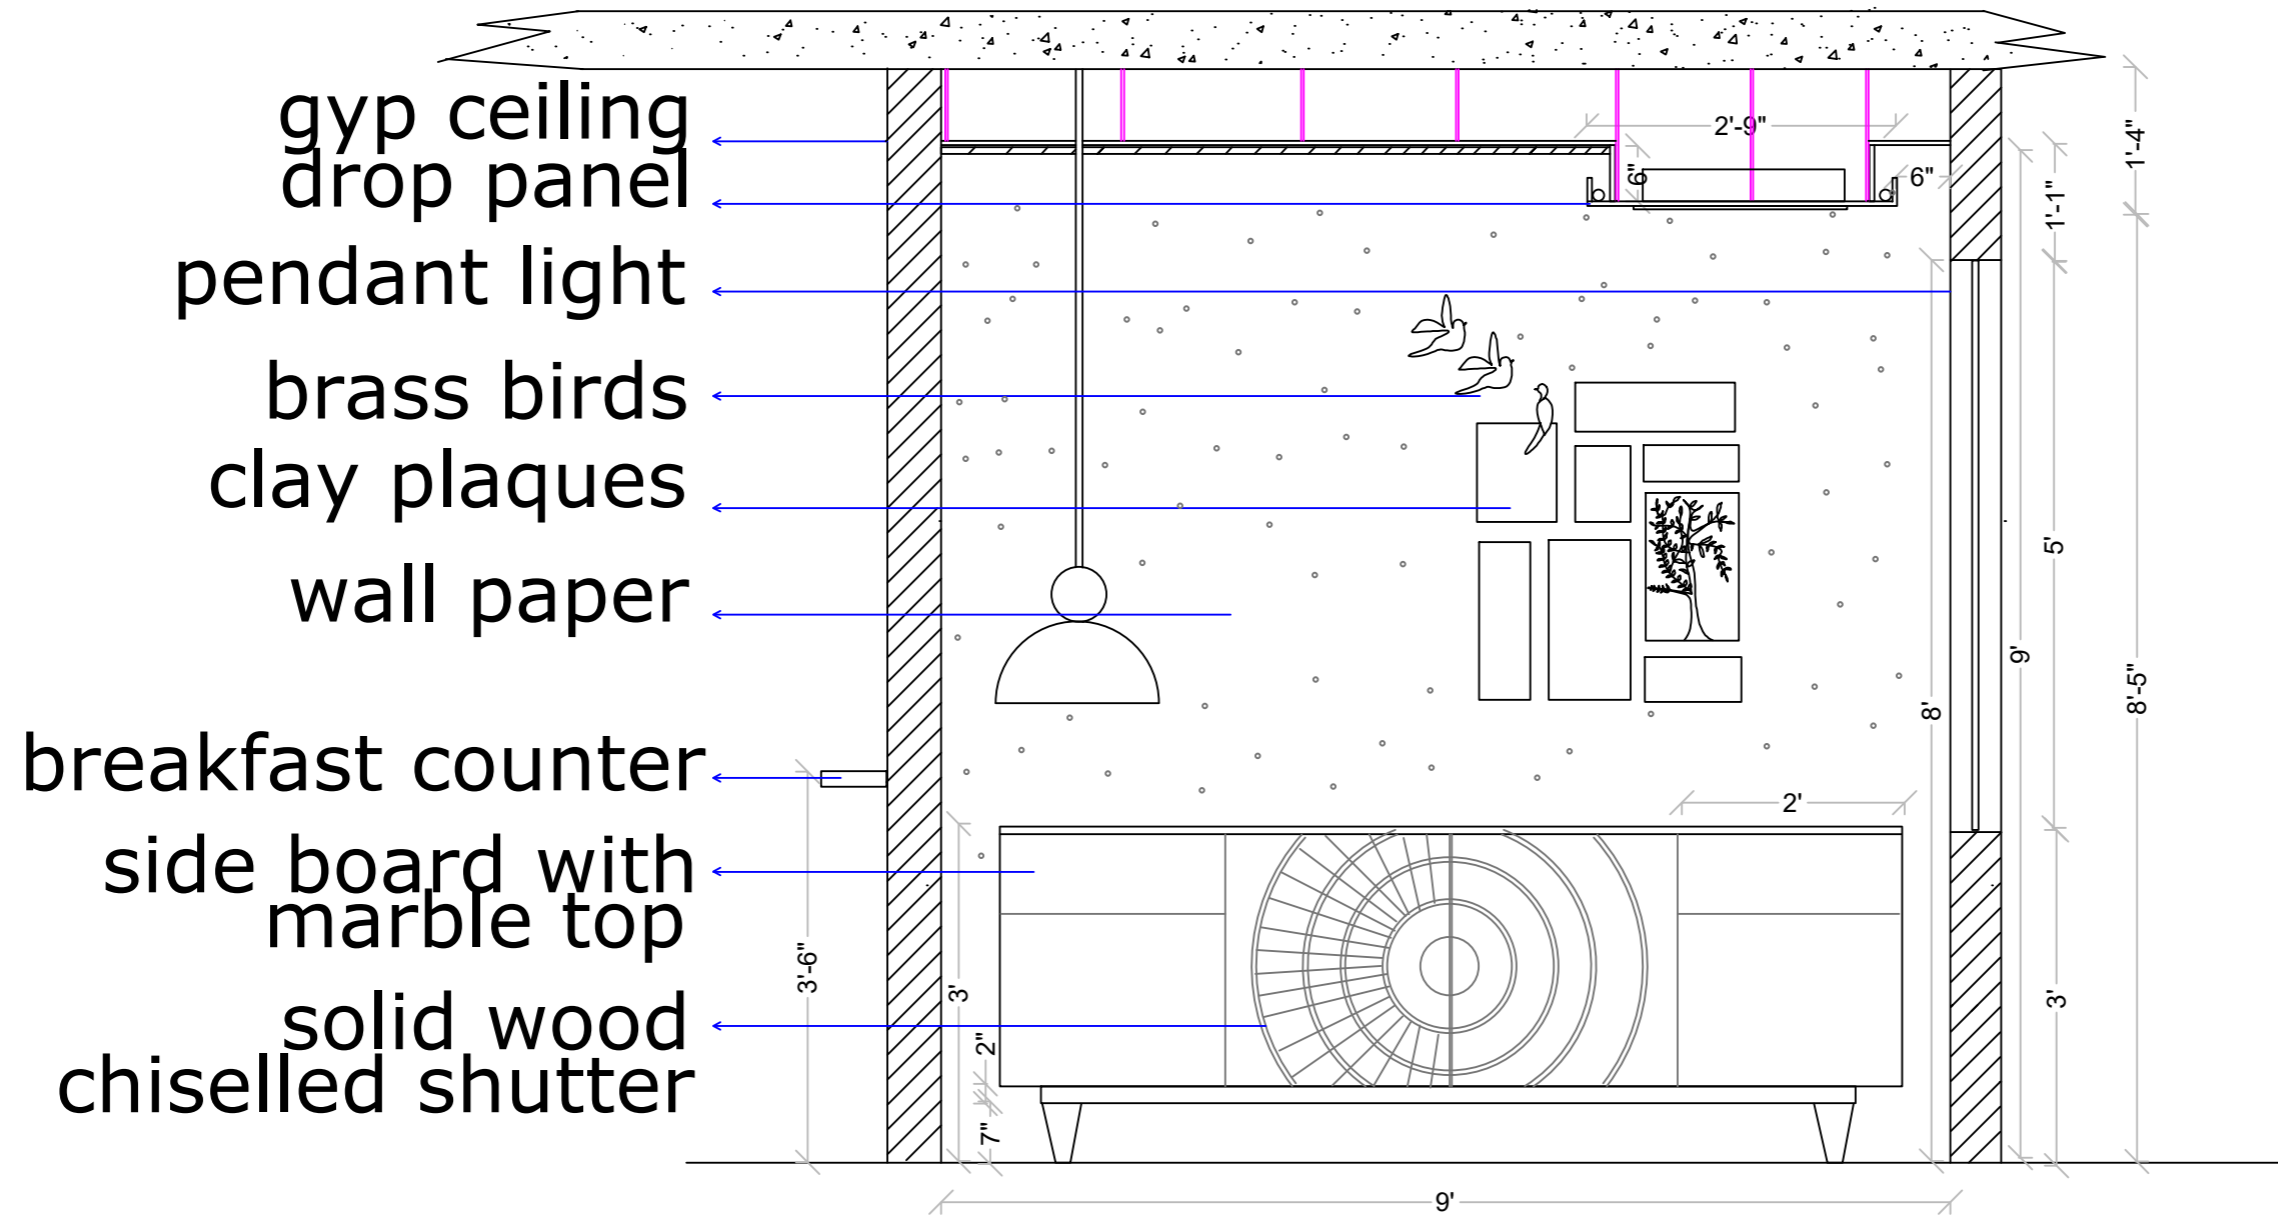

NOTES

 
1. THIS DRAWING IS THE PROPERTY OF **Builders and Designers (A Unit of MAESTER (R))**, AND SHALL NOT BE COPIED OR USED WITHOUT PRIOR PERMISSION.
2. THE DRAWING IS NOT TO THE SCALE. ONLY WRITTEN DIMENSION SHALL BE FOLLOWED.
3. ALL DIMENSIONS ARE IN MM.

TITLE

Cabinet wall

SCALE: NTS

CLIENT:-
Tulsiyan Family



DATE OF ISSUE: 21.04.2026

REVISIONS

SN	REVISION NO	DATE
01	R0	21-04-2026
02		
03		




DESIGN BY TABREZ

DRAWN BY TAHER

CHECKED BY TABREZ

DRAWING NO RWSH-12

ALL DIMENSIONS ARE IN FT

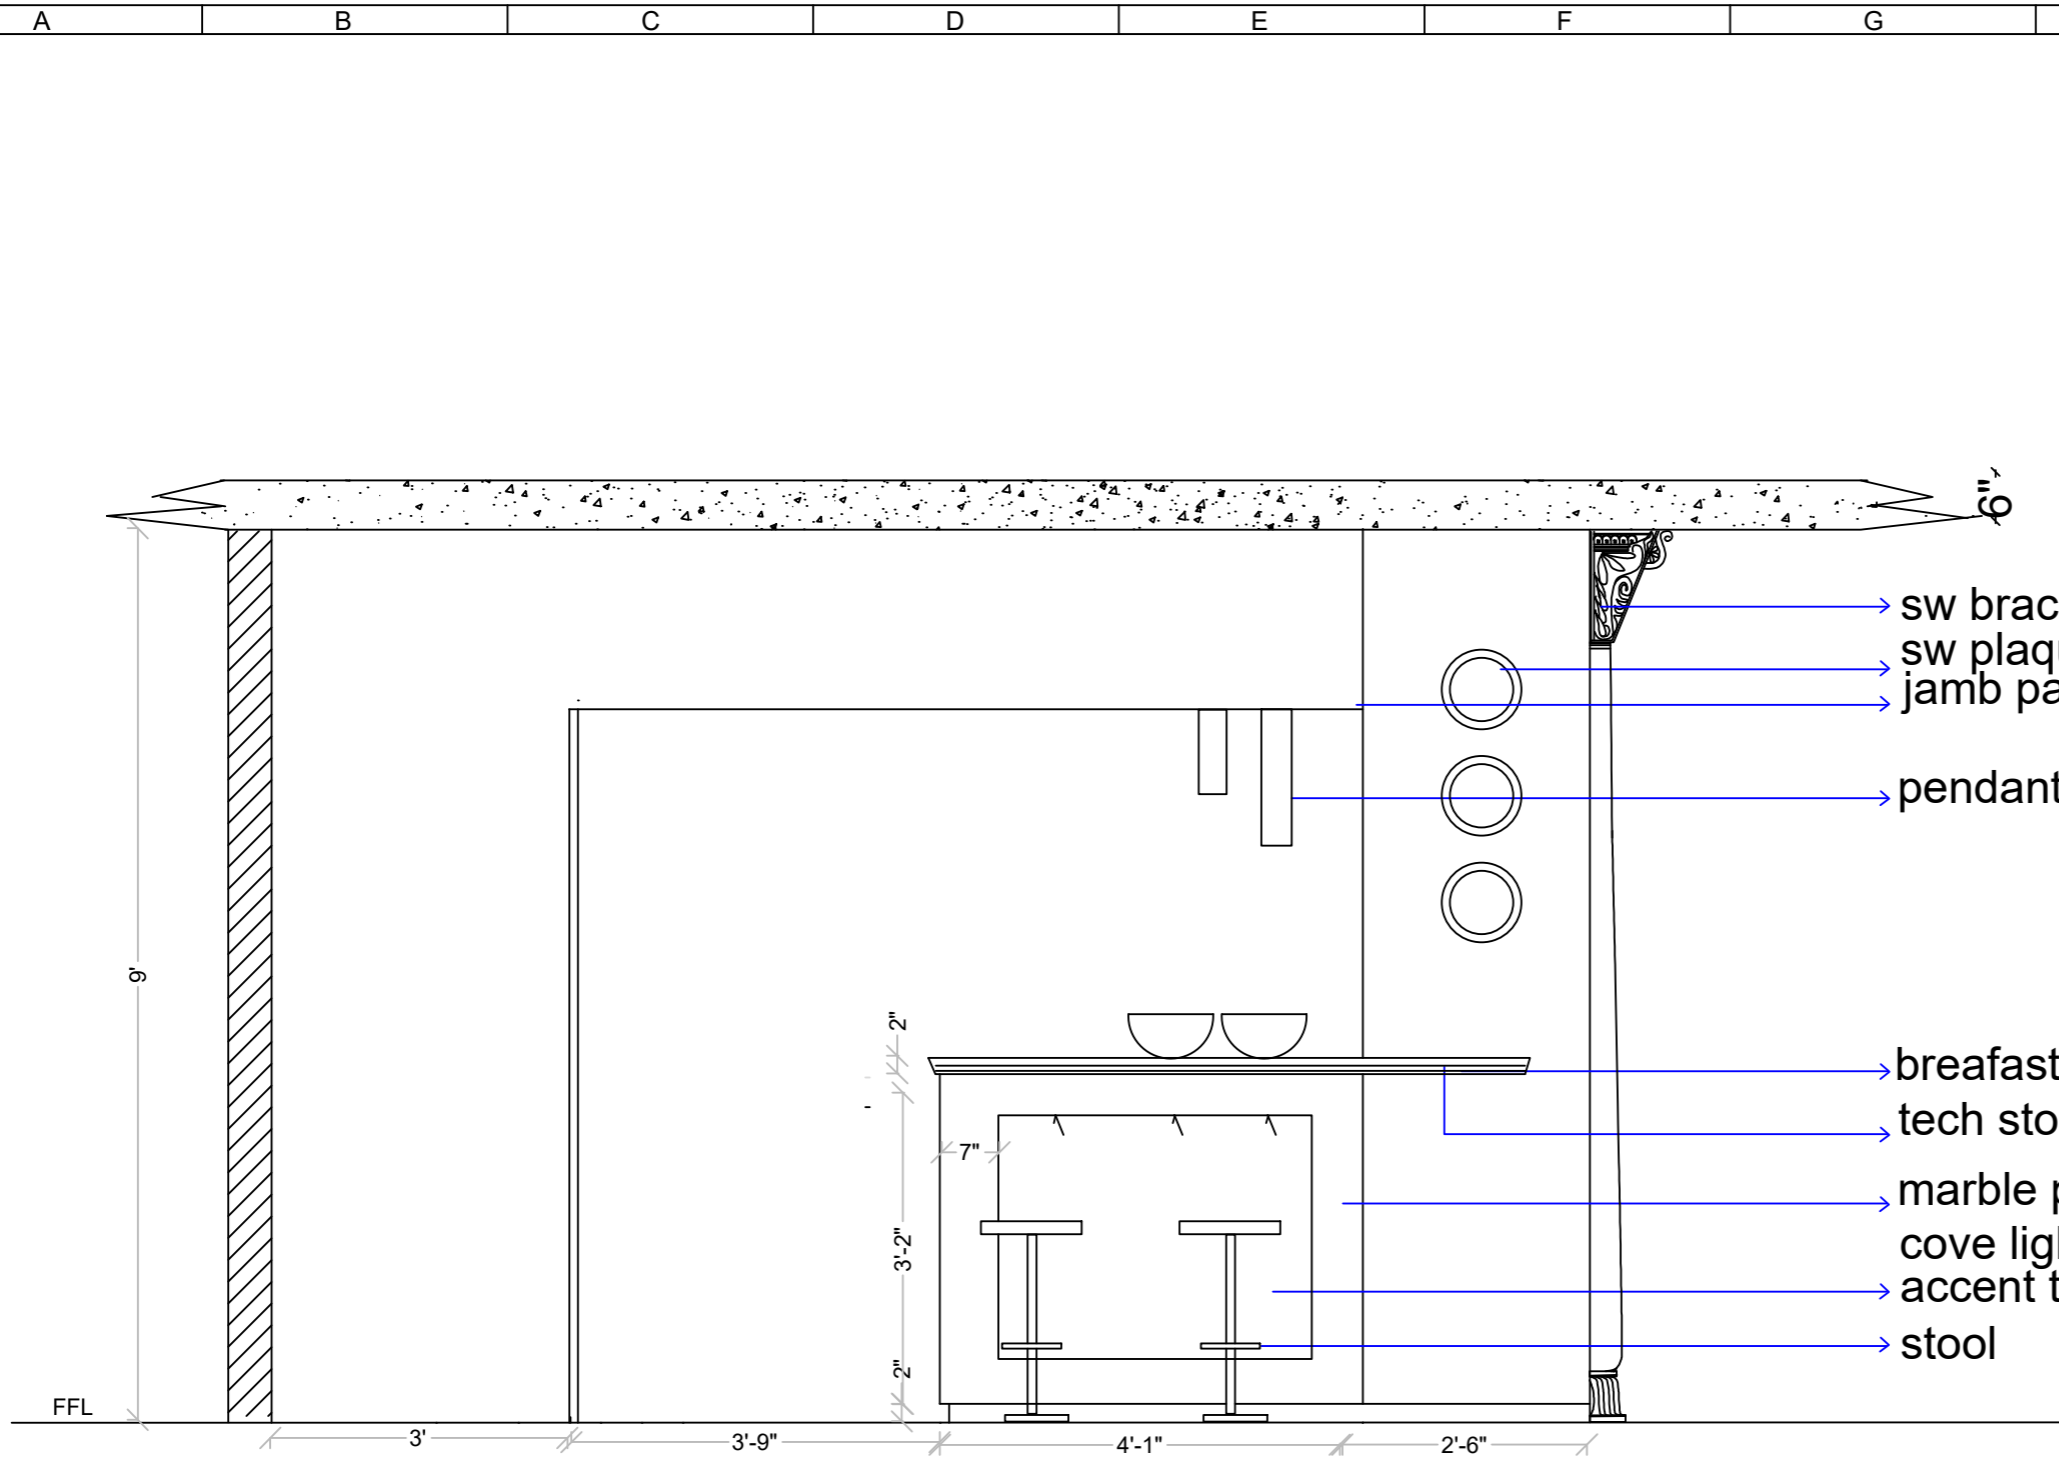

BREAKFAST COUNTER WALL (DINING SIDE)

NOTES


1. THIS DRAWING IS THE PROPERTY OF **Builders and Designers (A Unit of MAESTER (R))**, AND SHALL NOT BE COPIED OR USED WITHOUT PRIOR PERMISSION.
2. THE DRAWING IS NOT TO THE SCALE. ONLY WRITTEN DIMENSION SHALL BE FOLLOWED.
3. ALL DIMENSIONS ARE IN MM.

TITLE

BREAKFAST COUNTER WALL

SCALE: NTS


CLIENT:-
Tulsiyan Family

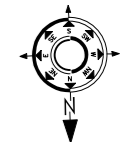

DATE OF ISSUE: 21.04.2026

REVISIONS

SN	REVISION NO	DATE
01	R0	21-04-2026
02		
03		

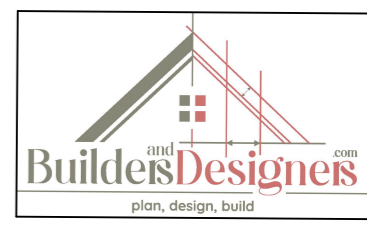

DESIGN BY TABREZ

DRAWN BY TAHER


CHECKED BY TABREZ

DRAWING NO RWSH-12

ALL DIMENSIONS ARE IN FT

A B C D E F G H I J

1
2
3
4
5
6
7

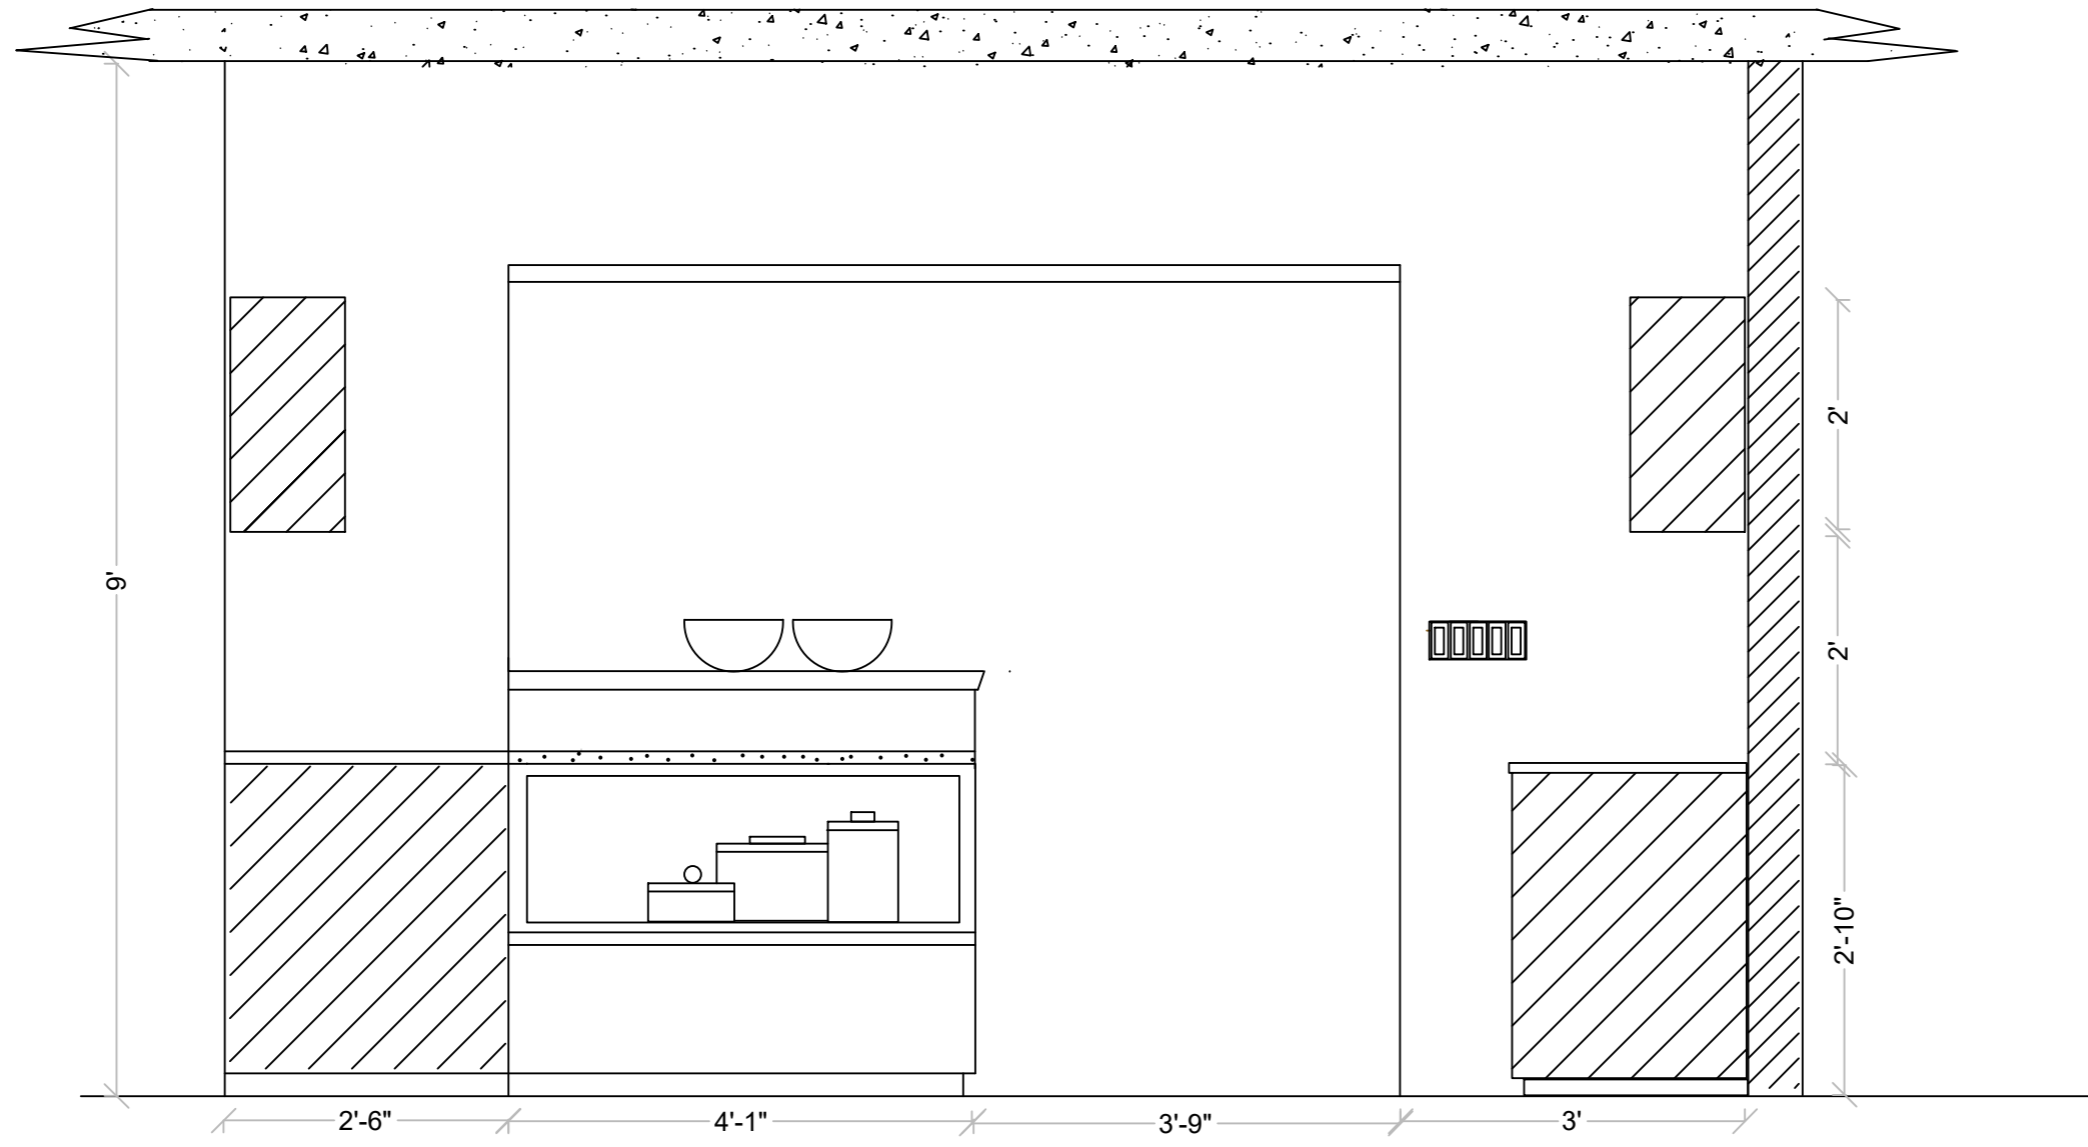

BREAKFAST COUNTER WALL (KITCHEN SIDE)


NOTES

1. THIS DRAWING IS THE PROPERTY OF **Builders and Designers (A Unit of MAESTER (R))**, AND SHALL NOT BE COPIED OR USED WITHOUT PRIOR PERMISSION.
2. THE DRAWING IS NOT TO THE SCALE. ONLY WRITTEN DIMENSION SHALL BE FOLLOWED.
3. ALL DIMENSIONS ARE IN MM.

TITLE

BREAKFAST COUNTER WALL

SCALE: NTS
CLIENT:-
Tulsiyan Family

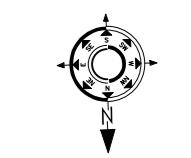


DATE OF ISSUE: 21.04.2026

REVISIONS

SN	REVISION NO	DATE
01	R0	21-04-2026
02		
03		

SHEET
A3

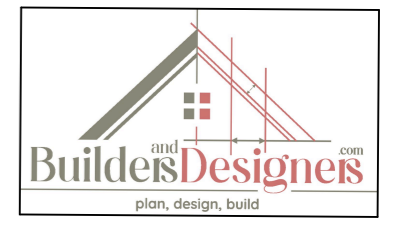


DESIGN BY TABREZ
DRAWN BY TAHER
CHECKED BY TABREZ
DRAWING NO RWSH-12

ALL DIMENSIONS ARE IN FT

J

Living, Bar wall-option 2

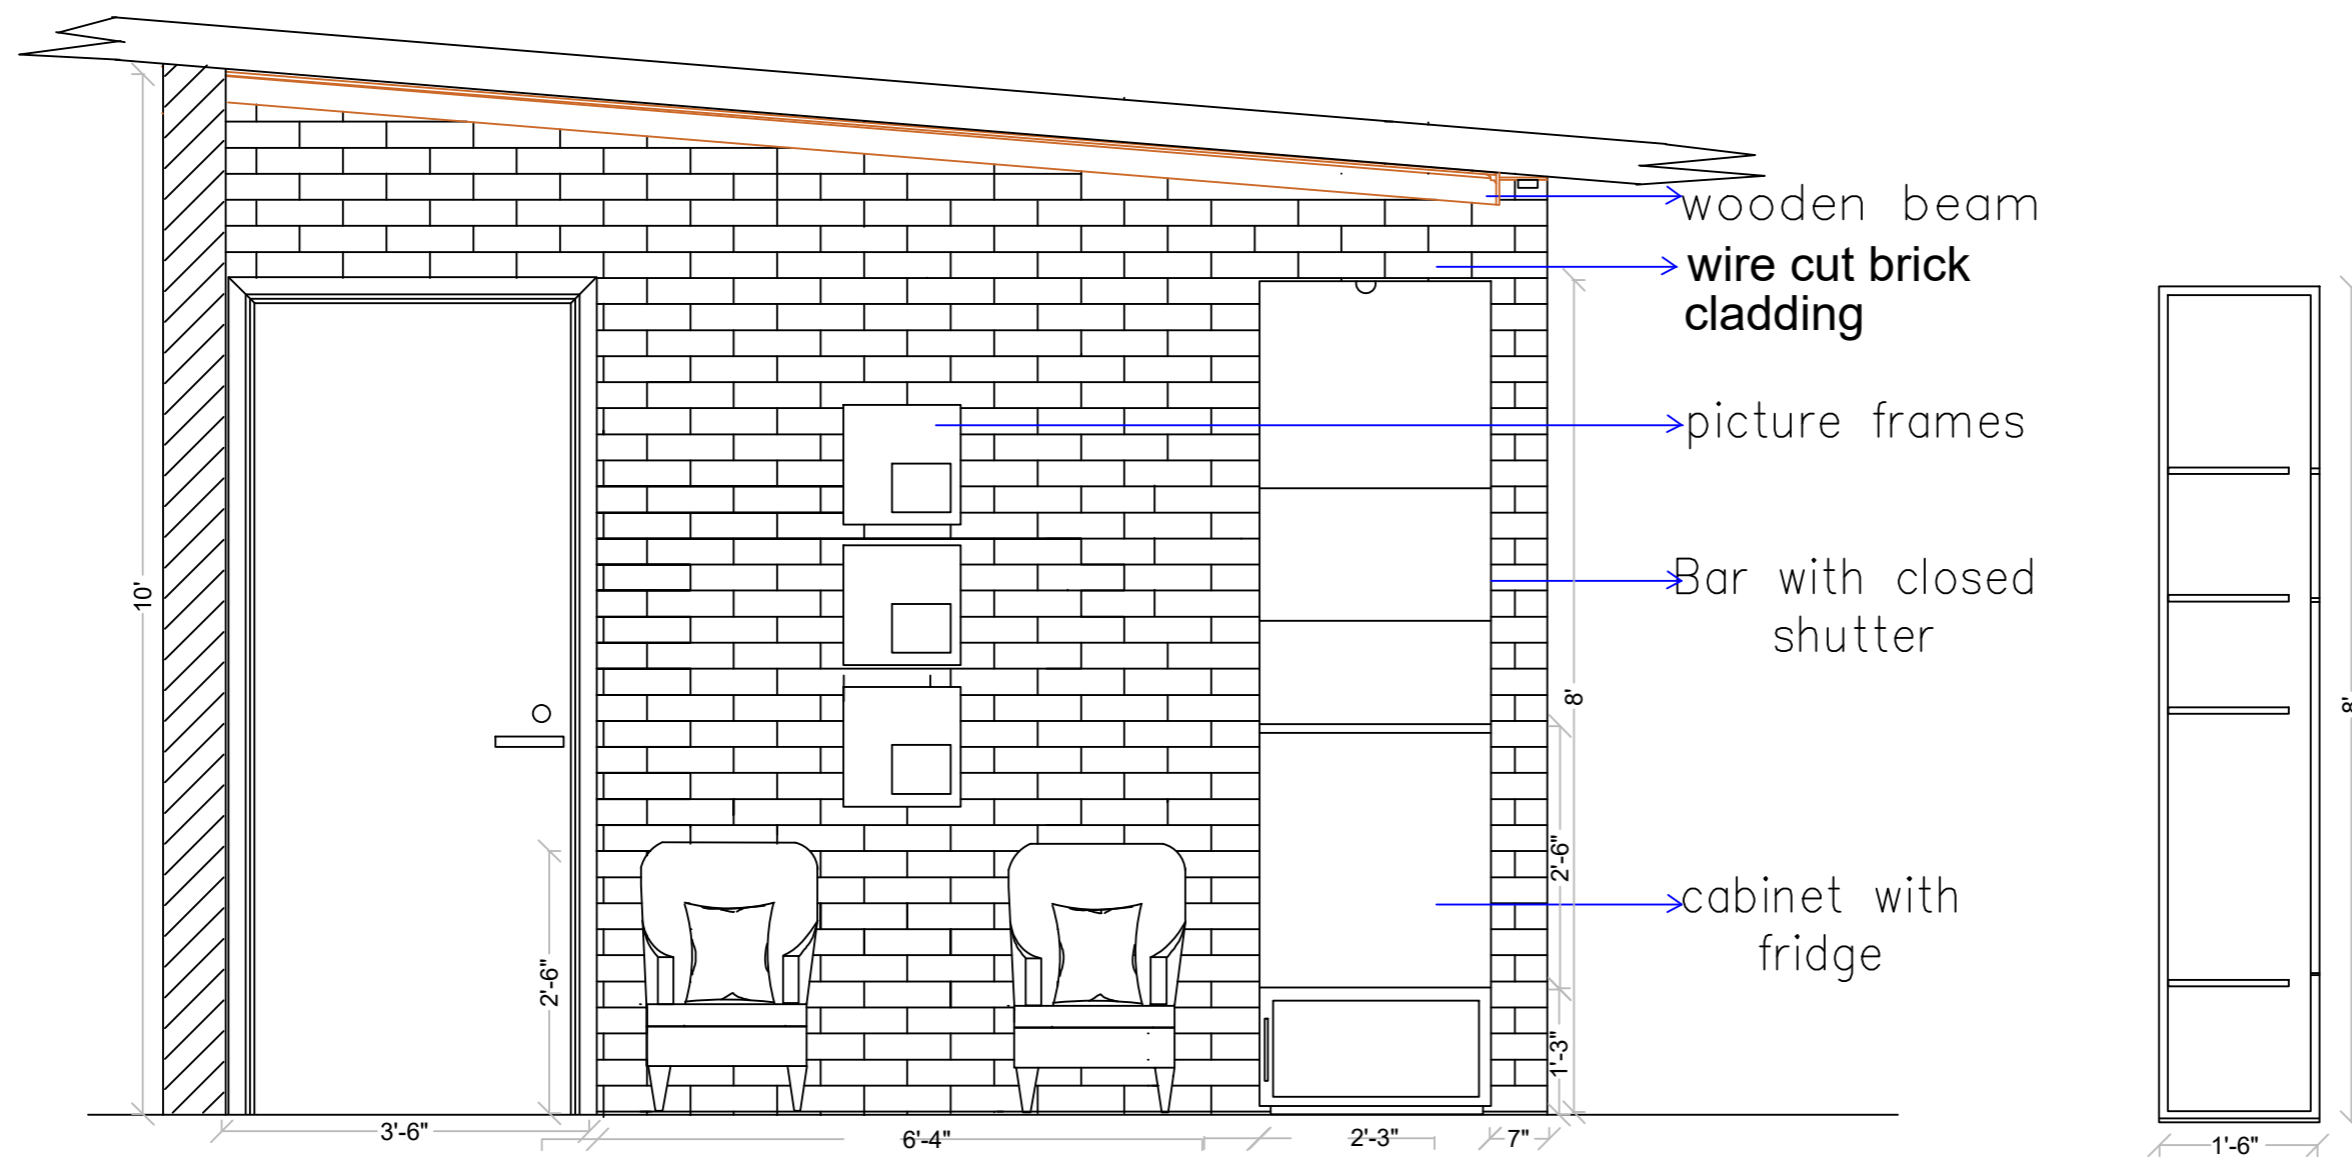

NOTES


1. THIS DRAWING IS THE PROPERTY OF **Builders and Designers (A Unit of MAESTER (R))**, AND SHELL NOT BE COPIED OR USED WITHOUT PRIOR PERMISSION.
2. THE DRAWING IS NOT TO THE SCALE. ONLY WRITTEN DIMENSION SHALL BE FOLLOWED.
3. ALL DIMENSIONS ARE IN MM.

TITLE

Living, Bar wall Option 2

SCALE: NTS

CLIENT:-
Tulsiyan Family

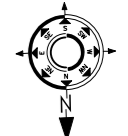

DATE OF ISSUE: 21.04.2026

REVISIONS SHEET A3

SN	REVISION NO	DATE
01	R0	21-04-2026
02		
03		



DESIGN BY TABREZ

DRAWN BY TAHER

CHECKED BY TABREZ

DRAWING NO RWSH-12

ALL DIMENSIONS ARE IN FT