


A B C D E F G H I J

1  
2  
3  
4  
5  
6  
7

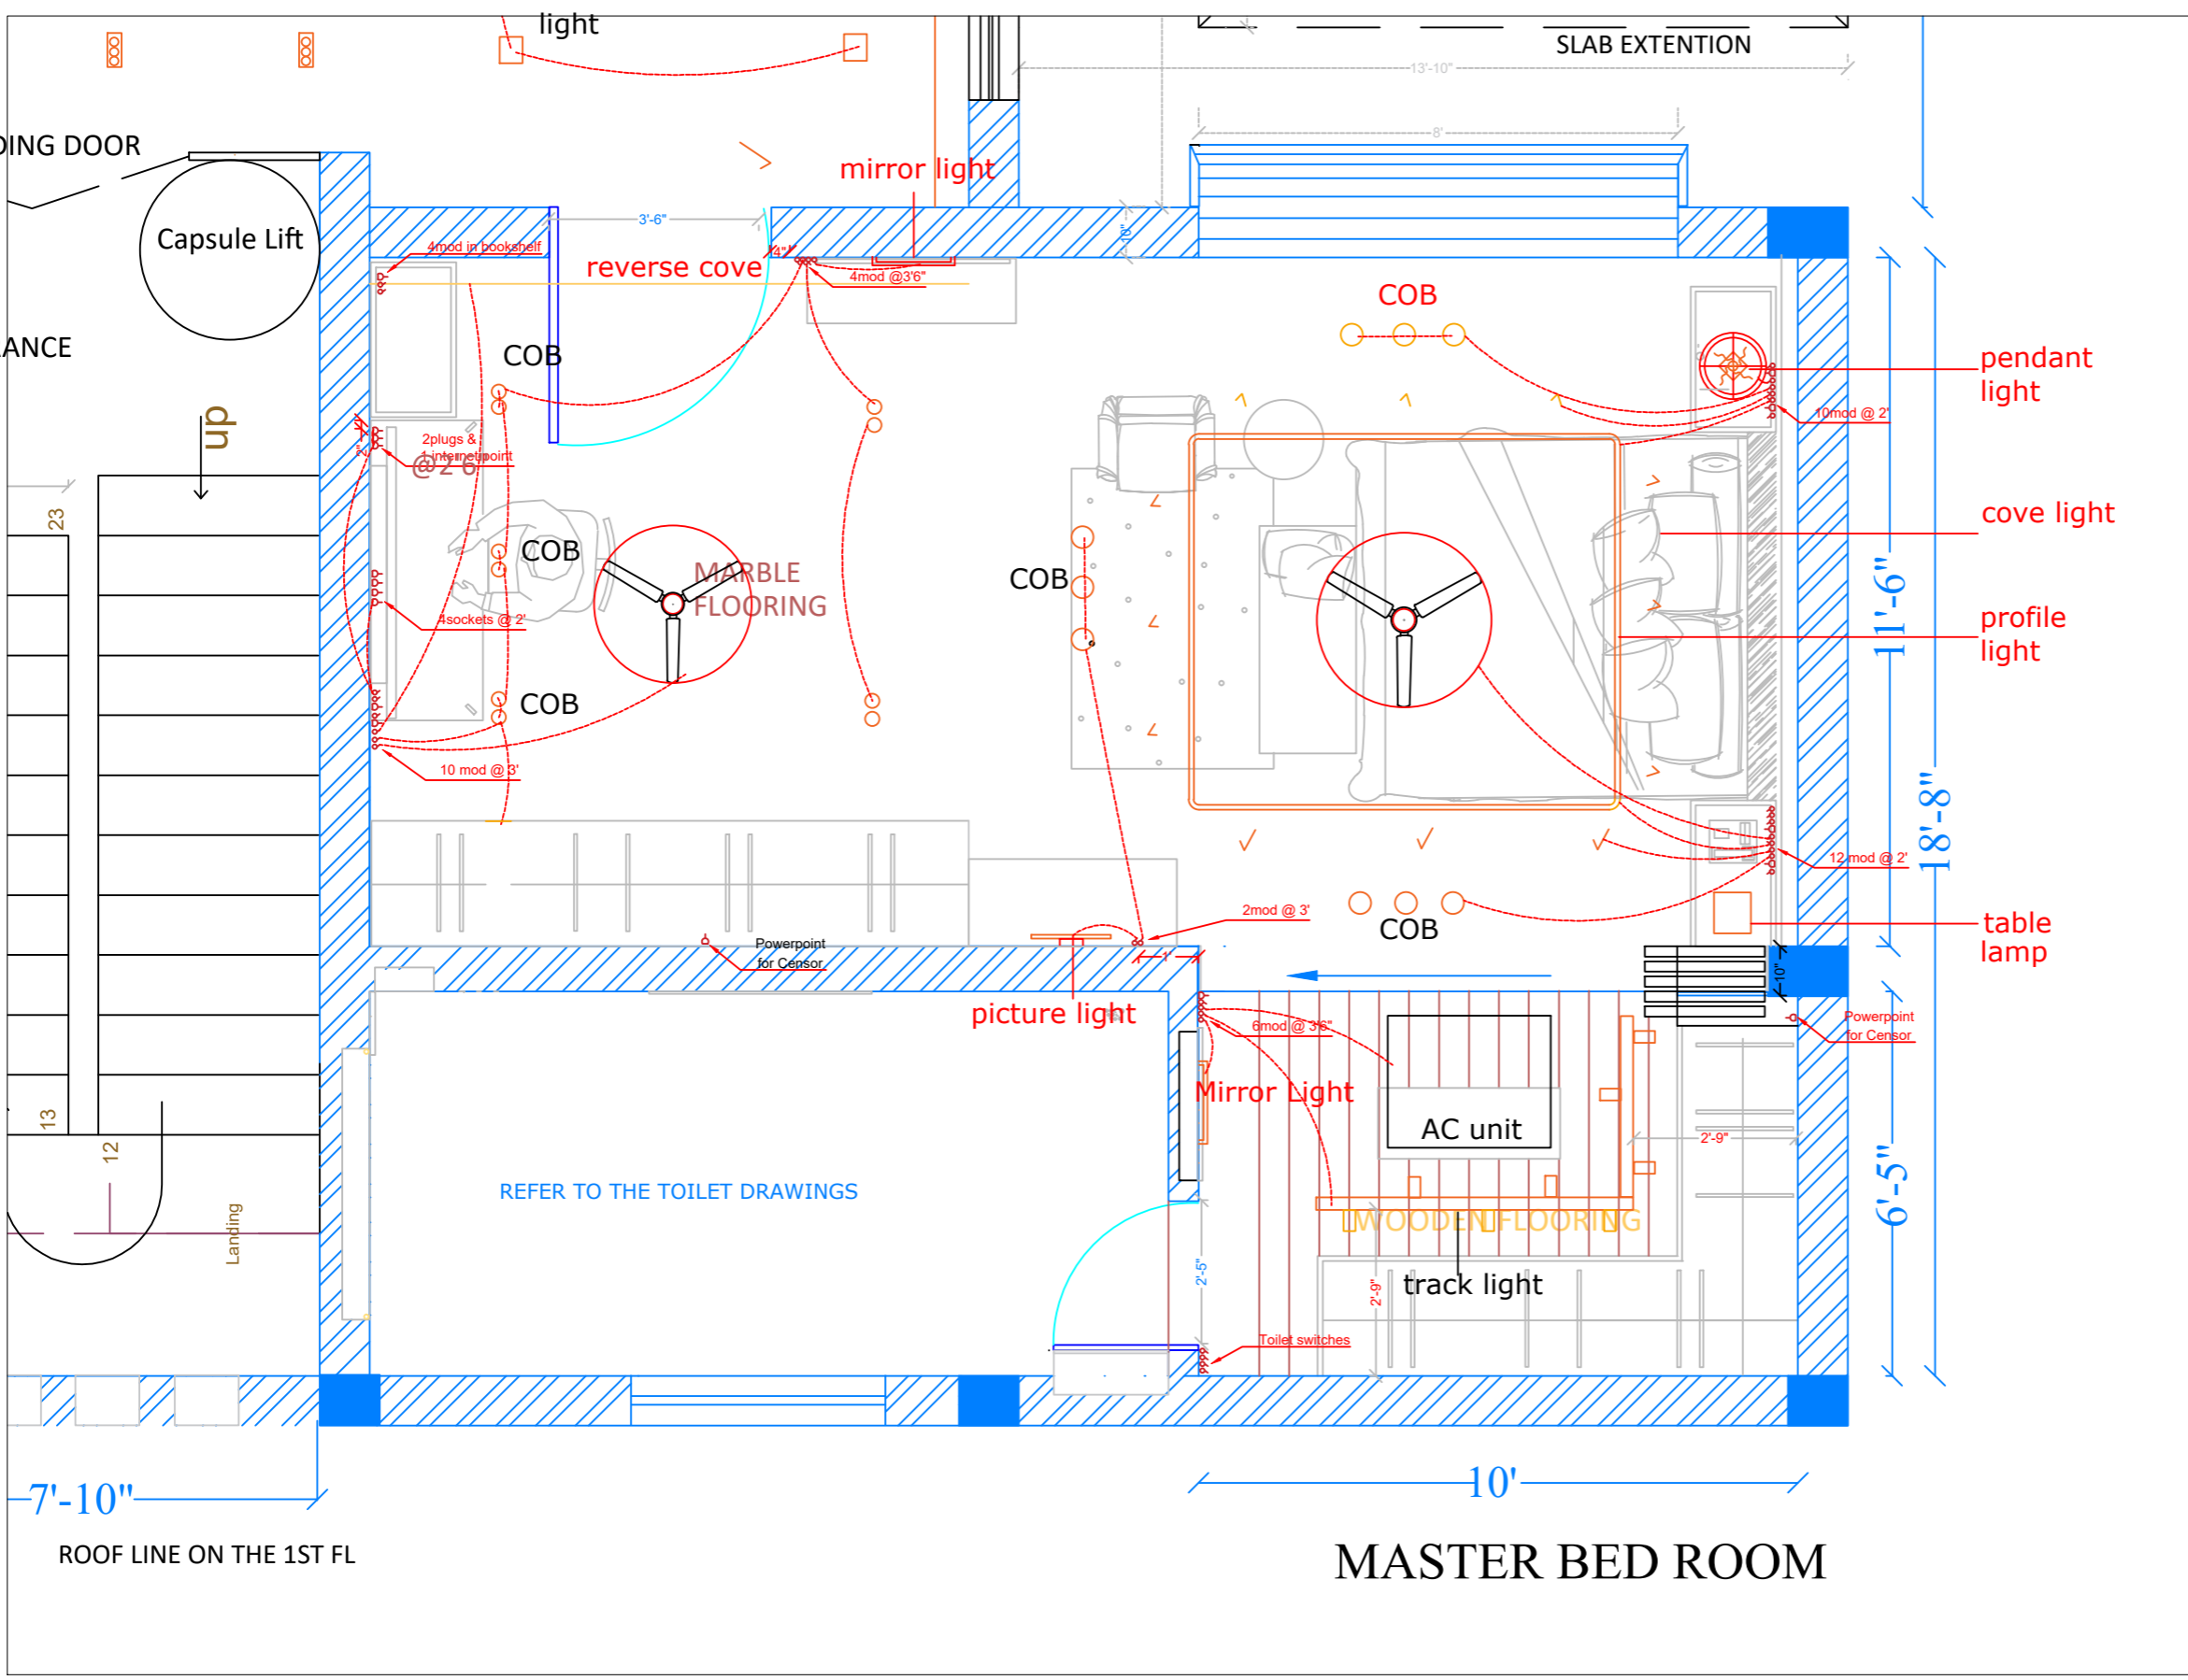

**NOTES**


1. THIS DRAWING IS THE PROPERTY OF **Builders and Designers (A Unit of MAESTER (R))**, AND SHALL NOT BE COPIED OR USED WITHOUT PRIOR PERMISSION.
2. THE DRAWING IS NOT TO THE SCALE. ONLY WRITTEN DIMENSION SHALL BE FOLLOWED.
3. ALL DIMENSIONS ARE IN MM.

**TITLE**

**Master Bedroom Electrical Layout**

SCALE: NTS


CLIENT:-  
Tulsiyan Family

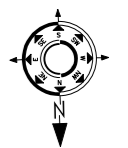

DATE OF ISSUE: 21.04.2026

REVISIONS SHEET A3

SN	REVISION NO	DATE
01	R0	21-04-2026
02		
03		

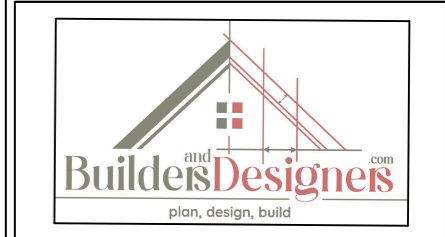

DESIGN BY TABREZ

DRAWN BY TAHER

CHECKED BY TABREZ

DRAWING NO RWSH-12

ALL DIMENSIONS ARE IN FT

**MASTER BED ROOM**